
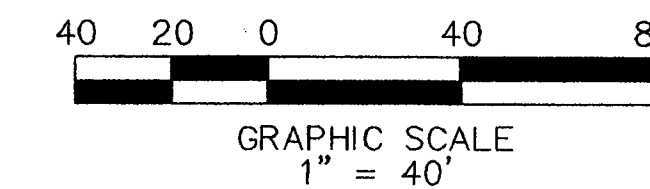


CENTRUM HILLSBORO PLAT
(P.B. 148, PG. 6, B.C.R.)

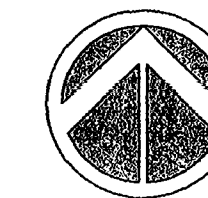

Sun-Tech Engineering, Inc.
Engineers - Planners - Surveyors
Phone (954)777-3123
Fax (954)777-3114
1800 West Oakland Park Boulevard
Ft. Lauderdale, FL 33311
E-Mail: suntech@suntechengineering.com

NO.	DATE	DESCRIPTION
1	01-15-02	PER CITY REVIEW
2	02-04-02	PER REVISED SITE PLAN
3	03-08-02	REVISED SOUTH ENTRANCE

WESTCREEK COMMONS
FLORIDA
COCONUT CREEK
WATER & SEWER PLAN

DATE:
NOV., 2001

SCALE:
1" = 40'



DESIGNED BY:
M.G.

DRAWN BY:
A.E.V.

JOB NUMBER
01-2486

SHEET NO.
WS1

SEAL
APR 0 8 2002
Scales Construction

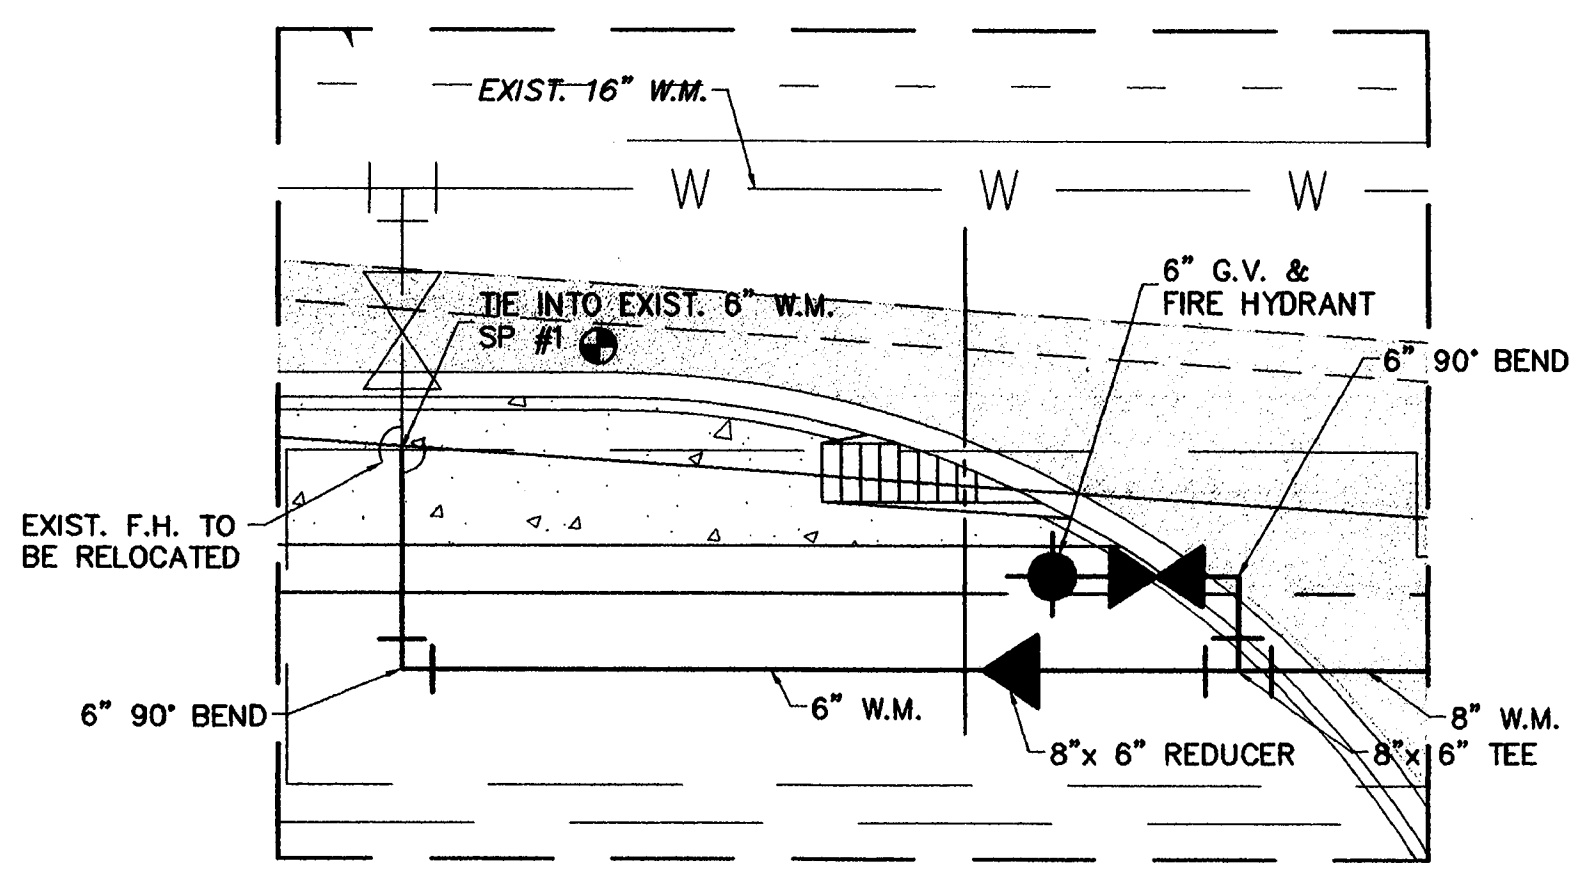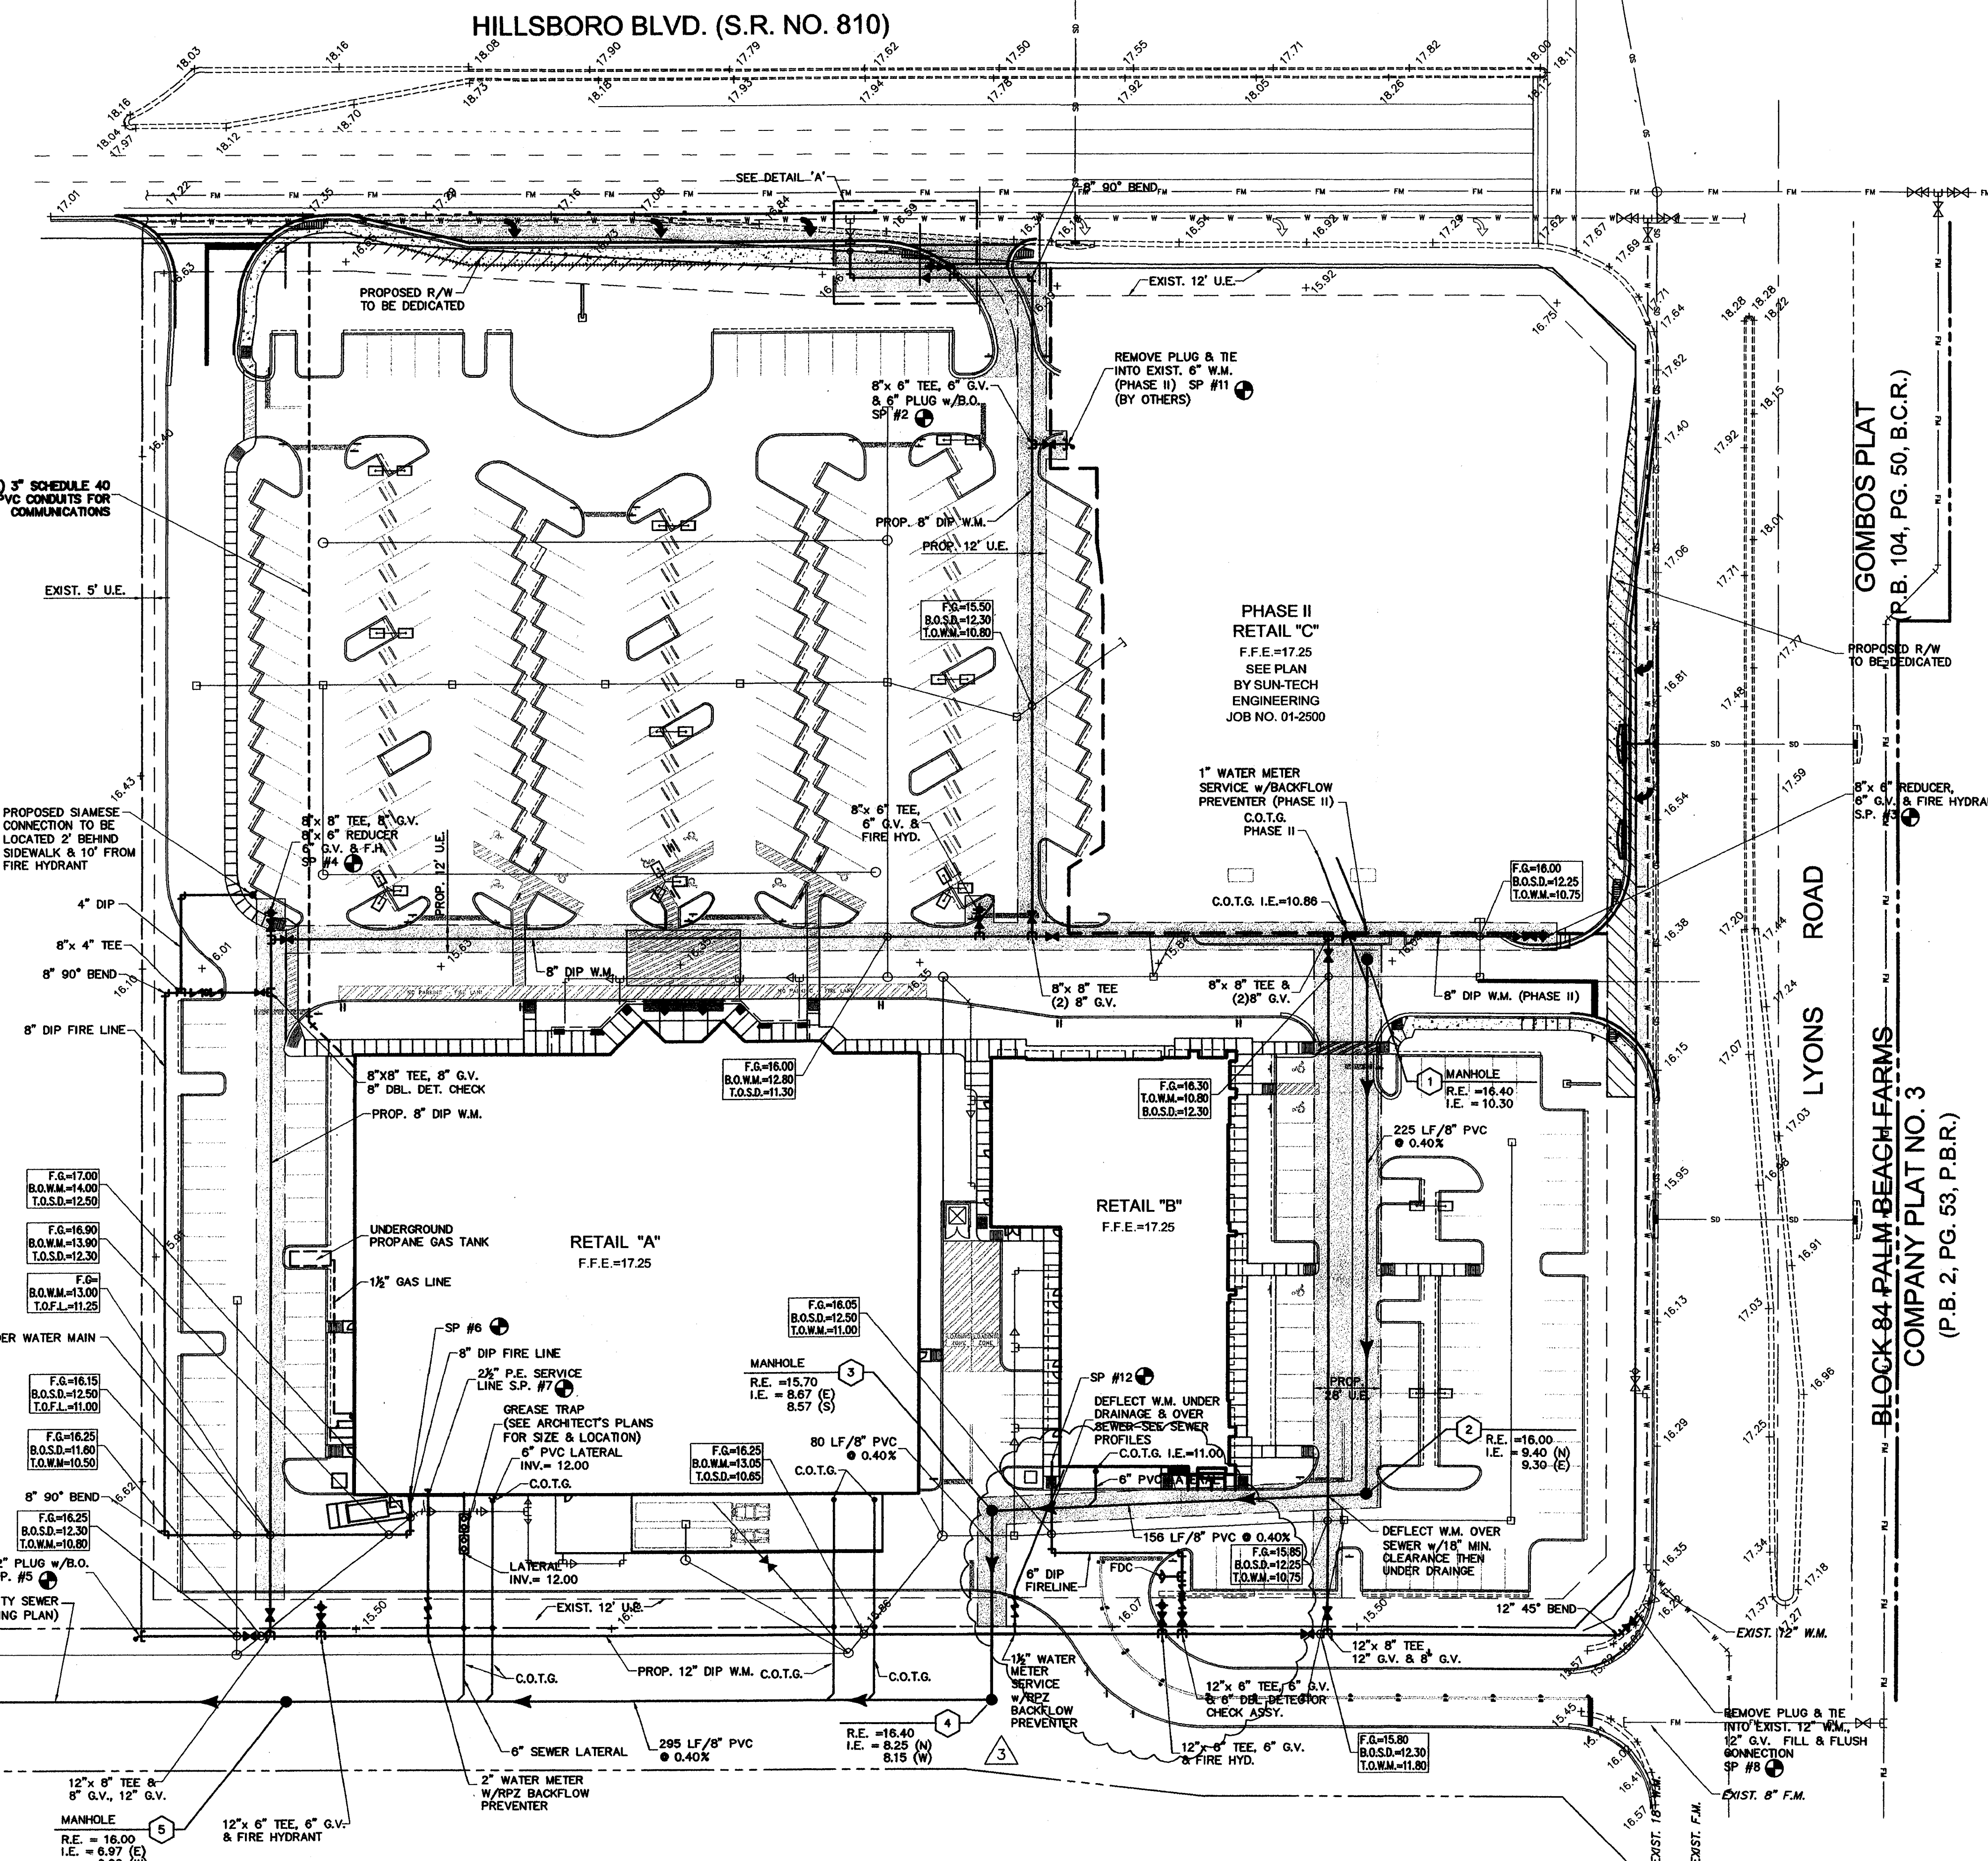

DETAIL 'A'
SCALE: 1"=10'

WATER & SEWER LEGEND

	DOUBLE WATER METER SERVICE
	SINGLE WATER METER SERVICE
	LENGTH, SIZE & TYPE OF WATER MAIN
	FIRE HYDRANT, GATE VALVE & TEE ASSEMBLY
	PROPOSED GATE VALVE
	BACTERIOLOGICAL SAMPLING POINT
	EXISTING OR FUTURE UTILITIES
	D.I.P. PIPE
	RIM ELEVATION
	INVERT ELEVATION
	MANHOLE DESIGNATION
	LENGTH & SLOPE OF PIPE
	DOUBLE SEWER LATERAL
	SINGLE SEWER LATERAL
	CLEAN OUT TO GRADE

K:\PROJECTS\01-xxx\01-2486\DWG\2486ws.dwg
DATE: Mar 08, 2002 - 11:56am EST

APR 2 2002