



LIGHTING SCHEDULE				* - See note below	
Symbol	Qty	Catalog Number	Description	Manufacturer	LLF
⊕		LED Yale Series: A610T9LED/6ARC/C45T3 WITH WILMINGTON POLE: FM-18-0"	Main Street Pole Light w/ 18'-0" Mounting Height	Stenberg	na
⬤		Gardco Designer Spot: D5P1-5T-TRF-116P-42TRF-VOLTAGE-FINISH-C	LANDSCAPE UPLIGHT	Gardco	na
⬤		Color Kinetics W/ Blast Powercore: 523-002033-03 W/ DATA ENABLER 506-002001-00	ARCHITECTURAL/FACADE UPLIGHT	Color Kinetics	1111
⬤		Bronzelite: 515RG-120	FOUNTAIN LIGHT	Bronzelite	na

- NOTE:
1. LIGHT POLE TO MEET MAIN STREET DESIGN STANDARDS. APPROVED LIGHT HAS YET TO BE SELECTED.
 2. VEHICULAR AND PEDESTRIAN AREAS SHALL BE ILLUMINATED TO A MINIMUM OF 10 FOOTCANDLES WITH A MINIMUM/ MAXIMUM NOT TO EXCEED 12.1 PER CITY ORDINANCE.
 3. ALL LANDSCAPE UPLIGHTS TO BE SHIELDED TO PREVENT GLARE.
 4. LIGHT SYMBOLS REPRESENT FIXTURE LOCATIONS FOR LANDSCAPE AND HARDSCAPE COORDINATION. A COMPLETE LIGHTING PACKAGE INCLUDING PHOTOMETRICS FOR SITE LIGHTING WILL BE SUBMITTED TO THE CITY UPON SELECTION OF APPROVED MAIN STREET DESIGN STANDARD FIXTURES. INCLUDED WITHIN THE PACKAGE WILL BE DETAILS FOR EACH INDIVIDUAL FIXTURE SELECTION, POLES, PHOTOMETRICS, AND FINISHES.
 5. PALMS LOCATED PERPENDICULAR TO LIGHT POLE HAVE BEEN SPECIFIED WITH CLEAR WOOD HEIGHTS GREATER THAN THE LIGHT SOURCE. ALL FRONDS WILL BE ABOVE FIXTURE HEADS.

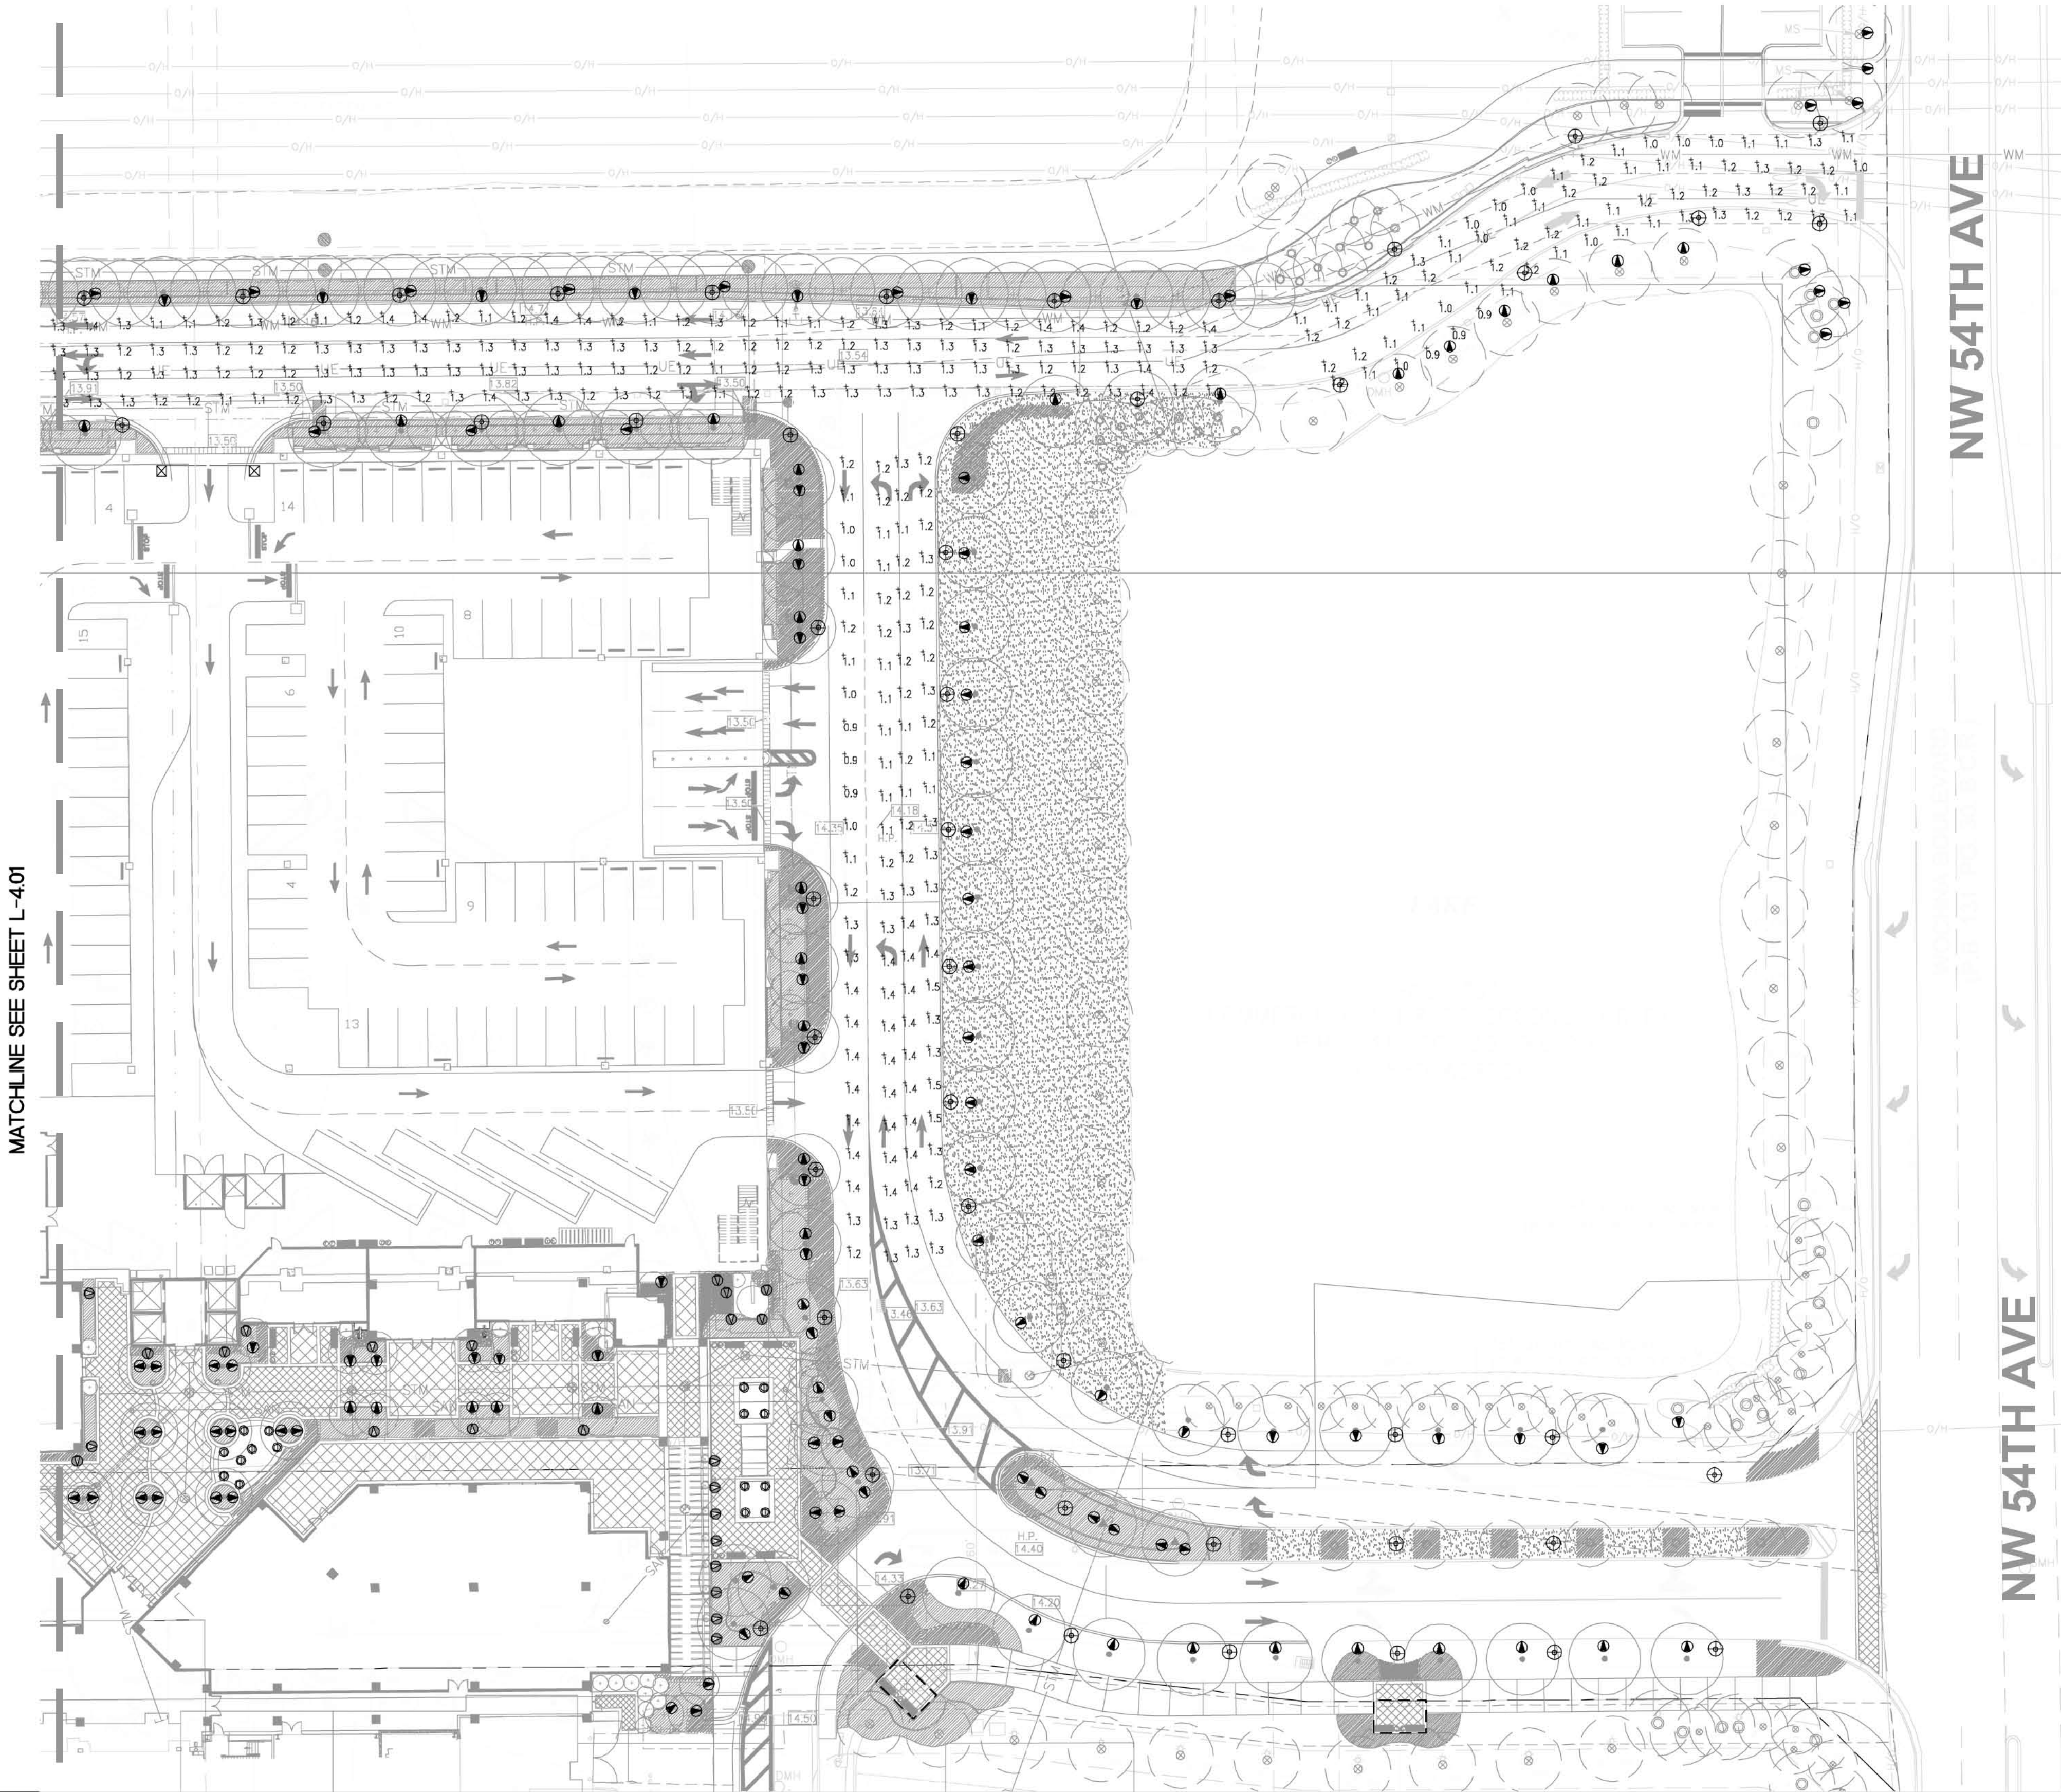


KEY MAP

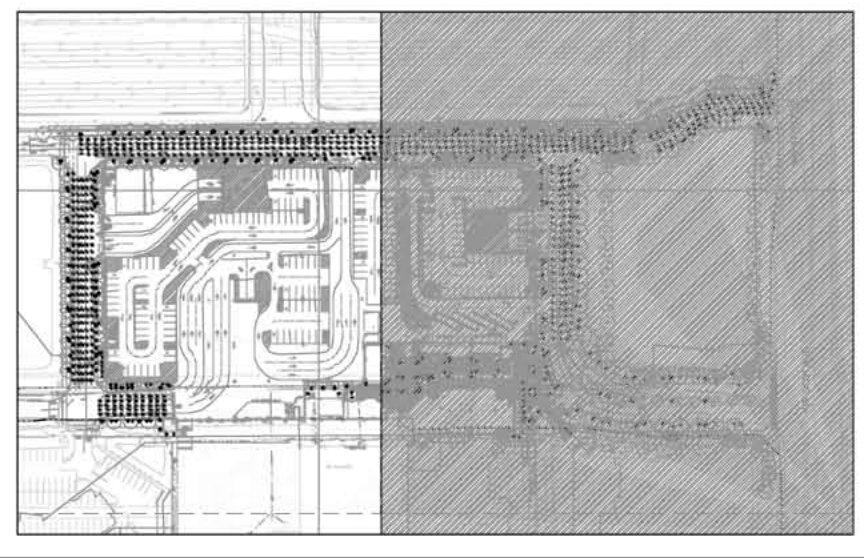

Parkway Lighting
Model VILLAGE - LONDON
Manufacturer BEACON

- Options
- LED
 - Sustainability
 - LED
 - Full Cut-off
 - Solar Power

Secondary Street Pole

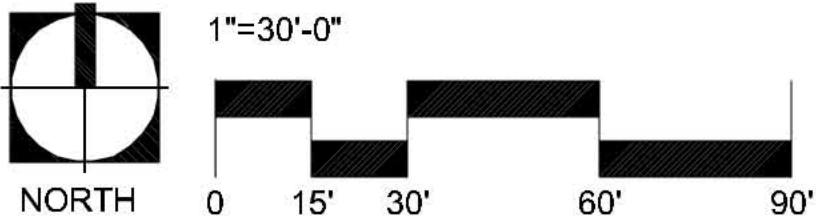

Δ	Date	Description

EDSA

Michael Singer Inc.

South Studio - Doral Beach, FL

561-267-3344

msinger@edsa.com

FRIDMUTTER GROUP

ARCHITECTURAL & DESIGN STUDIOS

ARCHITECTURE • INTERIOR DESIGN • LANDSCAPE ARCHITECTURE • PLANNING DESIGN • GRAPHIC DESIGN

1000 N. W. 10TH AVE., SUITE 1000, MIAMI, FL 33136

TEL: 305.575.1111

KEITH and SCHNARS, P.A.

ENGINEERS, PLANNERS, SURVEYORS

1000 N. W. 10TH AVE., SUITE 1000, MIAMI, FL 33136

TEL: 305.575.1111



PROJECT NAME

SEMINOLE CASINO COCONUT CREEK PHASE I TRANSPORTATION CENTER & RETAIL PLAZA

SEMINOLE TRIBE OF FLORIDA
COCONUT CREEK, FLORIDA 33073

DRAWN BY EDSA
CHECKED BY
ISSUE DATE February 18, 2011
JOB NUMBER 108075
SHEET NAME LIGHTING PLAN
SHEET NUMBER L-4.02