

LIGHTING SCHEDULE					* - See note below	
Symbol	Qty	Catalog Number	Description	Manufacturer	Lumens	LLF
⊕		LED Yale Series: A610T9LED/6ARC/C45T3 WITH WILMINGTON POLE: FM-18-0"	Main Street Pole Light w/ 18'-0" Mounting Height	Stamberg	na	0.150
⊙		Gardco Designer Spot: D5P1-5T-TRF-116P-42TRF-VOLTAGE-FINISH-C	LANDSCAPE UPLIGHT*	Gardco	na	
⊙		Color Kinetics 1W Blast Powercore: 523-002033-03 W/ DATA ENABLER 506-000001-00	ARCHITECTURAL/FACADE UPLIGHT	Color Kinetics	1111	-
⊙		Bronzelite: 515RG-120	FOUNTAIN LIGHT	Bronzelite	na	-


- NOTE:
1. LIGHT POLE TO MEET MAIN STREET DESIGN STANDARDS. APPROVED LIGHT HAS YET TO BE SELECTED.
 2. VEHICULAR AND PEDESTRIAN AREAS SHALL BE ILLUMINATED TO A MINIMUM OF 10 FOOTCANDLES WITH A MINIMUM/ MAXIMUM NOT TO EXCEED 12:1 PER CITY ORDINANCE.
 3. ALL LANDSCAPE UPLIGHTS TO BE SHIELDED TO PREVENT GLARE.
 4. LIGHT SYMBOLS REPRESENT FIXTURE LOCATIONS FOR LANDSCAPE AND HARDSCAPE COORDINATION. A COMPLETE LIGHTING PACKAGE INCLUDING PHOTOMETRICS FOR SITE LIGHTING WILL BE SUBMITTED TO THE CITY UPON SELECTION OF APPROVED MAIN STREET DESIGN STANDARD FIXTURES. INCLUDED WITHIN THE PACKAGE WILL BE DETAILS FOR EACH INDIVIDUAL FIXTURE SELECTION, POLES, PHOTOMETRICS, AND FINISHES.
 5. PALMS LOCATED PERPENDICULAR TO LIGHT POLE HAVE BEEN SPECIFIED WITH CLEAR WOOD HEIGHTS GREATER THAN THE LIGHT SOURCE. ALL FRONDS WILL BE ABOVE FIXTURE HEADS.

A


B

C

D

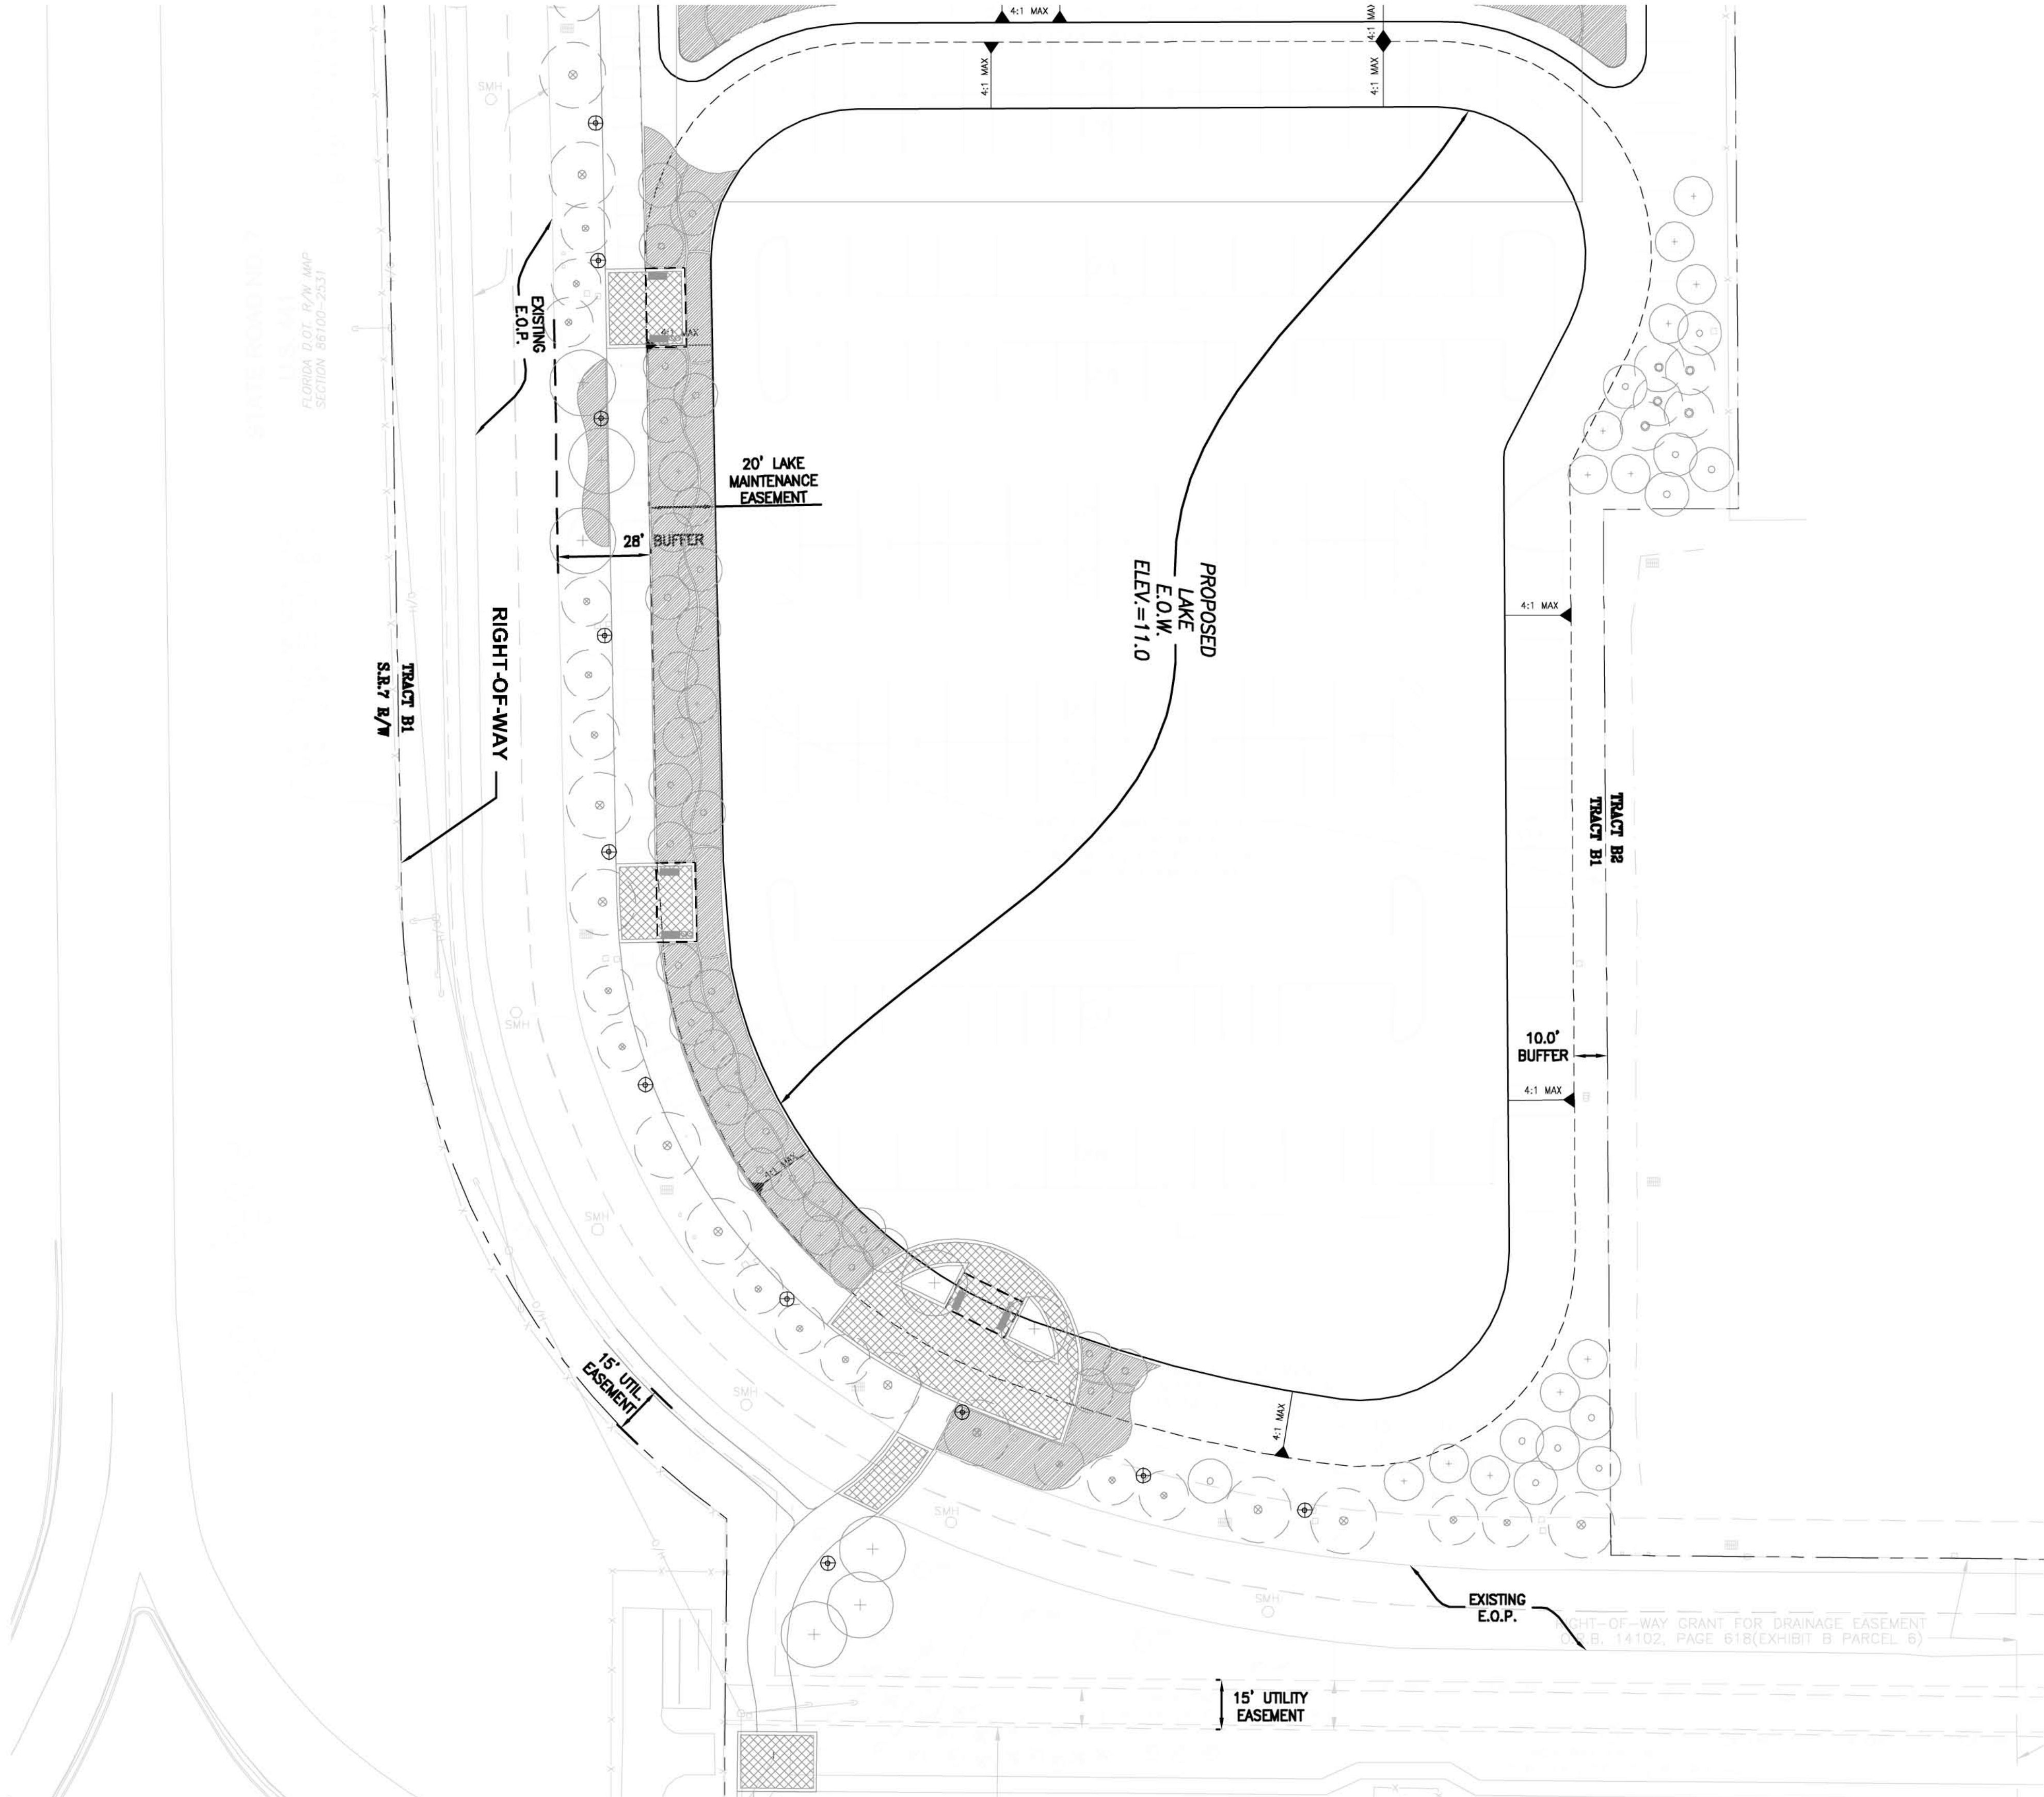

KEY MAP

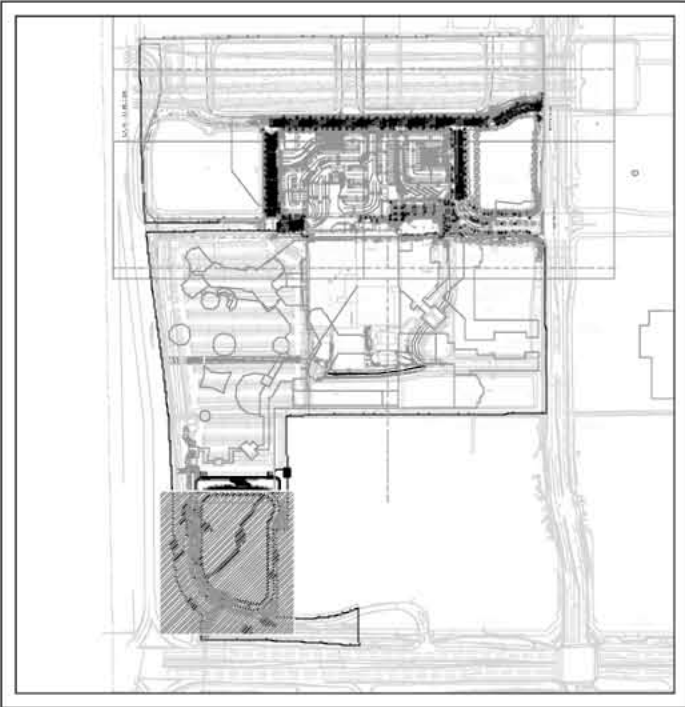

A

B

C

D



Parkway Lighting
Model VILLAGE - LONDON
Manufacturer BEACON

- Options
- LED
 - Sustainability
 - LED
 - Full Cut-off
 - Solar Power

Secondary Street Pole



1"=30'-0"

0 15' 30' 60' 90'

Δ	Date	Description

EDSA

EDSA GROUP

ARCHITECTURAL & DESIGN STUDIOS

ARCHITECTURE, INTERIOR DESIGN, LANDSCAPE ARCHITECTURE, PLANNING, ENGINEERING, ENVIRONMENTAL DESIGN, HISTORIC PRESERVATION, LEED CERTIFICATION, SUSTAINABILITY, WELLNESS DESIGN, VISUALIZATION, VIDEO PRODUCTION

1000 N. W. 10th Ave., Suite 1000
Fort Lauderdale, FL 33304
TEL: 954.564.3333
WWW.EDSAGROUP.COM

Michael Singer Inc.

South Studio - Doral Beach, FL
561-267-3344
michael.singer@gmail.com

KEITH and SCHNARS, P.A.

ENGINEERS, PLANNERS, SURVEYORS

1000 N. W. 10th Ave., Suite 1000
Fort Lauderdale, FL 33304
TEL: 954.564.3333
WWW.EDSAGROUP.COM

KEITH and SCHNARS, P.A.

ENGINEERS, PLANNERS, SURVEYORS

1000 N. W. 10th Ave., Suite 1000
Fort Lauderdale, FL 33304
TEL: 954.564.3333
WWW.EDSAGROUP.COM



PROJECT NAME

SEMINOLE CASINO COCONUT CREEK PHASE I TRANSPORTATION CENTER & RETAIL PLAZA

SEMINOLE TRIBE OF FLORIDA
COCONUT CREEK, FLORIDA 33073

DRAWN BY
EDSA

CHECKED BY

ISSUE DATE
February 18, 2011

JOB NUMBER
108075

SHEET NAME
LIGHTING PLAN

SHEET NUMBER
L-4.03