


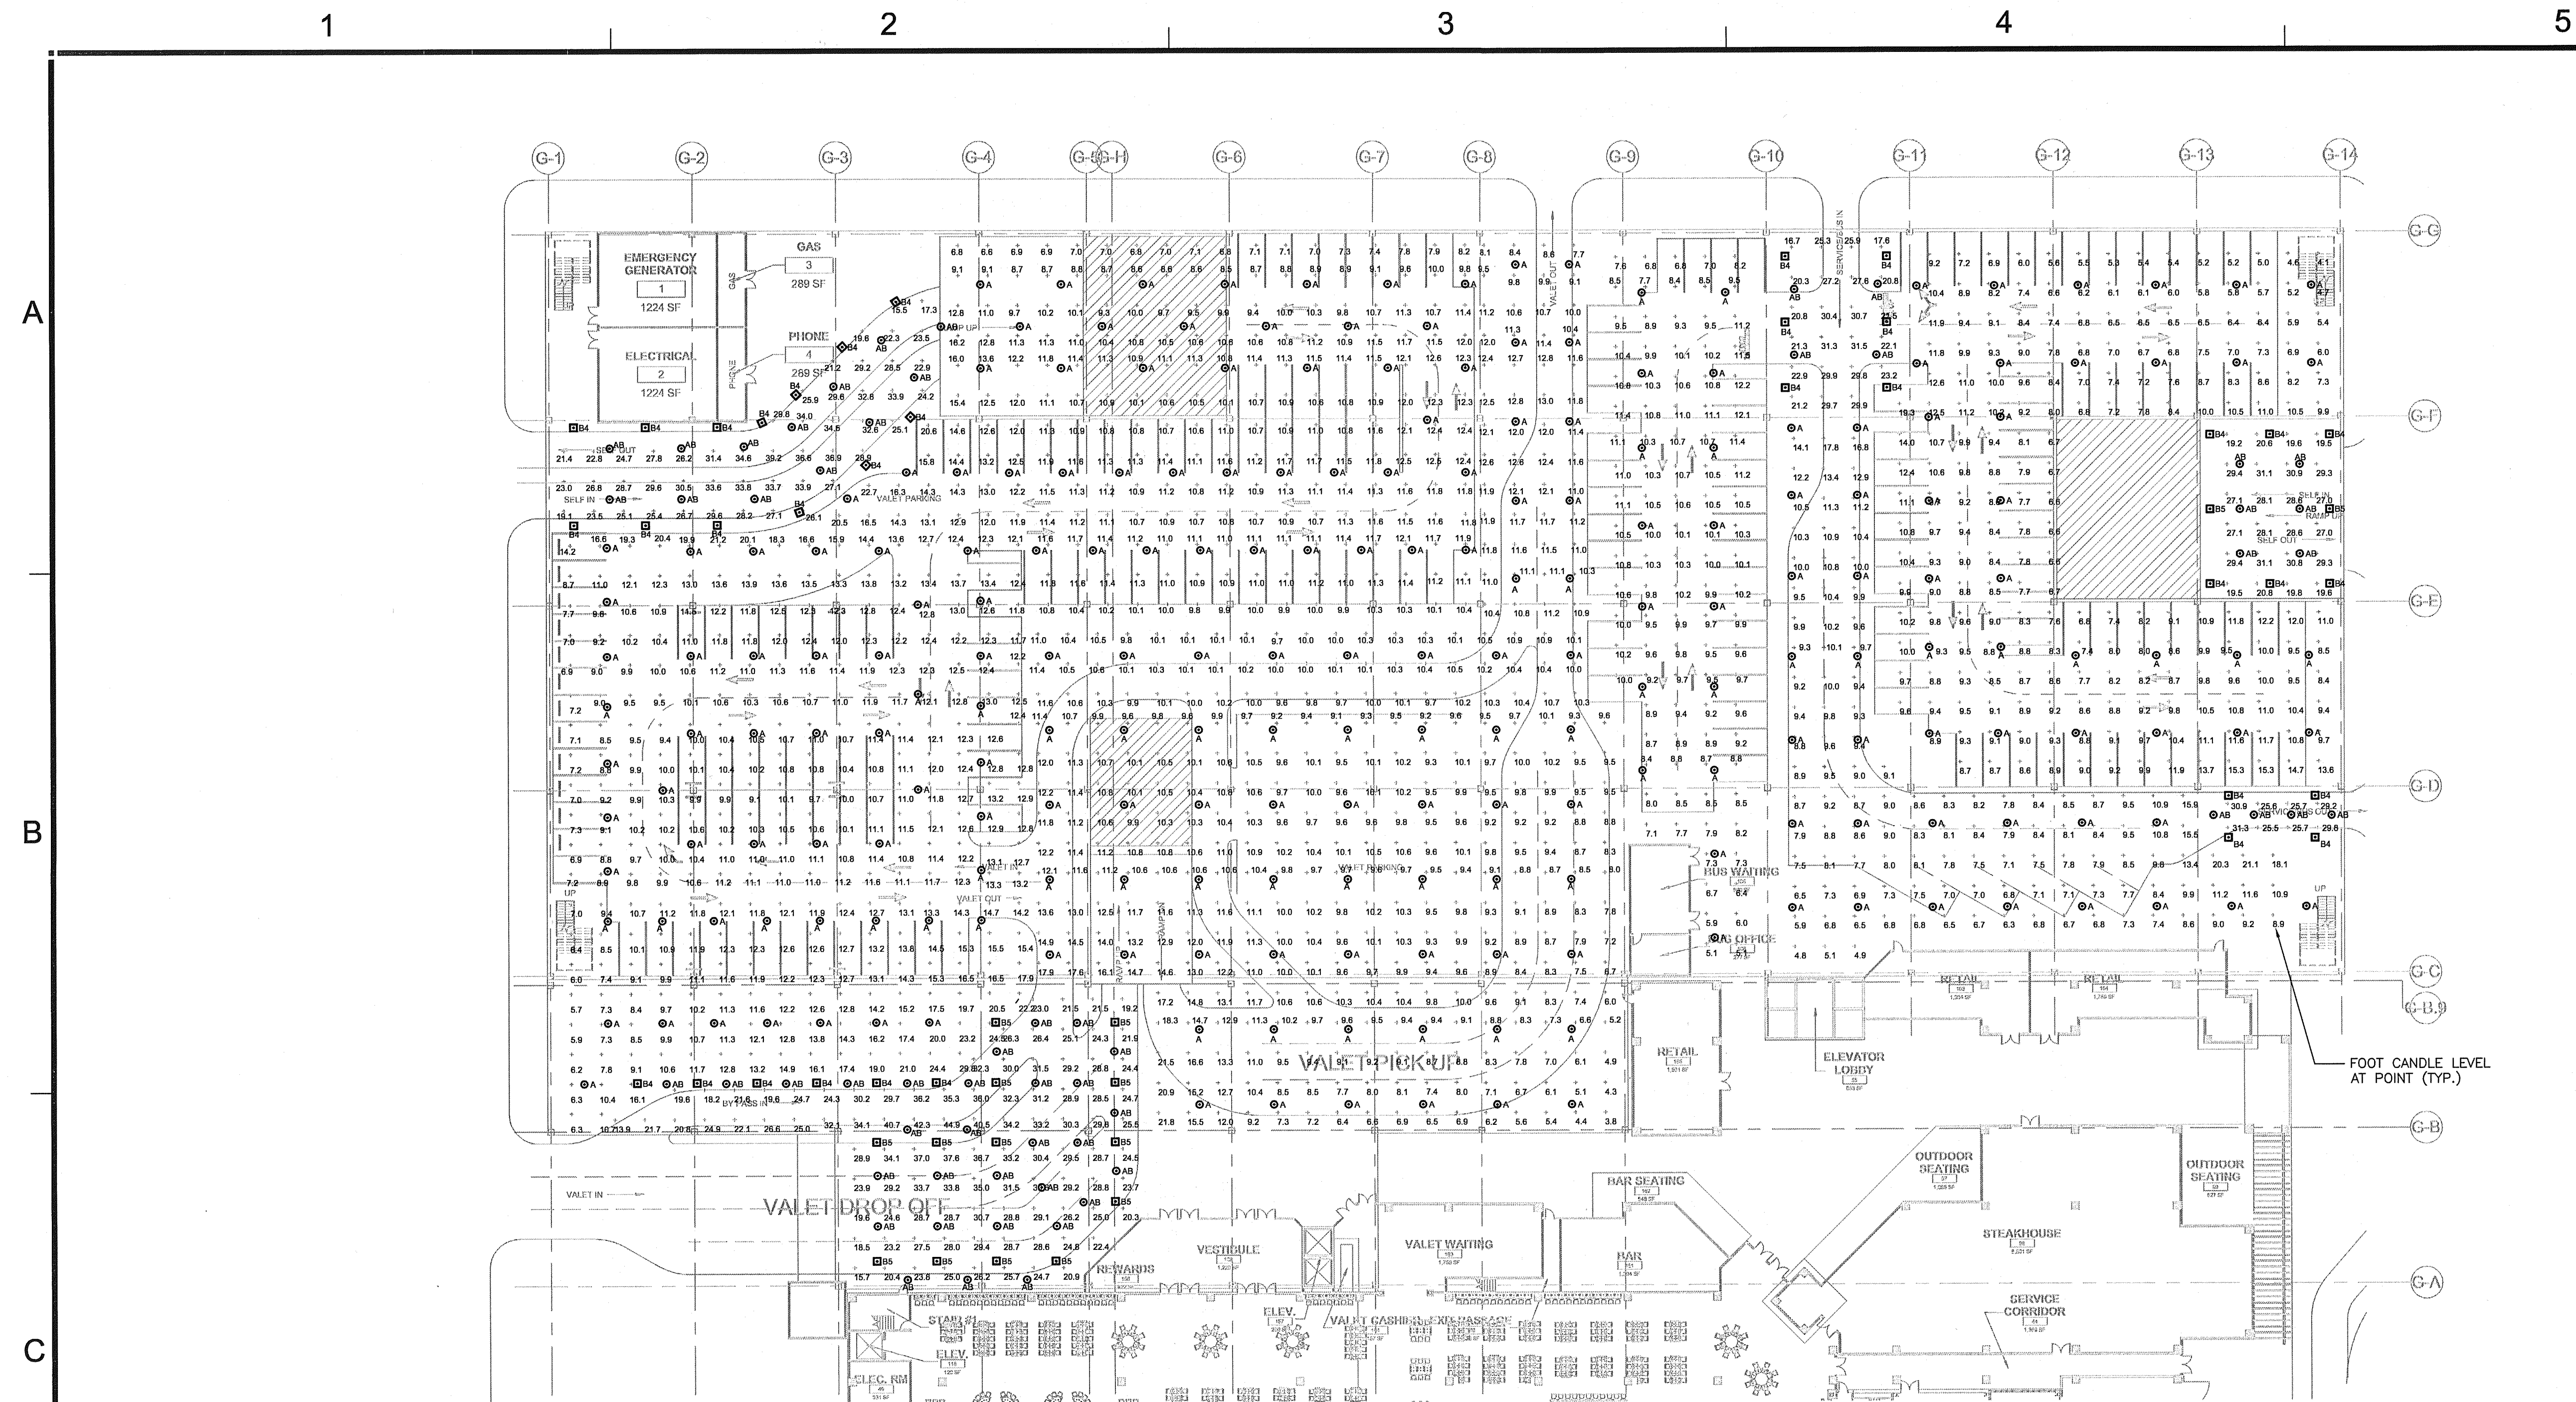

Luminaire Schedule									
Symbol	Qty	Label	Arrangement	Lumens	LLD	LDD	BF	LLF	Description
	225	A	SINGLE	13300	0.800	0.900	0.950	0.684	RSPP-150-S
	57	AB	SINGLE	13300	0.800	0.900	0.950	0.684	RSPP-150-S-BL
	35	B4	SINGLE	25000	0.800	0.900	0.950	0.684	AL3P-250-4H-BL
	15	B5	SINGLE	25000	0.800	0.900	0.950	0.684	AL3P-250-5F-BL

Room Reflection Summary				
Label	Ceiling	Walls	Wall Ht.	Floor
First Floor	30%	20%	17.2	20%

Calculation Summary							
Label	CalcType	Units	Avg	Max	Min	Avg/Min	Max/Min
East Employee Parking	Illuminance	Fc	8.78	19.3	4.1	2.14	4.71
North Exit	Illuminance	Fc	10.26	21.8	3.8	2.70	5.74
NW Entrance-Exit	Illuminance	Fc	27.84	39.2	15.5	1.80	2.53
SE Exit	Illuminance	Fc	27.96	31.3	25.5	1.10	1.23
SE Exit Drive	Illuminance	Fc	9.26	21.1	4.8	1.93	4.40
Service Entrance	Illuminance	Fc	25.11	31.5	16.7	1.50	1.89
SW Entrance-Exit	Illuminance	Fc	27.75	44.9	13.9	2.00	3.23
Valet Parking	Illuminance	Fc	11.57	29.8	5.7	2.03	5.23
West Employee Parking	Illuminance	Fc	9.44	12.2	5.1	1.85	2.39
West Ramp Entrance-Exit	Illuminance	Fc	25.90	31.1	19.2	1.35	1.62

ELECTRICAL FIRST LEVEL LIGHTING PLAN

A	Date	Description
 GIOVANNETTI SHULMAN ASSOCIATES CONSTRUCTIVE ENGINEERING & DESIGNERS 370 REED ROAD, SUITE 201 ROCKFALL, PENNSYLVANIA 15086 (410) 328-7700 FAX (410) 328-7705 CSA Project No. 5707		
1505 E. BROADWAY, SUITE 100 LOS ANGELES, CALIFORNIA 90012 TEL: 562.343.3900 FAX: 562.343.3900 PLANNING • LANDSCAPE ARCHITECTURE • INTERIOR DESIGN • GRAPHIC DESIGN EDSA Michael Singer Inc. South Broom - Dewey Beach, FL (813) 686-1100 michael.singer.com FRIEDMUTTER GROUP ARCHITECTURAL & DESIGN STUDIOS ARCHITECTS 10000 W. 11TH AVENUE, SUITE 100 DENVER, COLORADO 80233 (303) 755-1100 www.friedmutter.com KEITH AND SCHNARS, P.A. ENGINEERS, PLANNERS, SURVEYORS 		
STAMP  M.S. SHULMAN, P.E. FL-LIC. NO. 54272 DATE NOV 18 2010		
PROJECT NAME PHASE I TRANSPORTATION CENTER SEMINOLE TRIBE OF FLORIDA COCONUT CREEK, FLORIDA 33073		
DRAWN BY TMC CHECKED BY DAS ISSUE DATE 8/2/10 JOB NUMBER 2128011 SHEET NAME ELECTRICAL LIGHTING FIRST LEVEL SHEET NUMBER PS-E-1.1		