


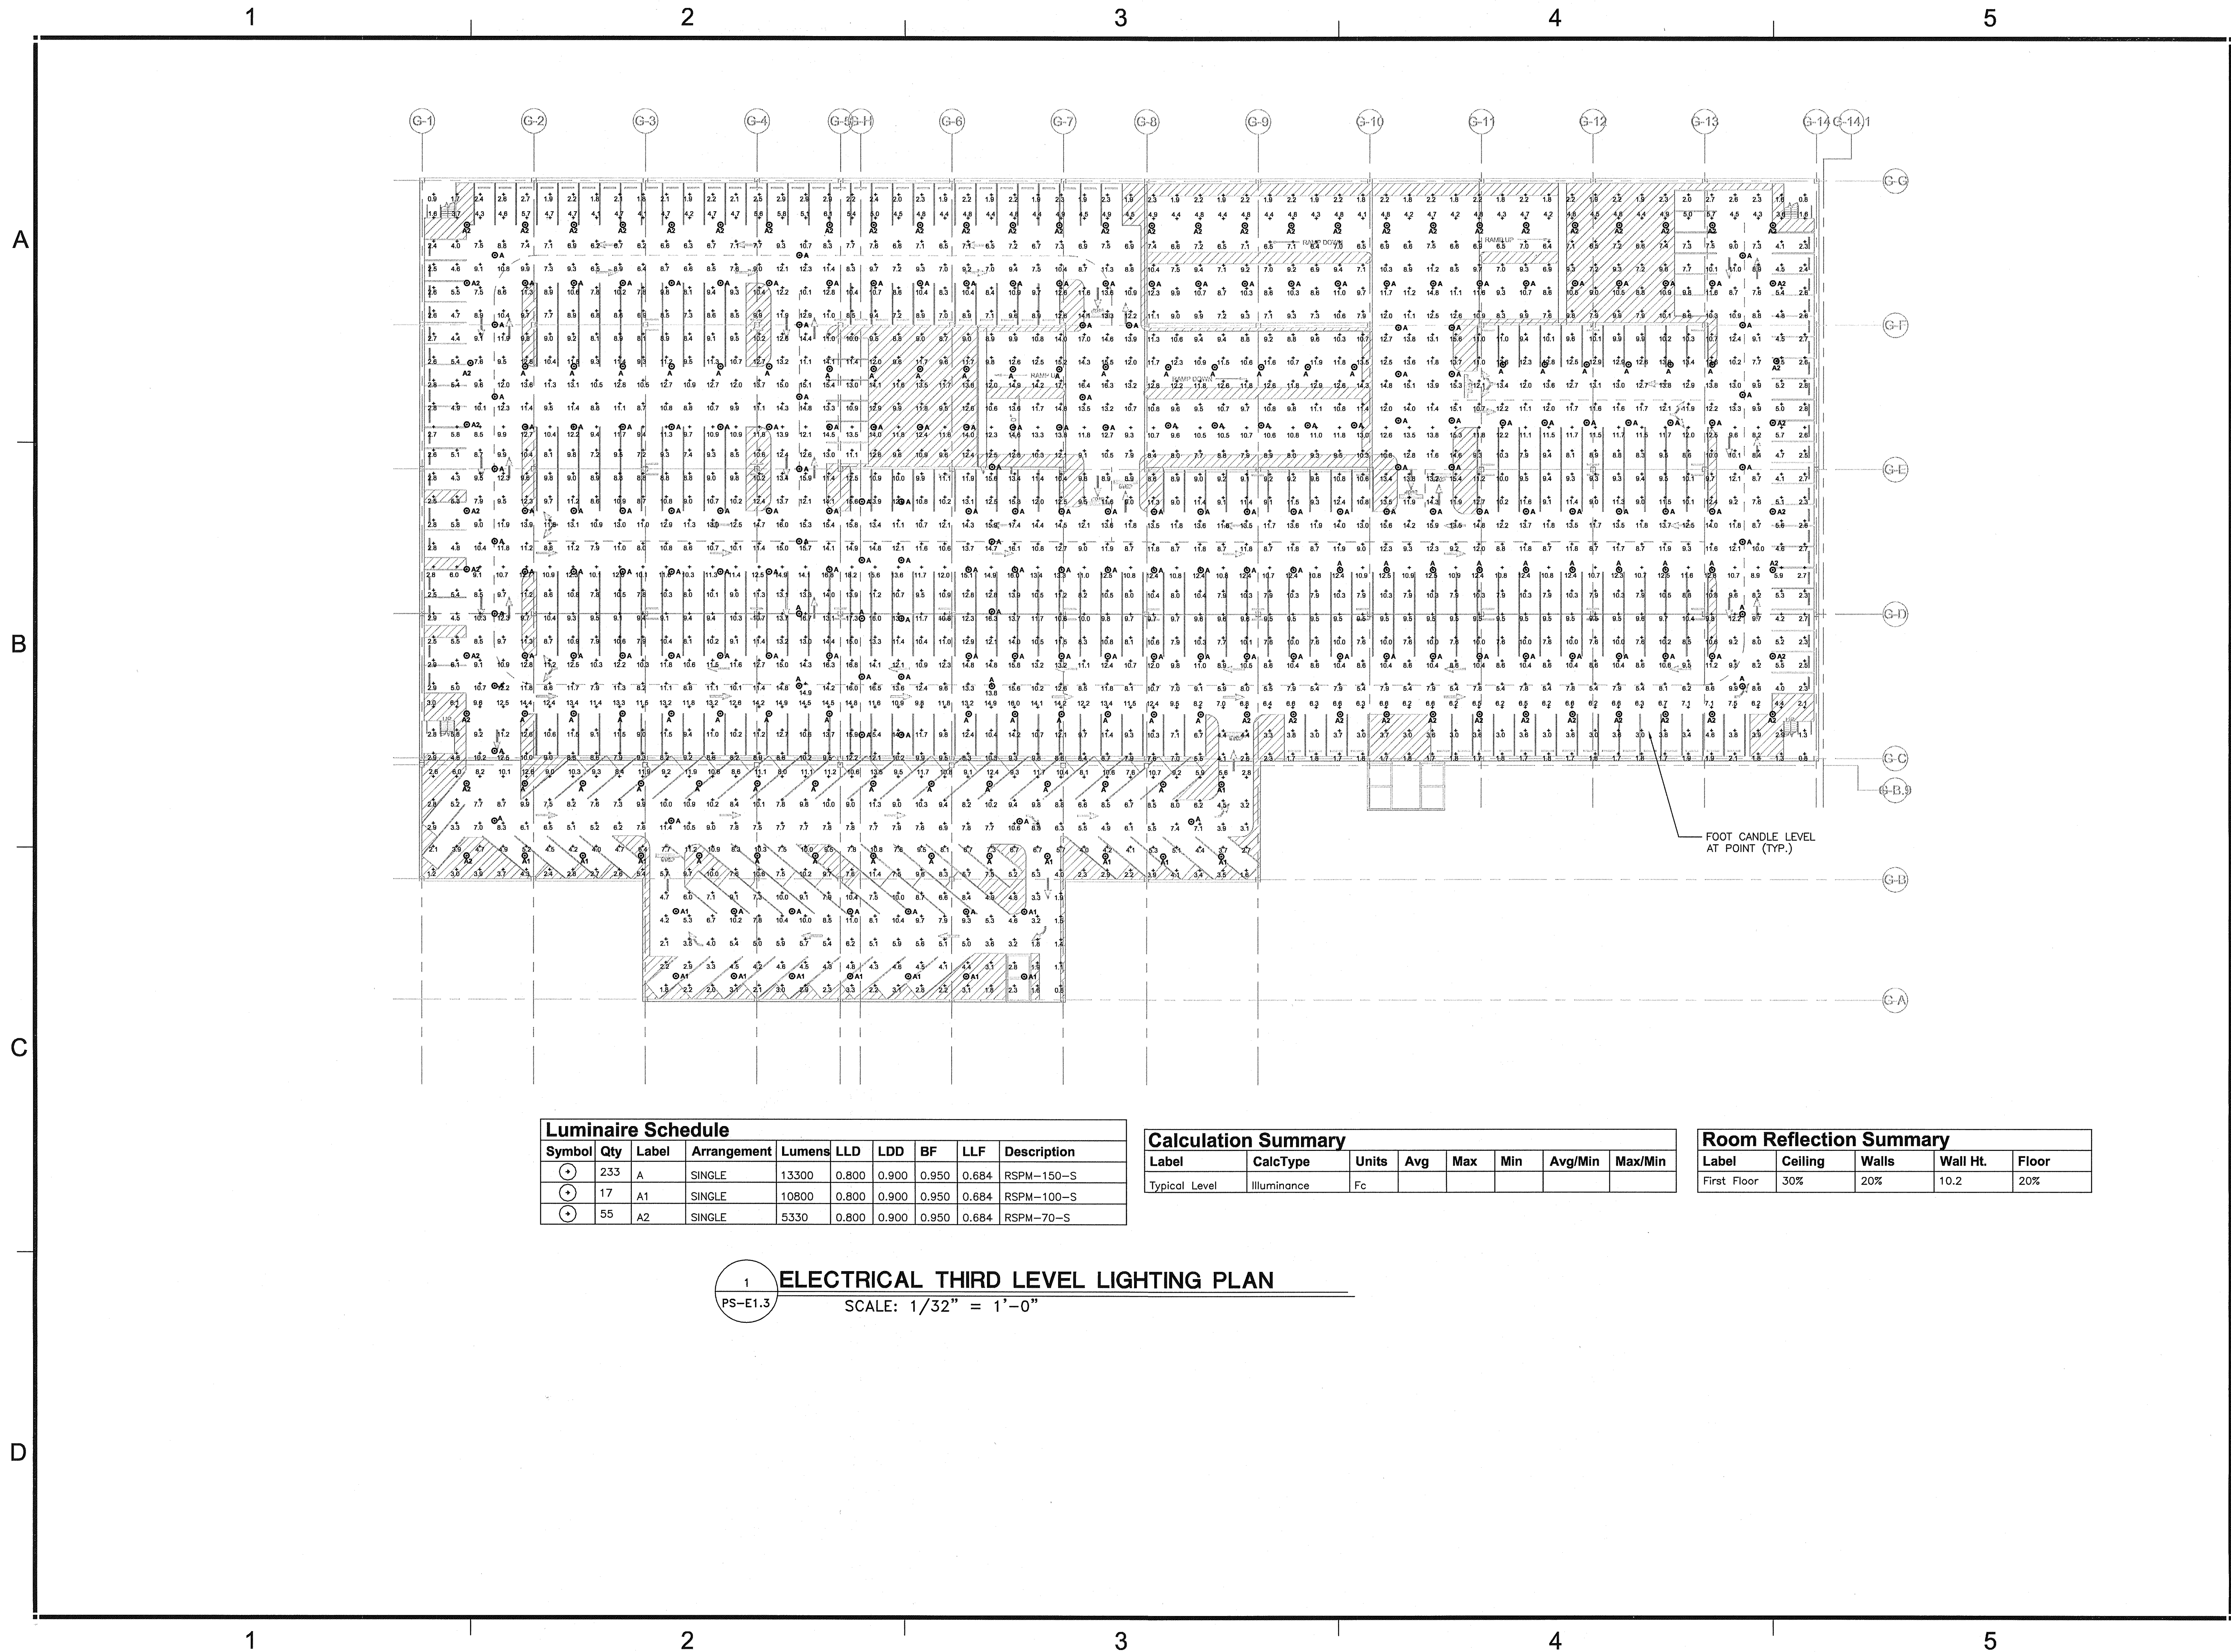

Luminaire Schedule						
Symbol	Qty	Label	Arrangement	Lumens	LLD	Description
⊕	233	A	SINGLE	13300	0.800	RSPM-150-S
⊕	17	A1	SINGLE	10800	0.800	RSPM-100-S
⊕	55	A2	SINGLE	5330	0.800	RSPM-70-S

Calculation Summary							
Label	CalcType	Units	Avg	Max	Min	Avg/Min	Max/Min
Typical Level	Illuminance	Fc					

Room Reflection Summary				
Label	Ceiling	Walls	Wall Ht.	Floor
First Floor	30%	20%	10.2	20%

1 ELECTRICAL THIRD LEVEL LIGHTING PLAN
PS-E1.3 SCALE: 1/32" = 1'-0"

Date

Description

EDSA
ENGINEERING DESIGN & ANALYSIS

Michael Singer Inc.
South Bay - Cary, NC
michael.singer@edsa.com

FRIEDMUTTER GROUP
ARCHITECTURAL DESIGN STUDIOS
ARCHITECTS, INTERIORS, LANDSCAPE ARCHITECTS, PLANNERS, ENGINEERS, SURVEYORS

KEITH and SCHNARS, P.A.
ENGINEERS, PLANNERS, SURVEYORS

STAMP

PROJECT NAME

PHASE I TRANSPORTATION CENTER

SEMINOLE TRIBE OF FLORIDA
COCONUT CREEK, FLORIDA 33073

DRAWN BY
TMC

CHECKED BY
DAS

ISSUE DATE
9/2/10

JOB NUMBER
2128011

SHEET NAME
ELECTRICAL
THIRD LEVEL
LIGHTING PLAN

SHEET NUMBER
PS-E1.3