


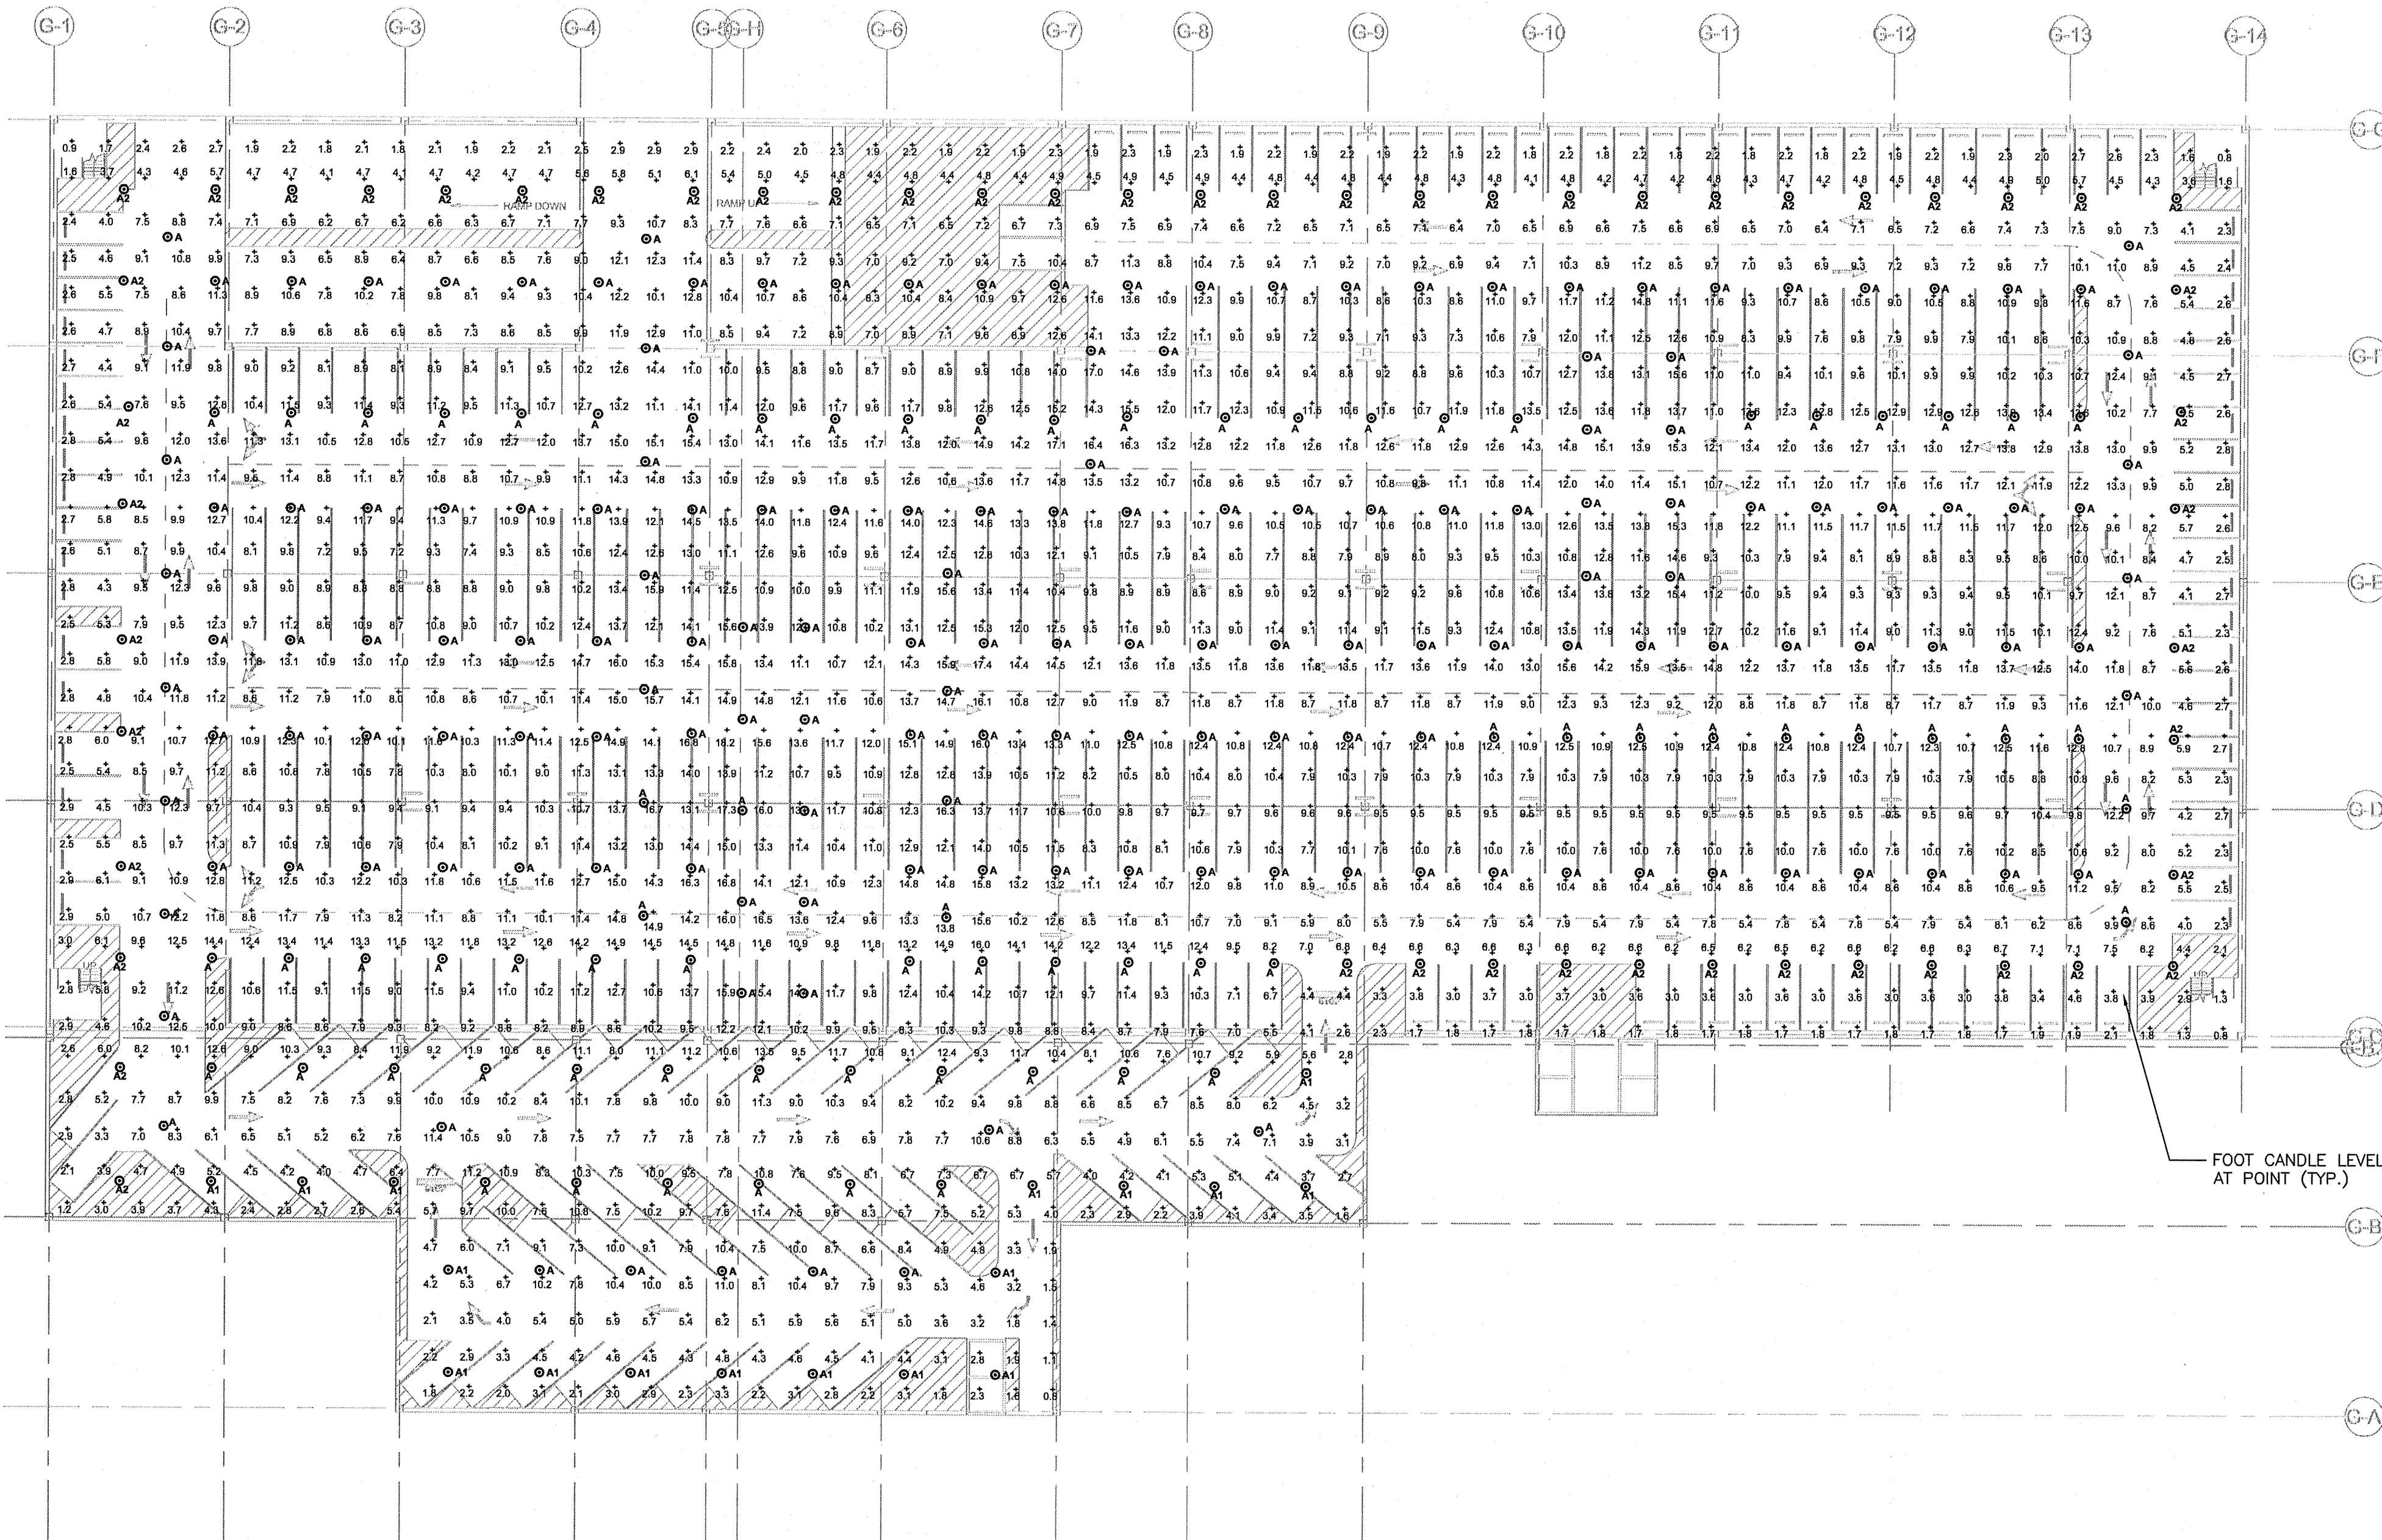

Luminaire Schedule								
Symbol	Qty	Label	Arrangement	Lumens	LLD	LDD	BF	LLF
⊙	233	A	SINGLE	13300	0.800	0.900	0.950	0.684
⊙	17	A1	SINGLE	10800	0.800	0.900	0.950	0.684
⊙	55	A2	SINGLE	5330	0.800	0.900	0.950	0.684

Calculation Summary							
Label	CalcType	Units	Avg	Max	Min	Avg/Min	Max/Min
Typical Level	Illuminance	Fc					

Room Reflection Summary				
Label	Ceiling	Walls	Wall Ht.	Floor
First Floor	30%	20%	10.2	20%

1
PS-E1.6
ELECTRICAL SIXTH LEVEL LIGHTING PLAN
SCALE: 1/32" = 1'-0"

Date

Description

SHULMAN ASSOCIATES
CONSULTING ENGINEERS & DESIGNERS
570 WEST 10TH AVE. SUITE 200
BROOKLYN, PENNSYLVANIA 19008
(610) 338-7700 FAX (610) 338-7705
CSA Project No. 5707

EDSA

EDSA ENGINEERING & DESIGN ASSOCIATES, INC.
1000 N. 10TH AVE. SUITE 100
TAMPA, FL 33604
(813) 241-1111
www.edsa-engineering.com

Michael Singer Inc.

2001 S. Dale Mabry Hwy. Suite 200
Tampa, FL 33629
(813) 241-1111
www.michael-singer.com

KEITH and SCINARS, P.A.

ENGINEERS, PLANNERS, SURVEYORS
1000 N. 10TH AVE. SUITE 100
TAMPA, FL 33604
(813) 241-1111
www.keith-scinars.com

STAMP

W.S. SHULMAN, P.E.
FL. LIC. NO. 54272
DATE NOV 18 2010

PROJECT NAME

PHASE I TRANSPORTATION CENTER

SEMINOLE TRIBE OF FLORIDA
COCONUT CREEK, FLORIDA 33073

DRAWN BY

TMC

CHECKED BY

DAS

ISSUE DATE

9/2/10

JOB NUMBER

212B011

SHEET NAME

ELECTRICAL
SIXTH LEVEL
LIGHTING PLAN

SHEET NUMBER

PS-E1.6