


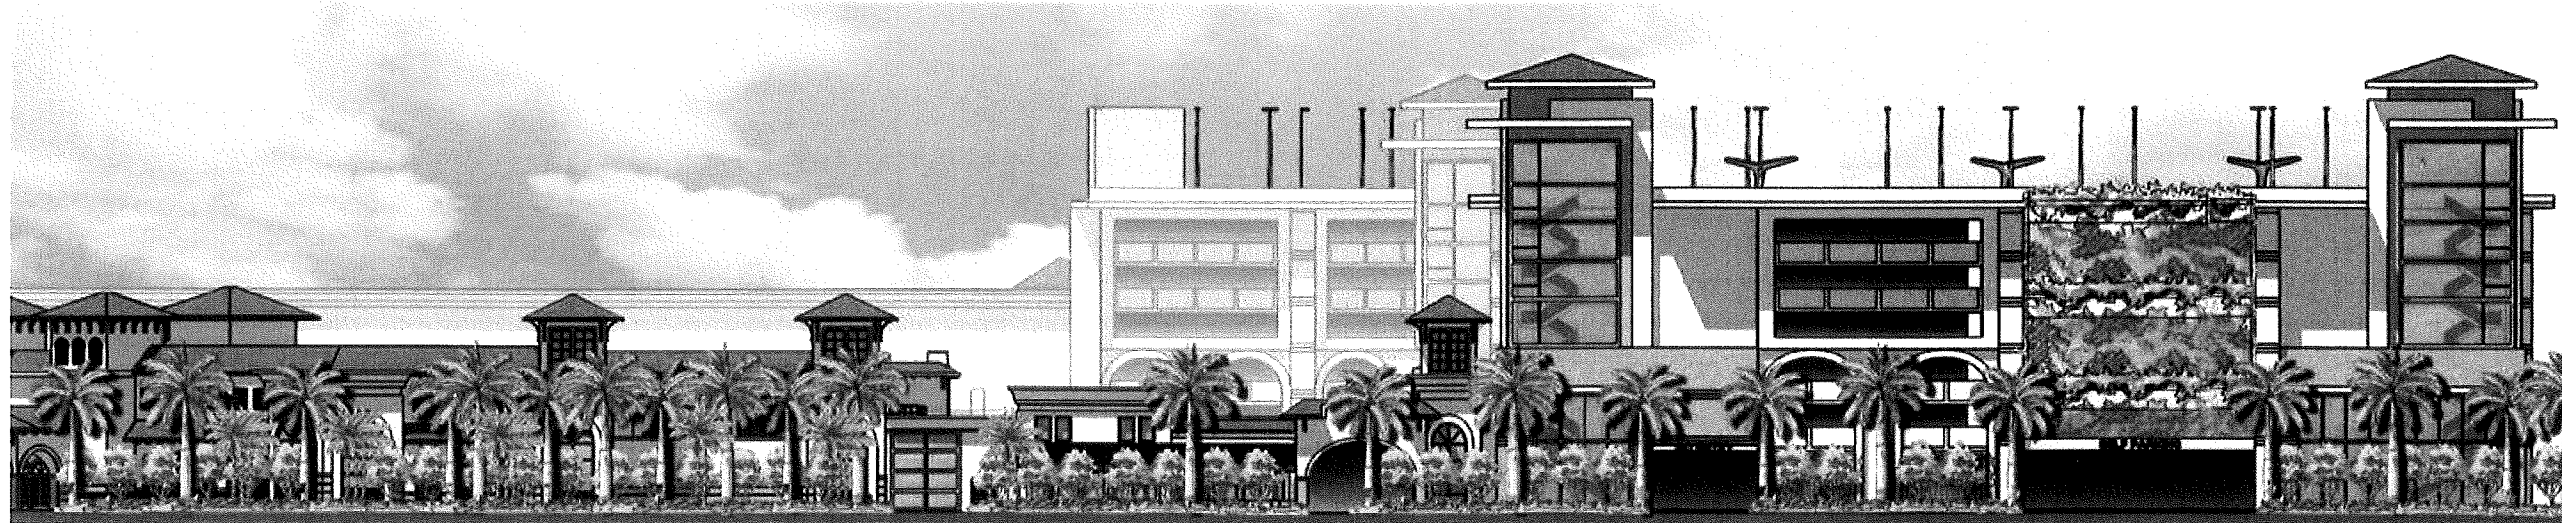

SEMINOLE CASINO COCONUT CREEK PHASE 1 TRANSPORTATION CENTER

CONTACTS

PROJECT ADDRESS SEMINOLE CASINO COCONUT CREEK 5550 NW 40TH STREET COCONUT CREEK, FLORIDA 33073	SIGNAGE KIKU OBATA & COMPANY 6161 DELMAR, SUITE 200 ST. LOUIS, MISSOURI 63112 (314) 361-3110 (314) 361-4716 FAX LAURA MCCANNA
OWNER SEMINOLE TRIBE OF FLORIDA 1 SEMINOLE WAY HOLLYWOOD, FLORIDA 33314 JERRY SHORE (954) 585-5651 (954) 321-5741 FAX	LANDSCAPE ARCHITECT EDSA 1512 E. BROWARD BOULEVARD, SUITE 110 FOR LAUDERDALE, FLORIDA 33301 (954) 524-3330 ROBERT DUGAN
ARCHITECT FRIEDMUTTER GROUP 4022 DEAN MARTIN DRIVE LAS VEGAS, NV 89103 (702) 736-7477 (702) 736-8288 FAX ROBERT DOLLAR	GREEN TECHNOLOGY MICHAEL SINGER STUDIO - SOUTH 321 NW 1ST AVE DELRAY BEACH, FLORIDA 33444 (561) 865-7683 MICHAEL SINGER
CIVIL ENGINEER KEITH and SCHNARS, P.A. 6500 NORTH ANDREWS AVENUE FORT LAUDERDALE, FLORIDA 33309 (954) 776-1616 (954) 351-7643 FAX JIM KAHN TIM HALL	ELECTRICAL ENGINEER GIOVANETTI SHULMAN ASSOCIATES 370 REED ROAD SUITE 201 BROOMALL, PA 19008 (610) 328-7700 TOM MEHAFFEY

SHEET INDEX

A000	COVER SHEET	L-0.01	ELEVATIONS	PS-E1.7	ELECTRICAL SEVENTH LEVEL LIGHTING PLAN
C-1	KEY SHEET	L-0.02	ELEVATIONS	PS-E1.7.1	ELECTRICAL SEVENTH LEVEL ISO FOOT CANDLE CURVE LIGHTING PLAN
C-2	PROJECT LIMITS	L-2.00	TREE SURVEY		
C-3	SITE PLAN	L-2.01	TREE SURVEY	G-1.1	PUBLIC ART AND GREEN TECHNOLOGY ELEMENTS
C-4	SITE PLAN	L-2.02	TREE SURVEY	G-1.3	GARAGE SOLAR PV AND WATER HARVESTING SHADE CANOPY
C-5	SITE PLAN	L-203	TREE SURVEY	G-1.4	TRELLIS SHADE STRUCTURES AND GREEN TECHNOLOGY AND PUBLIC ART SIGNAGE
C-6	SITE PLAN	L-3.01	LANDSCAPE PLAN		
C-7	SITE PLAN	L-3.02	LANDSCAPE PLAN	C-10	PRELIMINARY WATER AND SEWER PLAN
C-8	SITE PLAN	L-3.03	LANDSCAPE PLAN	C-11	PRELIMINARY WATER AND SEWER PLAN
C-9	SITE PLAN	L-3.10	LANDSCAPE NOTES	C-12	PRELIMINARY WATER AND SEWER PLAN
S-1	BOUNDARY SURVEY OF SITE PLAN	L-3.11	LANDSCAPE DETAILS	C-13	PRELIMINARY WATER AND SEWER PLAN
S-2	BOUNDARY SURVEY OF SITE PLAN	L-4.01	LIGHTING PLAN	C-14	PRELIMINARY WATER AND SEWER PLAN
S-3	BOUNDARY SURVEY OF SITE PLAN	L-4.02	LIGHTING PLAN	C-15	PRELIMINARY WATER AND SEWER PLAN
S-4	BOUNDARY SURVEY OF SITE PLAN	L-4.03	LIGHTING PLAN	C-16	PRELIMINARY WATER AND SEWER PLAN
P-1	COMMERCE CENTER OF COCONUT CREEK PLAT	IR-1	SCHEMATIC IRRIGATION PLAN	C-17	PRELIMINARY DRAINAGE PLAN
P-2	COMMERCE CENTER OF COCONUT CREEK PLAT	IR-2	SCHEMATIC IRRIGATION PLAN	C-18	PRELIMINARY DRAINAGE PLAN
P-3	COMMERCE CENTER OF COCONUT CREEK PLAT	IR-3	SCHEMATIC IRRIGATION PLAN	C-19	PRELIMINARY DRAINAGE PLAN
P-4	COMMERCE CENTER OF COCONUT CREEK PLAT	IR-4	SCHEMATIC IRRIGATION PLAN	C-20	PRELIMINARY DRAINAGE PLAN
A101	PARKING GARAGE LEVEL 1 FLOOR PLAN	IR-5	SCHEMATIC IRRIGATION PLAN	C-21	PRELIMINARY DRAINAGE PLAN
A102	PARKING GARAGE LEVEL 2 FLOOR PLAN	IR-6	IRRIGATION DETAILS	C-22	PRELIMINARY DRAINAGE PLAN
A103	PARKING GARAGE LEVEL 3 FLOOR PLAN	IR-7	IRRIGATION NOTES	C-23	PRELIMINARY DRAINAGE PLAN
A104	PARKING GARAGE LEVEL 4 FLOOR PLAN	IR-8	IRRIGATION MATERIALS LIST	C-24	PRELIMINARY DRAINAGE PLAN
A105	PARKING GARAGE LEVEL 5 FLOOR PLAN	PS-E0.0	ELECTRICAL NOTES SCOPE AND LEGEND	C-25	VEHICULAR MOVEMENT PLAN
A106	PARKING GARAGE LEVEL 6 FLOOR PLAN	PS-E1.1	ELECTRICAL GROUND LEVEL LIGHTING PLAN		
A107	PARKING GARAGE LEVEL 7 FLOOR PLAN	PS-E1.2	ELECTRICAL SECOND LEVEL LIGHTING PLAN		
A201	EXTERIOR ELEVATIONS	PS-E1.3	ELECTRICAL THIRD LEVEL LIGHTING PLAN		
A202	EXTERIOR ELEVATIONS	PS-E1.4	ELECTRICAL FOURTH LEVEL LIGHTING PLAN		
		PS-E1.5	ELECTRICAL FIFTH LEVEL LIGHTING PLAN		
		PS-E1.6	ELECTRICAL SIXTH LEVEL LIGHTING PLAN		

BUILDING CODE ANALYSIS

GOVERNING CODE:	2007 FLORIDA BUILDING CODE W/ 2009 SUPPLEMENT 2007 FLORIDA PLUMBING CODE W/ 2009 SUPPLEMENT 2008 NATIONAL ELECTRIC CODE 2007 FLORIDA MECHANICAL CODE W/ 2009 SUPPLEMENT 2007 FLORIDA FIRE PREVENTION CODE W/ 2009 SUPPLEMENT
OCCUPANCY GROUP:	Group S-2
CONSTRUCTION TYPE:	I-B
BUILDING SQ. FOOTAGE:	EACH FLOOR 148,600 SQ. FT.
TOTAL SQ. FT.	TOTAL NUMBER OF FLOORS 7 1,040,200 SQ. FT.
BUILDING HEIGHT:	97'-7"
HIGHEST OCCUPIED FLOOR:	75'-8"

APPROVED
DATE: 7/19/11 BY: [Signature]
ADMINISTRATIVE APPROVAL

#	Date	Description
1	5/23/11	DRC Response to Comments
2	6/15/11	Issued for Administrative Approval

EDSA
FRIEDMUTTER GROUP
ARCHITECTURAL STUDIOS
10000 W. BOULEVARD, SUITE 100
FORT LAUDERDALE, FL 33304
(954) 585-5651
www.friedmutter.com

Michael Singer Inc.
10000 W. BOULEVARD, SUITE 100
FORT LAUDERDALE, FL 33304
(954) 585-5651
www.michaelsinger.com

KEITH and SCHNARS, P.A.
ENGINEERS, PLANNERS, SURVEYORS
10000 W. BOULEVARD, SUITE 100
FORT LAUDERDALE, FL 33304
(954) 585-5651
www.keithandschnars.com



PHASE I TRANSPORTATION CENTER
PARKING GARAGE
SEMINOLE COCONUT CREEK CASINO
SEMINOLE TRIBE OF FLORIDA
5500 NW 40TH STREET
COCONUT CREEK, FLORIDA 33073

DESIGNED BY FRIEDMUTTER GROUP
CHECKED BY [Signature]
ISSUE DATE 08/13/10
JOB NUMBER 2129015
SHEET NAME COVER SHEET
SHEET NUMBER A000