


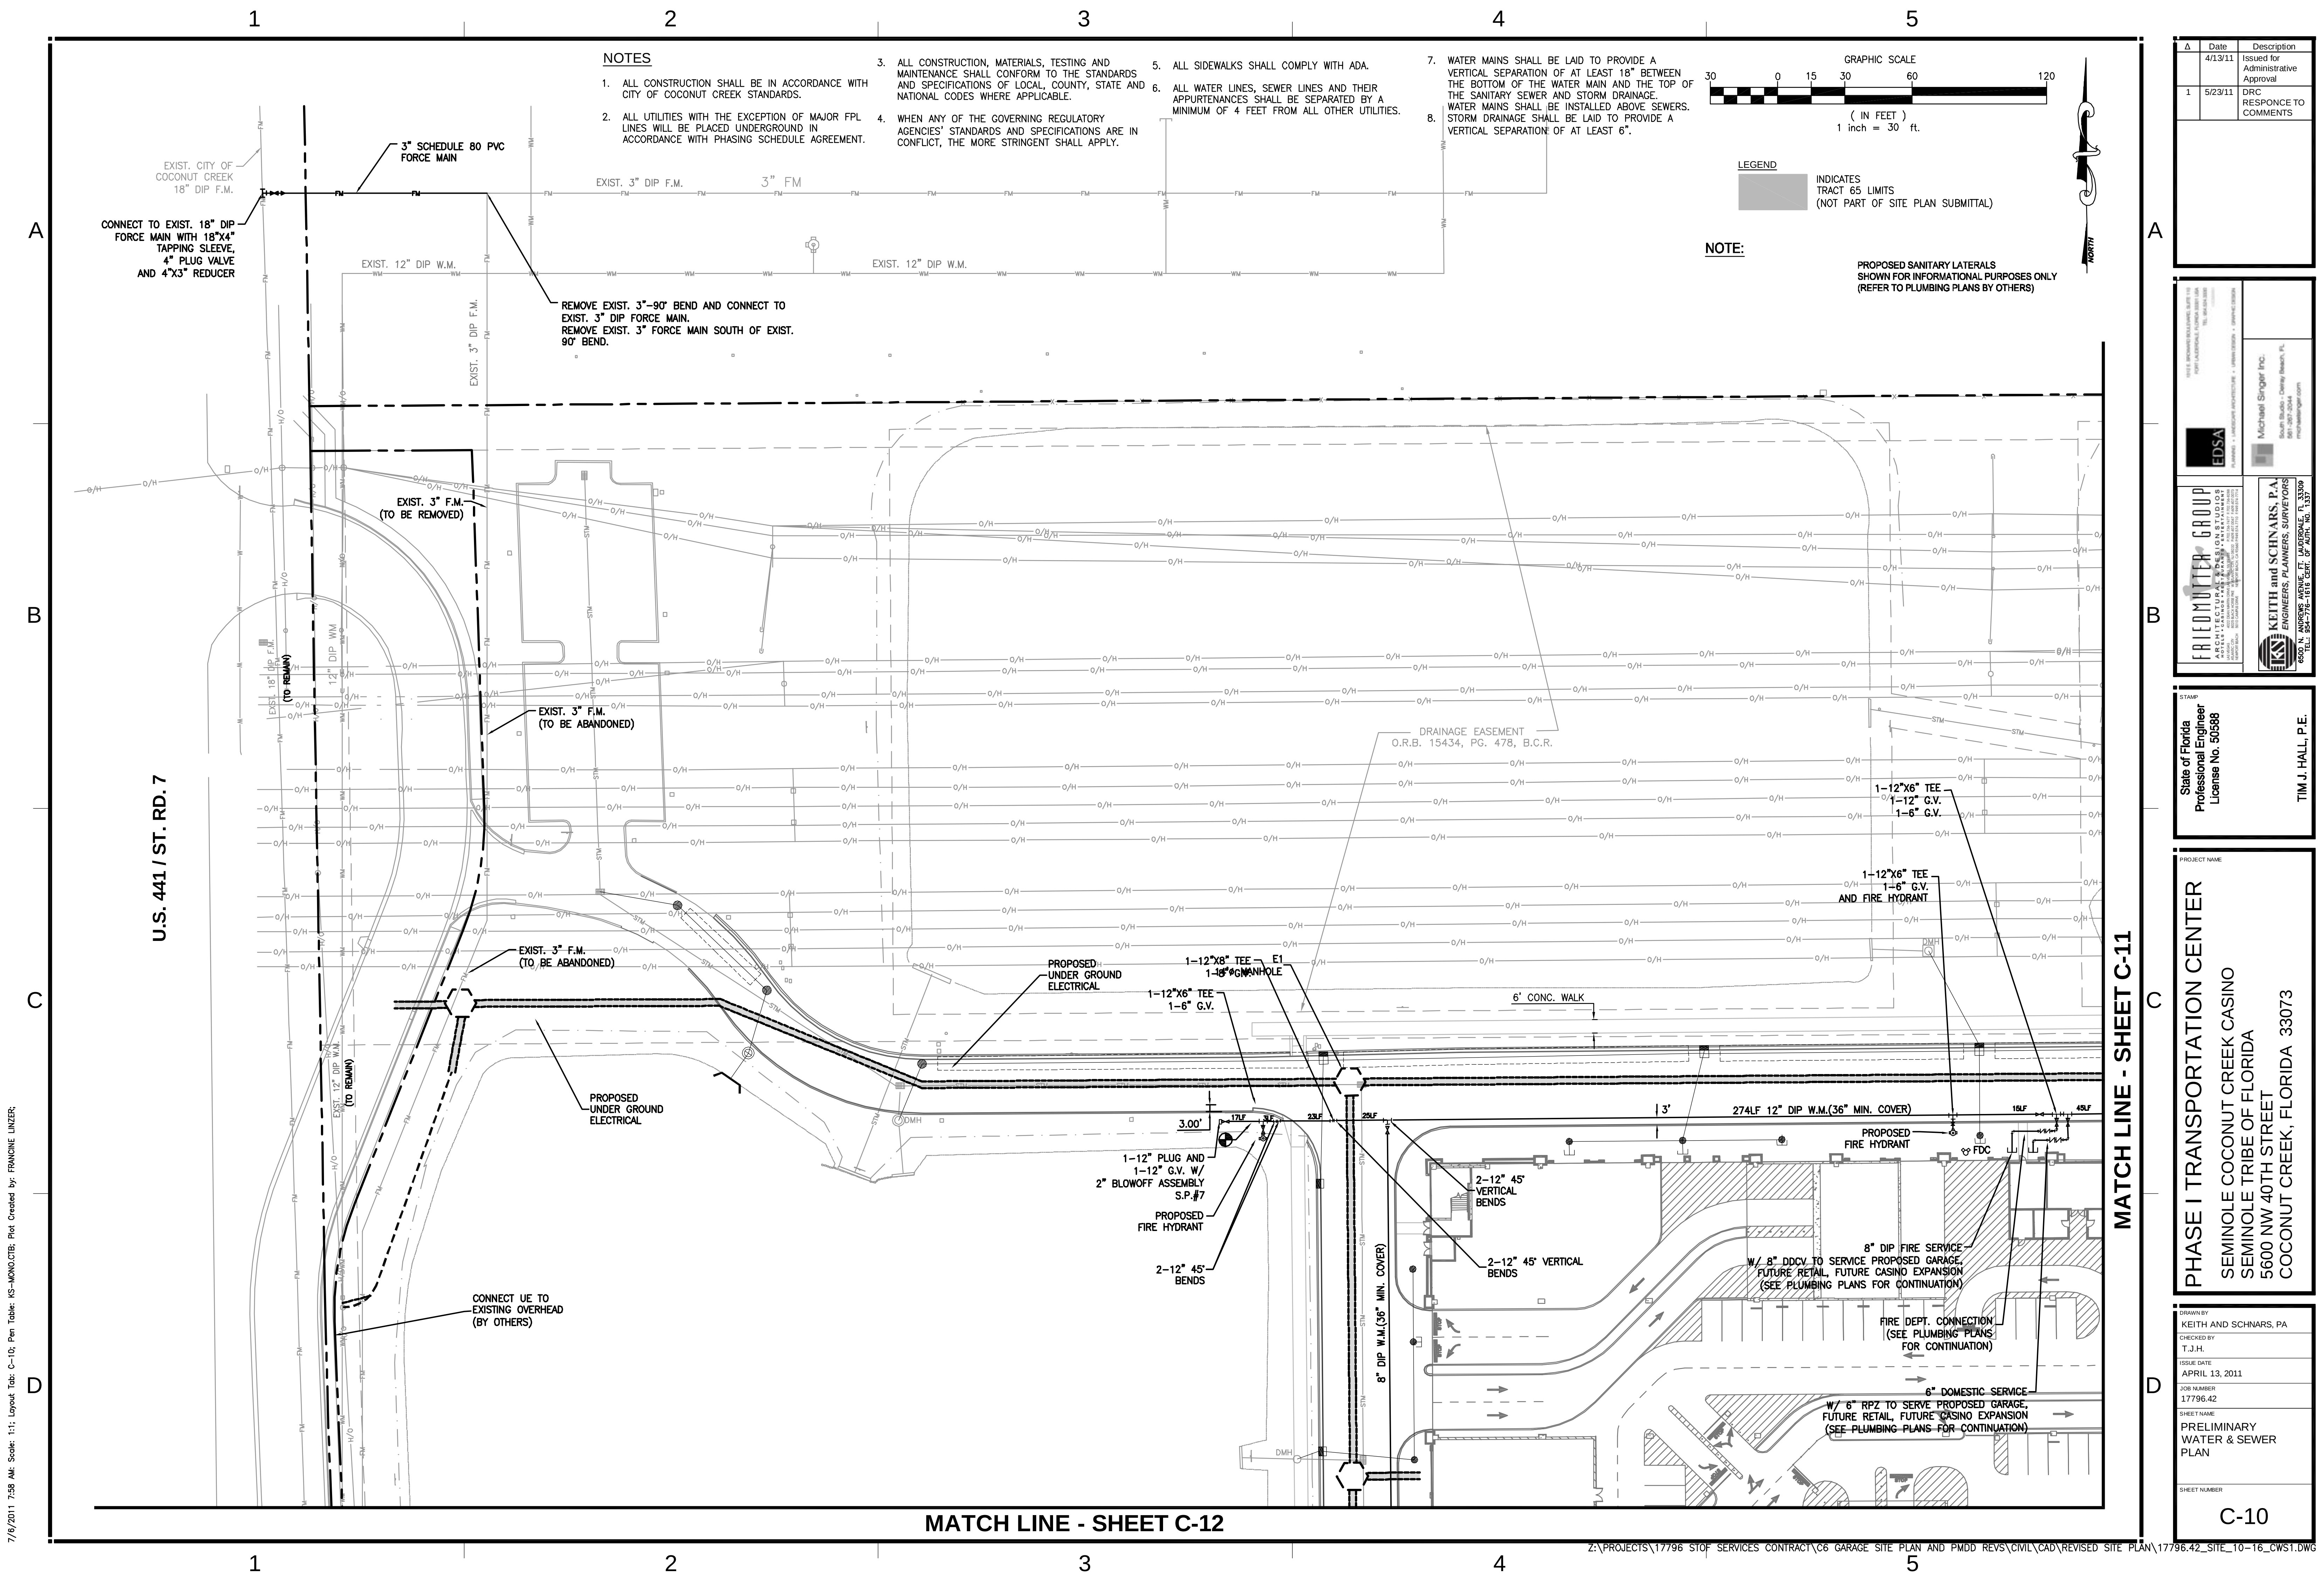

7/6/2011 7:59 AM: Scale: 1:1; Layout Tab: C-10; Pen Table: MS-MONO.DTB; Plot Created by: FRANCHIE LINZER;

Z:\PROJECTS\17796 STOP SERVICES CONTRACT\06 GARAGE SITE PLAN AND PMDD REVS\Civil\CAD\REVISED SITE PLAN\17796.42_Site_10-16_CWS1.DWG

Δ	Date	Description
	4/13/11	Issued for Administrative Approval
1	5/23/11	DRC RESPONSE TO COMMENTS

EDSA
ENGINEERING DESIGN & SURVEYING, INC.
11111 BROWNSVILLE BLVD. SUITE 110
FORT LAUDERDALE, FL 33304
TEL: 954-333-3333
WWW.EDSA-FL.COM

Michael Singer Inc.
South Bldg. - Denver, North, FL
981-387-3044
msinger@msi.com

FRIEDMUTTER GROUP
ARCHITECTURAL DESIGN STUDIOS
ARCHITECTS, INTERIORS, LANDSCAPE ARCHITECTS
1000 N. W. 10TH AVE., SUITE 1000
FORT LAUDERDALE, FL 33304
TEL: 954-333-3333
WWW.FRIEDMUTTERGROUP.COM

KEITH and SCHNARS, P.A.
ENGINEERS, PLANNERS, SURVEYORS
600 N. AUSTIN AVE., SUITE 100
FORT LAUDERDALE, FL 33309
TEL: 954-333-3333
WWW.KS-FL.COM

STAMP
State of Florida
Professional Engineer
License No. 50588

TIM J. HALL, P.E.

PROJECT NAME
PHASE I TRANSPORTATION CENTER
SEMINOLE COCONUT CREEK CASINO
SEMINOLE TRIBE OF FLORIDA
5600 NW 40TH STREET
COCONUT CREEK, FLORIDA 33073

DRAWN BY
KEITH AND SCHNARS, PA

CHECKED BY
T.J.H.

ISSUE DATE
APRIL 13, 2011

JOB NUMBER
17796.42

SHEET NAME
PRELIMINARY
WATER & SEWER
PLAN

SHEET NUMBER

C-10

Z:\PROJECTS\17796 STOP SERVICES CONTRACT\06 GARAGE SITE PLAN AND PMDD REVS\Civil\CAD\REVISED SITE PLAN\17796.42_Site_10-16_CWS1.DWG