


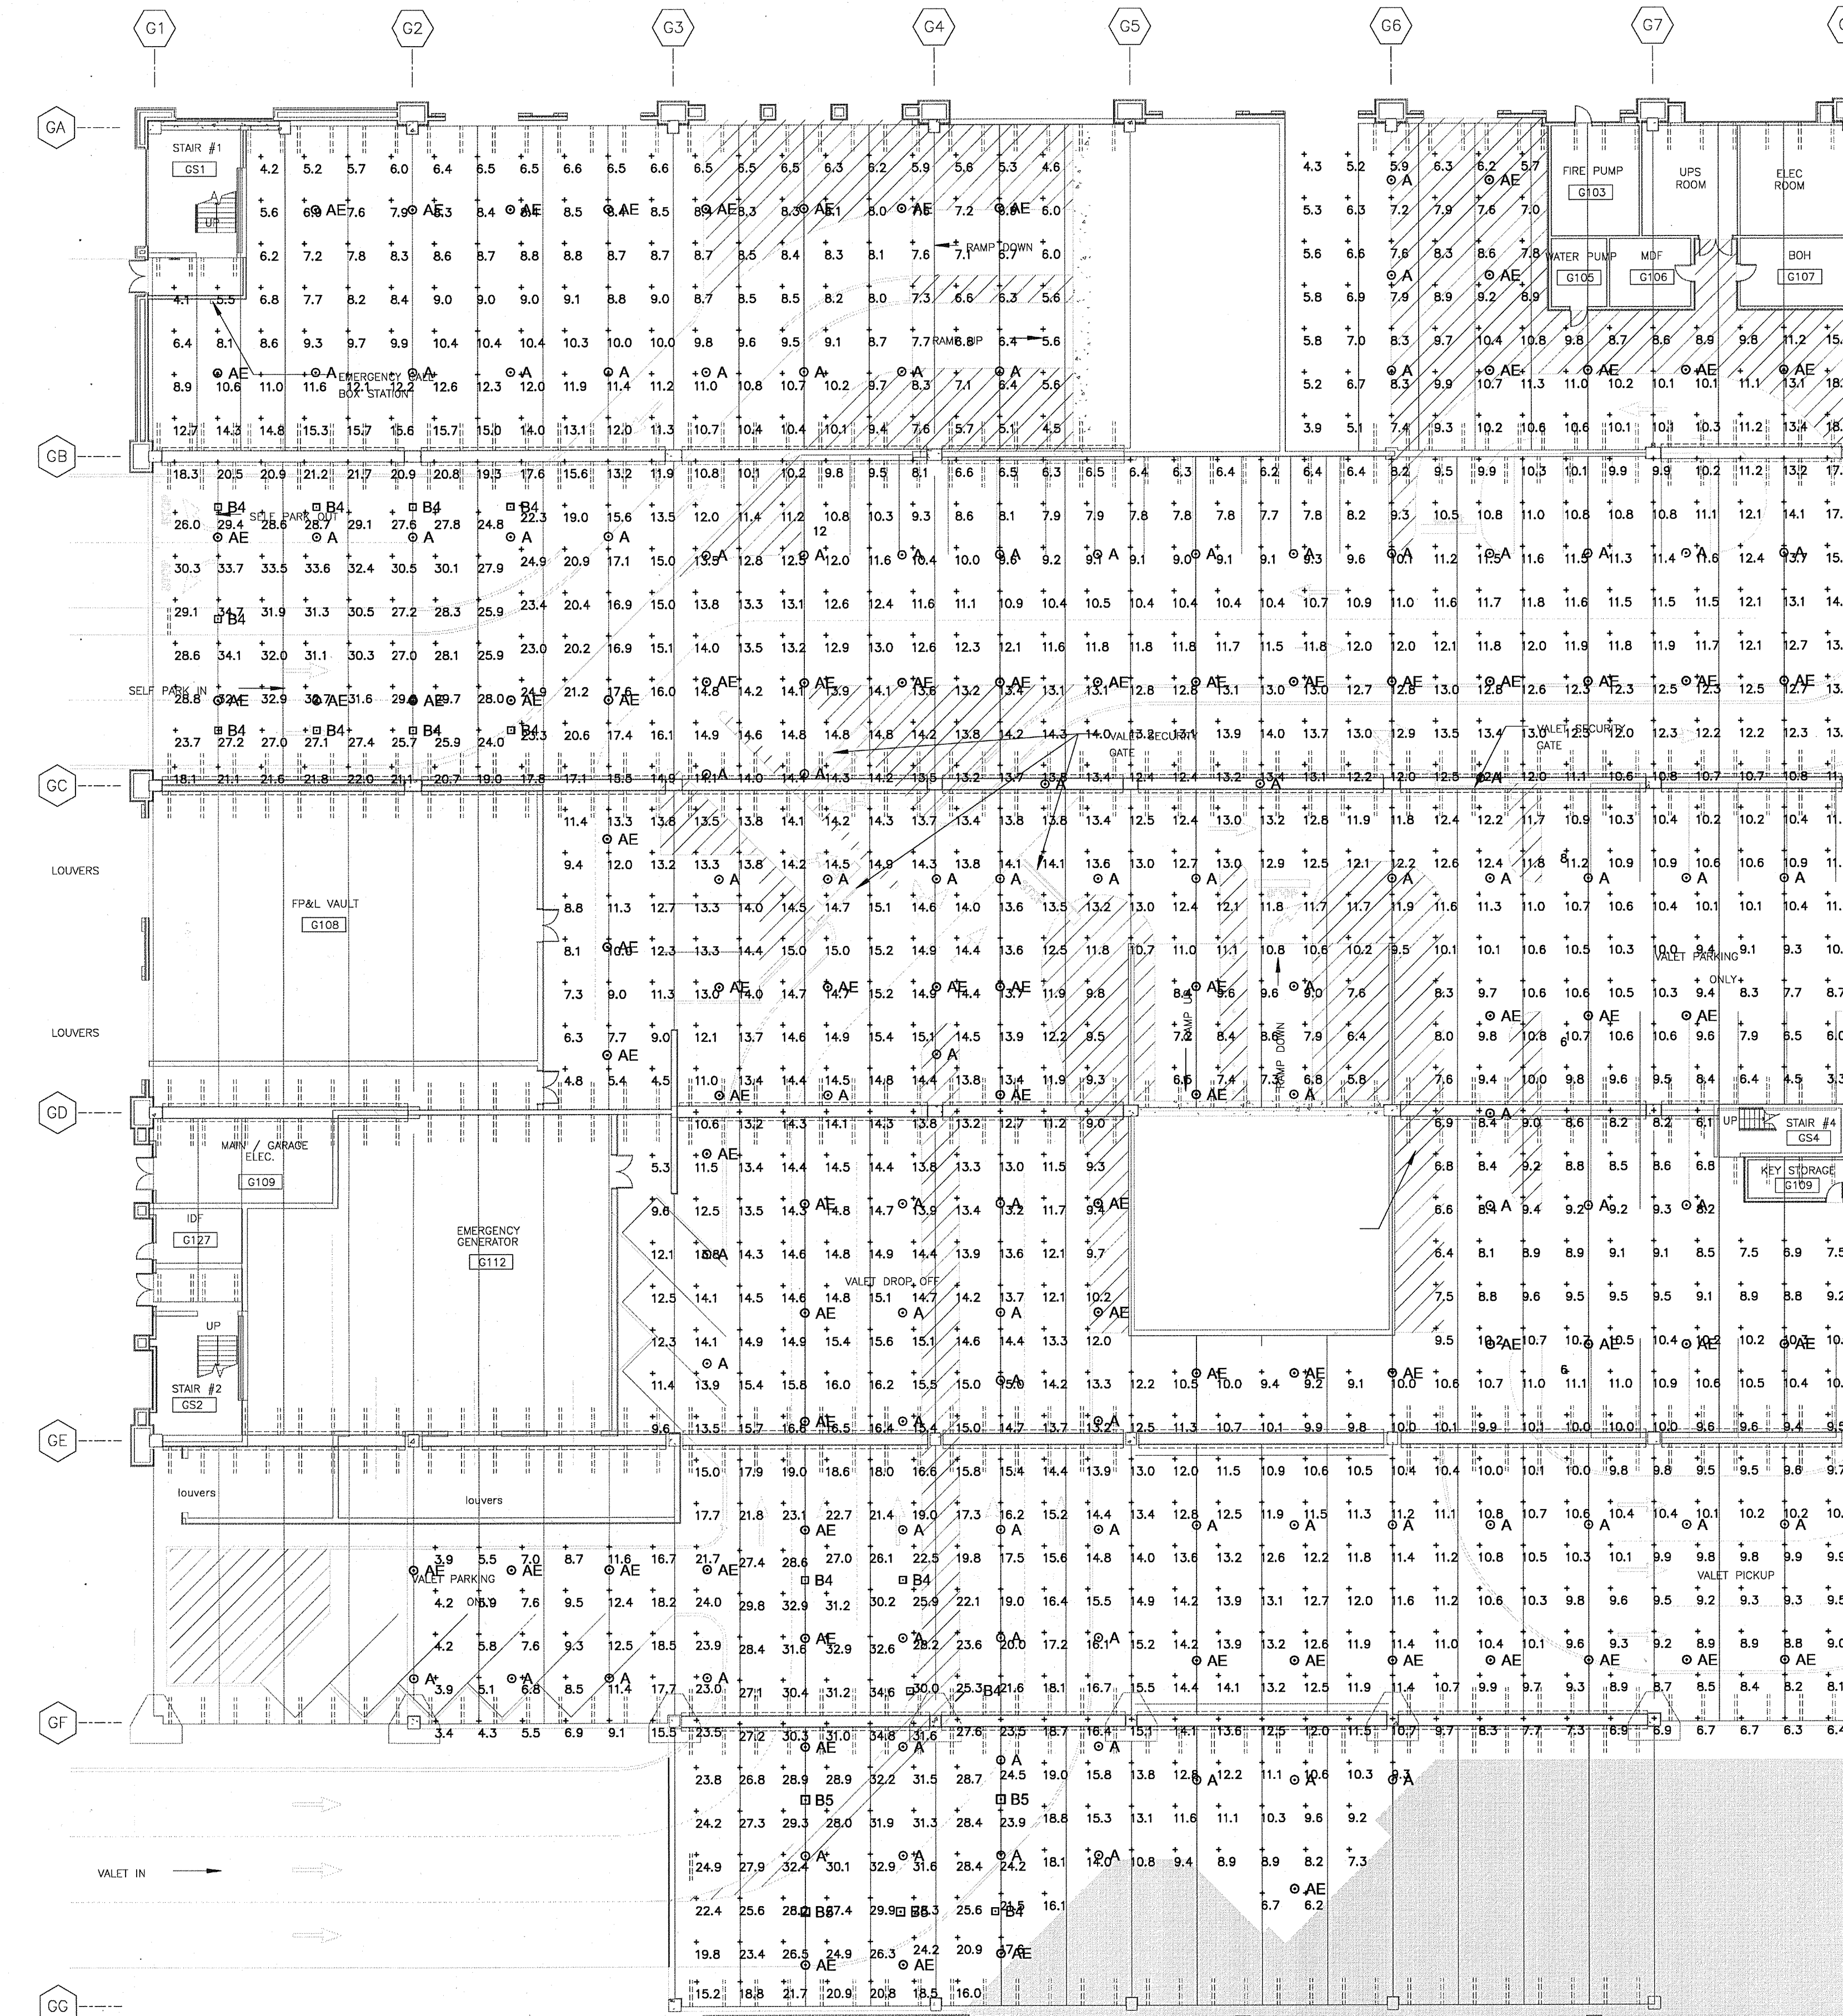

Luminaire Schedule							
Symbol	Qty	Label	Arrangement	Lumens	LLD	LDD	BF
129	A	SINGLE		13300	0.800	0.900	0.950
128	AE	SINGLE		13300	0.800	0.900	0.950
24	B4	SINGLE		25000	0.800	0.900	0.950
22	B5	SINGLE		25000	0.800	0.900	0.950

Room Reflection Summary				
Label	Ceiling	Walls	Wall Ht.	Floor
EAST ENT	30%	20%	18	20%
LEVEL 1	30%	20%	18	20%

Calculation Summary						
Label	CalcType	Units	Avg	Max	Min	Avg/Min
ENTRANCE 1	IREM	W/m²	29.24	34.7	23.7	1.23
ENTRANCE 2	IREM	W/m²	30.26	32.1	28.0	1.08
ENTRANCE 3	IREM	W/m²	30.39	37.8	21.1	1.44
ENTRANCE 4	IREM	W/m²	27.39	35.4	18.0	1.52
ENTRANCE 5	IREM	W/m²	31.19	35.2	22.5	1.39
ENTRANCE 6	IREM	W/m²	28.67	34.8	19.8	1.45
LEVEL 1 - FBM	IREM	W/m²	11.93	31.3	2.7	4.42

PARTIAL FLOOR PLAN LEVEL 1 - PHOTOMETRIC
1/8" = 1'-0"

DATE: 04-18-11
DESCRIPTION: ISSUED FOR PERMIT

FRIEDMUTTER GROUP

ARCHITECTURE / INTERIOR DESIGN / BRANDING STUDIOS

SPECIALIZING IN MULTI-USE PROJECTS

HOTELS-CASINOS-RESTAURANTS-ENTERTAINMENT-HIGH-RISE RESIDENTIAL

REPRESENTING: SEMINOLE TRIBE OF FLORIDA

1000 N. MIAMI AVENUE, SUITE 1000, MIAMI, FL 33136

TEL: 305.575.1100 FAX: 305.575.1101 WWW.FMG.COM

CONSULTANT: GSA PROJ. No. 5708

PHASE I TRANSPORTATION CENTER

SEMINOLE COCONUT CREEK CASINO

SEMINOLE TRIBE OF FLORIDA

6000 NW 40TH STREET

COCONUT CREEK, FLORIDA 33073

DESIGNED BY: BK

CHECKED BY: DAS

ISSUE DATE: 04-18-11

PROJECT NUMBER: 2120015

SHEET NAME: PARTIAL FLOOR PLAN LEVEL 1 - PHOTOMETRIC

SHEET NUMBER: EG501

File: P:\Projects\Coconut Creek\Phase I Transportation Center\Level 1 - Photometric.dwg
User: DAS
Date: 04/18/11
Time: 10:00 AM
Plot: 04/18/11 10:00 AM
Printer: HP DesignJet T1100e
Scale: 1/8" = 1'-0"