


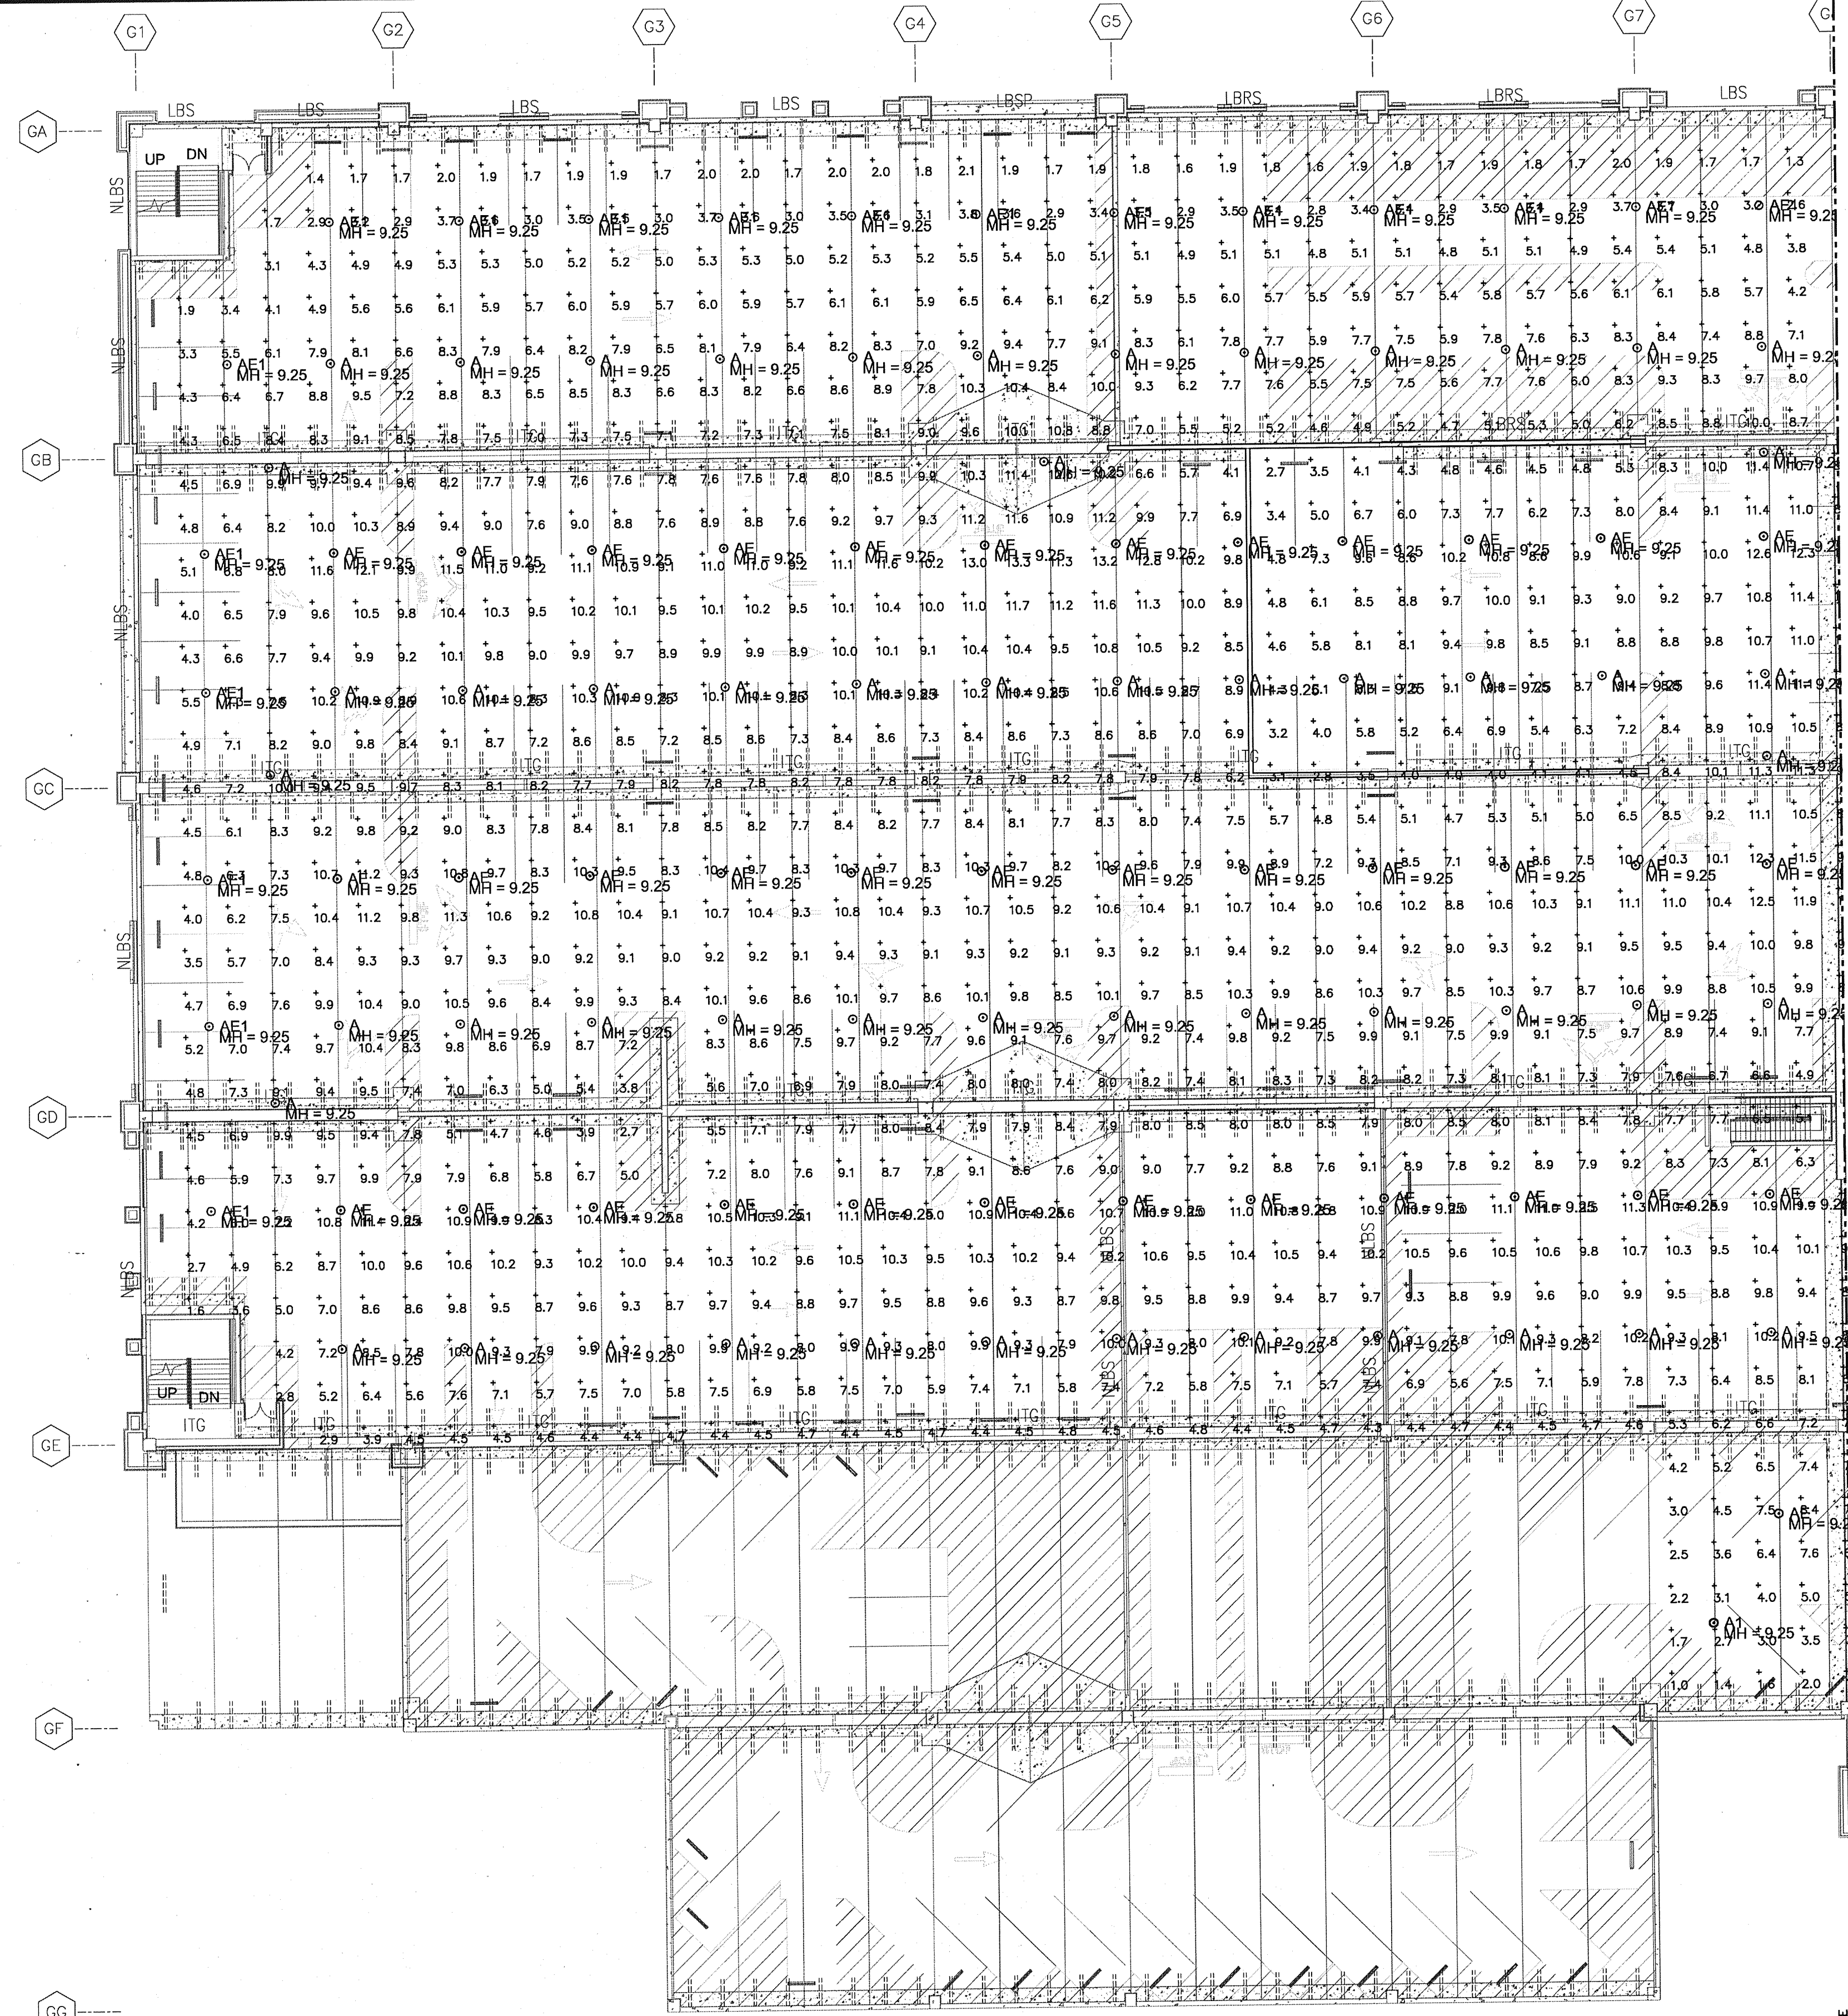

Luminaire Schedule							
Symbol	Qty	Label	Arrangement	Lumens	LLD	LDD	RF
⊙	81	A	SINGLE	13300	0.800	0.900	0.684
⊙	70	AE	SINGLE	13300	0.800	0.900	0.684
⊙	14	A1	SINGLE	5300	0.600	0.900	0.513
⊙	36	AE1	SINGLE	5300	0.600	0.900	0.513

Calculation Summary							
Label	CalcType	Units	Avg	Max	Min	Avg/Min	Max/Min
Room_Floor	Illuminance	Fc	6.74	13.2	1.1	6.13	12.00

Room Reflection Summary				
Label	Ceiling	Walls	Wall Ht.	Floor
Room	30%	20%	11.75	20%

PARTIAL FLOOR PLAN LEVEL 2 - PHOTOMETRIC
1/16" = 1'-0"

A	Description
04-18-11	ISSUED FOR PERMIT

RIED MUTTER GROUP
ARCHITECT/INTERIOR DESIGN/BRANDING STUDIOS
1000 N. MIAMI AVENUE, SUITE 1000
MIAMI, FL 33136
TEL: 305.577.7200 FAX: 305.577.7201
WWW.RMG.COM

STATE OF FLORIDA
Professional Engineer
J.S. SHULMAN, P.E.
FL LIC. NO. 54272
DATE: JUL 05 2011

CONSULTANT

GIANNETTI SHULMAN ASSOCIATES
CONSULTING ENGINEERS & DESIGNERS
1000 N. MIAMI AVENUE, SUITE 1000
MIAMI, FL 33136
(305) 328-7700 FAX (305) 328-7700

GSA PROJ. No. 5789

PHASE I TRANSPORTATION CENTER

SEMINOLE COCONUT CREEK CASINO
SEMINOLE TRIBE OF FLORIDA
5600 NW 40TH STREET
COCONUT CREEK, FLORIDA 33073

KEY PLAN

EG503

DRAWN BY: BK
CHECKED BY: DAS
ISSUE DATE: 04-18-11
ANSI JOB NUMBER: 2102015
SHEET NAME: PARTIAL FLOOR PLAN LEVEL 2 - PHOTOMETRIC
SHEET NUMBER: EG503