


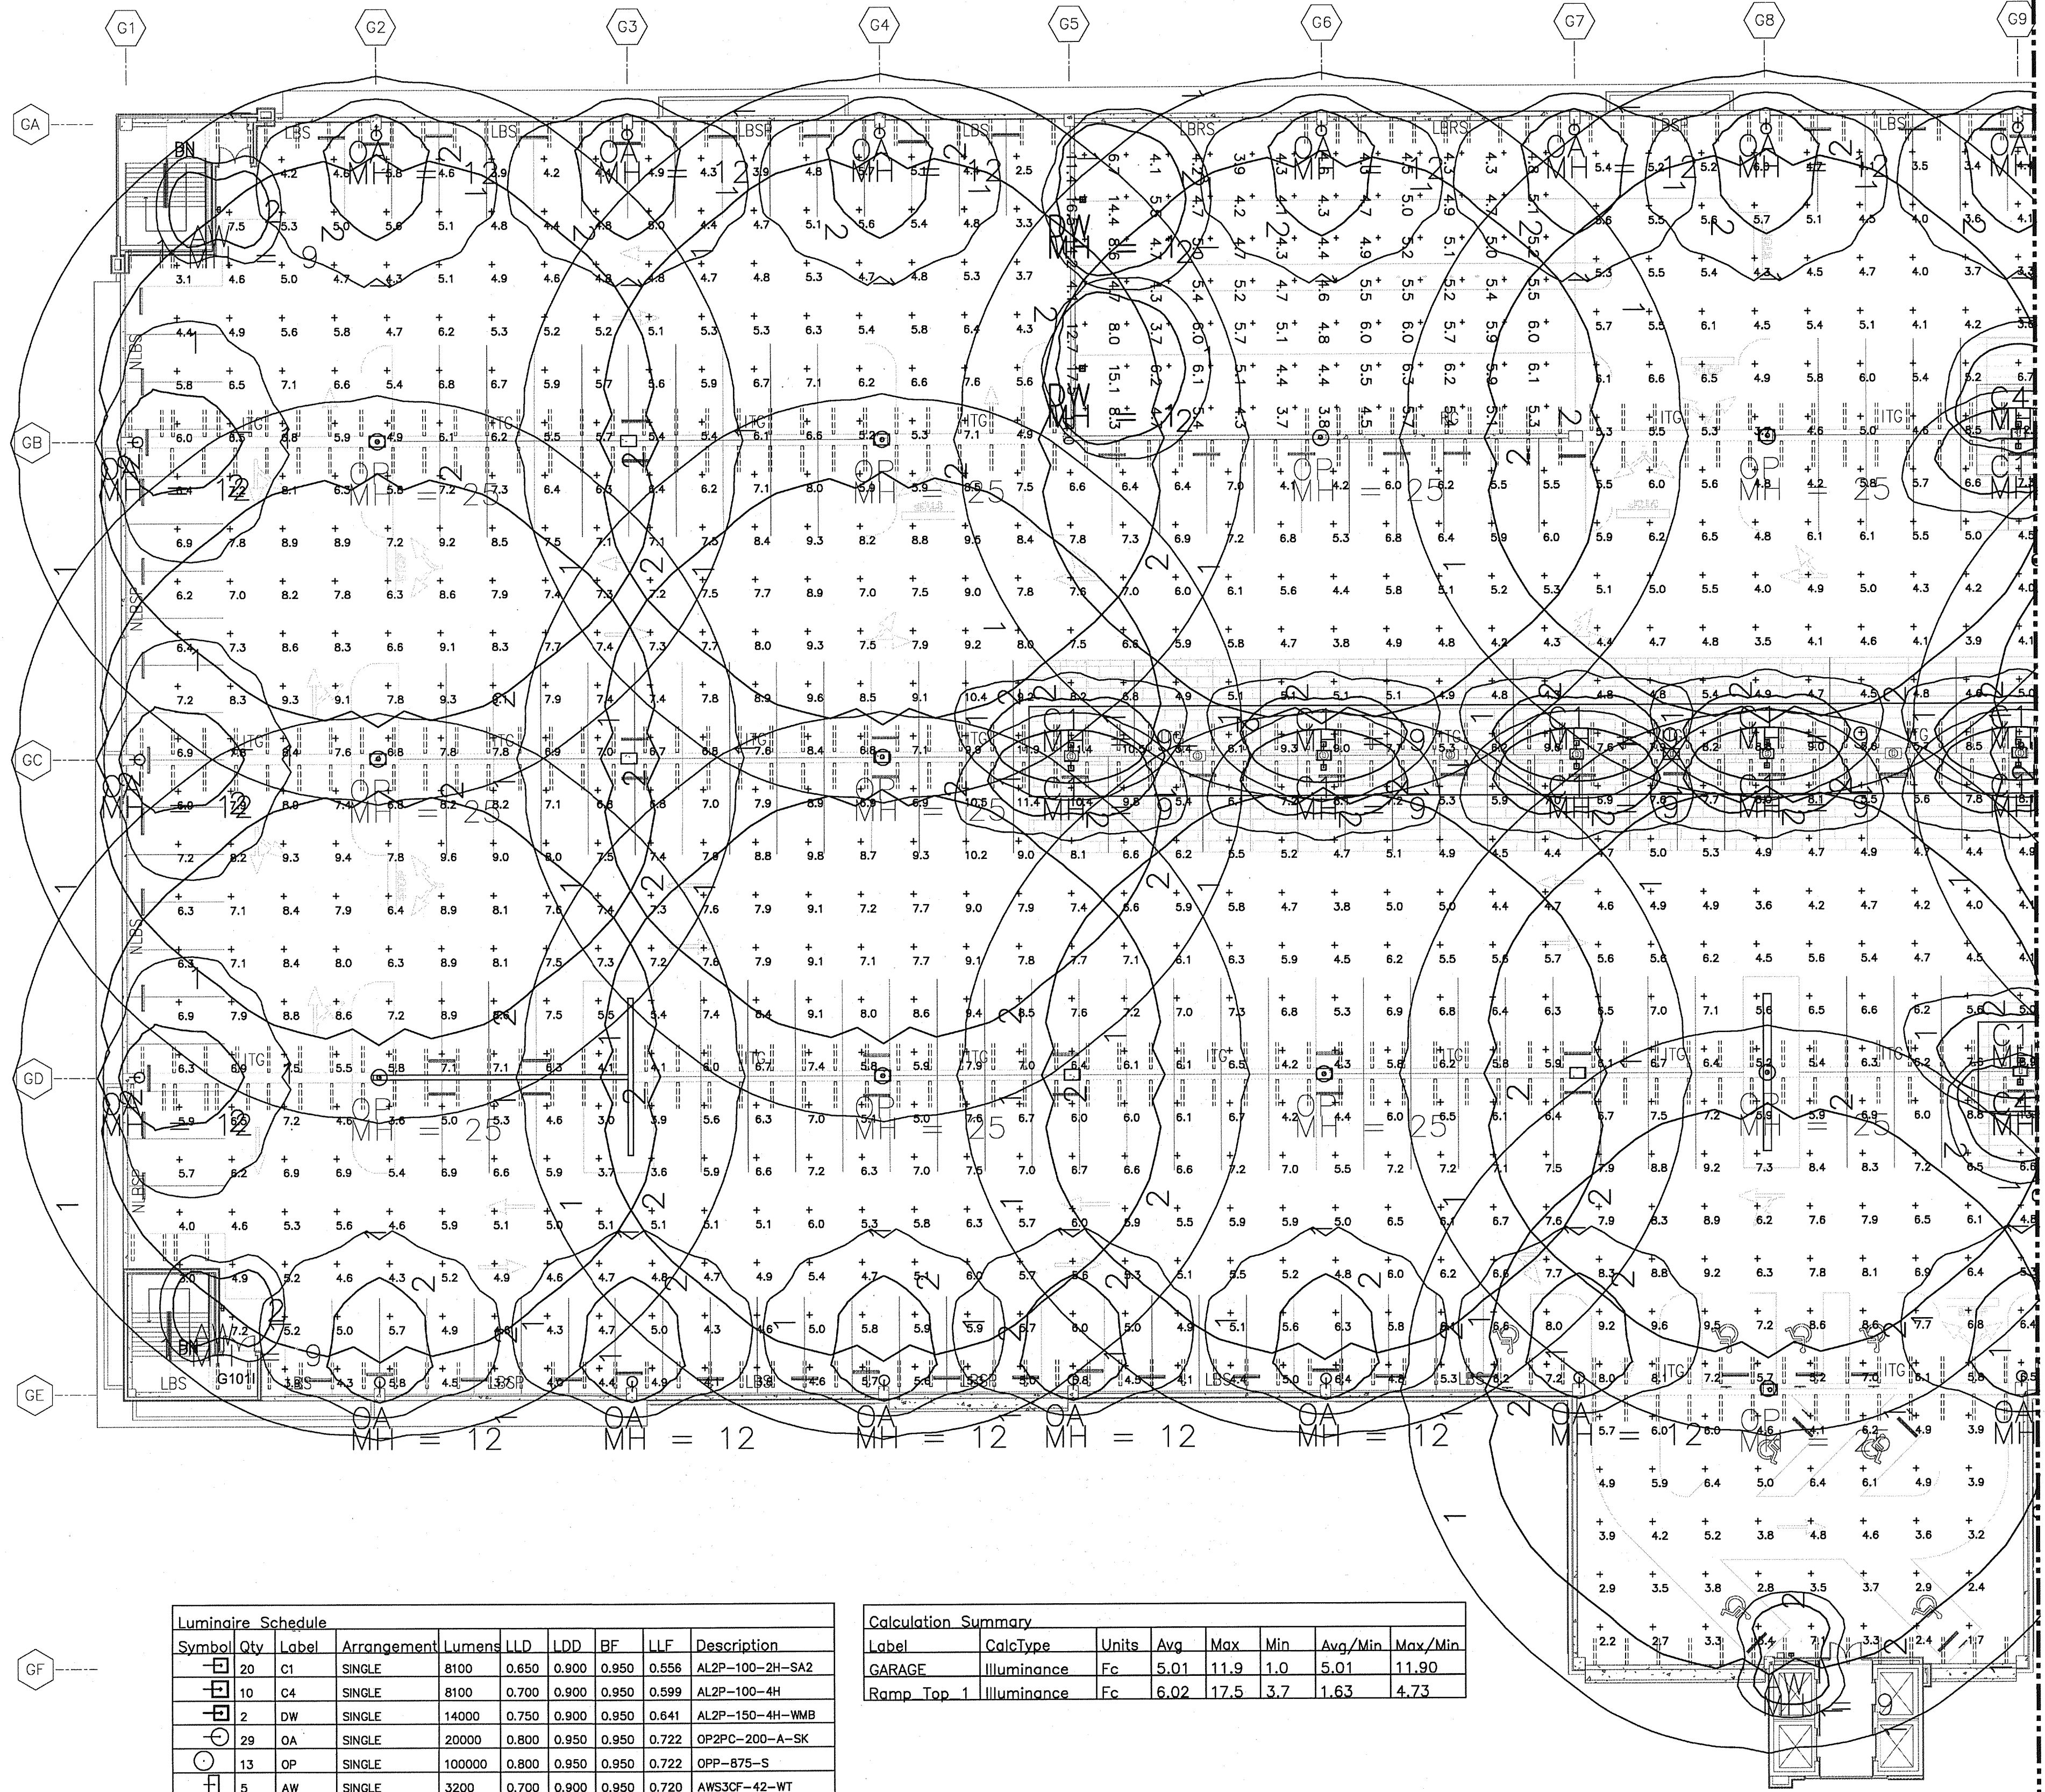

Luminaire Schedule									
Symbol	Qty	Label	Arrangement	Lumens	LLD	LDD	BF	LLF	Description
	20	C1	SINGLE	8100	0.650	0.900	0.950	0.556	AL2P-100-2H-SA2
	10	C4	SINGLE	8100	0.700	0.900	0.950	0.599	AL2P-100-4H
	2	DW	SINGLE	14000	0.750	0.900	0.950	0.641	AL2P-150-4H-WMB
	28	OA	SINGLE	20000	0.800	0.950	0.950	0.722	OP2PC-200-A-SK
	13	OP	SINGLE	100000	0.800	0.950	0.950	0.722	OPP-675-S
	5	AW	SINGLE	3200	0.700	0.900	0.950	0.720	AWS3CF-42-WT

Calculation Summary							
Label	CalcType	Units	Avg	Max	Min	Avg/Min	Max/Min
GARAGE	Illuminance	Fc	5.01	11.9	1.0	5.01	11.90
Ramp Top 1	Illuminance	Fc	6.02	17.5	3.7	1.63	4.73

PARTIAL FLOOR PLAN LEVEL 7 - PHOTOMETRIC
1/16" = 1'-0"

Date

04-18-11

ISSUED FOR PERMIT

PROJECT NAME

PHASE I TRANSPORTATION CENTER

PROJECT ADDRESS

SEMINOLE COCONUT CREEK CASINO
SEMINOLE TRIBE OF FLORIDA
5600 NW 40TH STREET
COCONUT CREEK, FLORIDA 33073

PROJECT NUMBER

212B015

SHEET NAME

PARTIAL FLOOR PLAN
LEVEL 7
PHOTOMETRIC

SHEET NUMBER

EG507

REDMUTTER GROUP

ARCHITECTURE INTERIOR DESIGN / BRANDING STUDIOS

10000 BAYVIEW BLVD SUITE 1000
FORT LAUDERDALE, FL 33304
(954) 341-1111
WWW.REDMUTTERGROUP.COM

GOVIND K. SHUKLA ASSOCIATES

CONSULTING ENGINEERS & DESIGNERS

10000 BAYVIEW BLVD SUITE 1000
FORT LAUDERDALE, FL 33304
(954) 341-1111 FAX (954) 341-1112

CONSULTANT

GOVIND K. SHUKLA ASSOCIATES

CONSULTING ENGINEERS & DESIGNERS

10000 BAYVIEW BLVD SUITE 1000
FORT LAUDERDALE, FL 33304
(954) 341-1111 FAX (954) 341-1112

PROJECT NAME

PHASE I TRANSPORTATION CENTER

PROJECT ADDRESS

SEMINOLE COCONUT CREEK CASINO
SEMINOLE TRIBE OF FLORIDA
5600 NW 40TH STREET
COCONUT CREEK, FLORIDA 33073

PROJECT NUMBER

212B015

SHEET NAME

PARTIAL FLOOR PLAN
LEVEL 7
PHOTOMETRIC

SHEET NUMBER

EG507