



PHOTOMETRICS PLAN

SCALE: 1" = 40'-0"

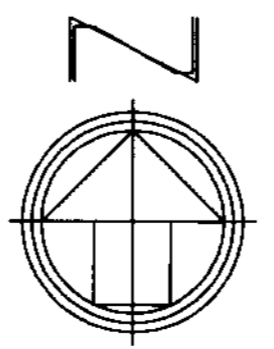


CALCULATION SUMMARY										
AREA NAME	DIMENSIONS	GRID / TYPE	# PTR	SPAC	GROUP	AVE	MAX	MIN	MAX/AVE	MIN/AVE
5150 Hillsboro Site	1442.50x988.80FT	Grid / H-H	794	10.00	<-> Parking	3.88	11.33	1.22	9.27	3.16
			4831	10.00	<-> Spill/genera	0.17	11.37	0.00	N/A	N/A

SITE LUMINAIRE SCHEDULE						
TYP	SYMBOL	DESCRIPTION	LAMP	LUMENS	MOUNTING/BALLAST	LLF QTY
SA	▲	Spouling PFL-A-P1K-V4-C-WH/2-SA-SGL-WHT	(1) 1000PMH	110000	30' MTC. HT.	0.73 4
SB	▲	Spouling PFL-A-P1K-V5-F-WH/2-SA-SGL-WHT	(1) 1000PMH	110000	30' MTC. HT.	0.73 4
D	⊙	LUMEC TRADITIONAL GLOBE SERIES L50-SE-SFO	150 WATT MH			

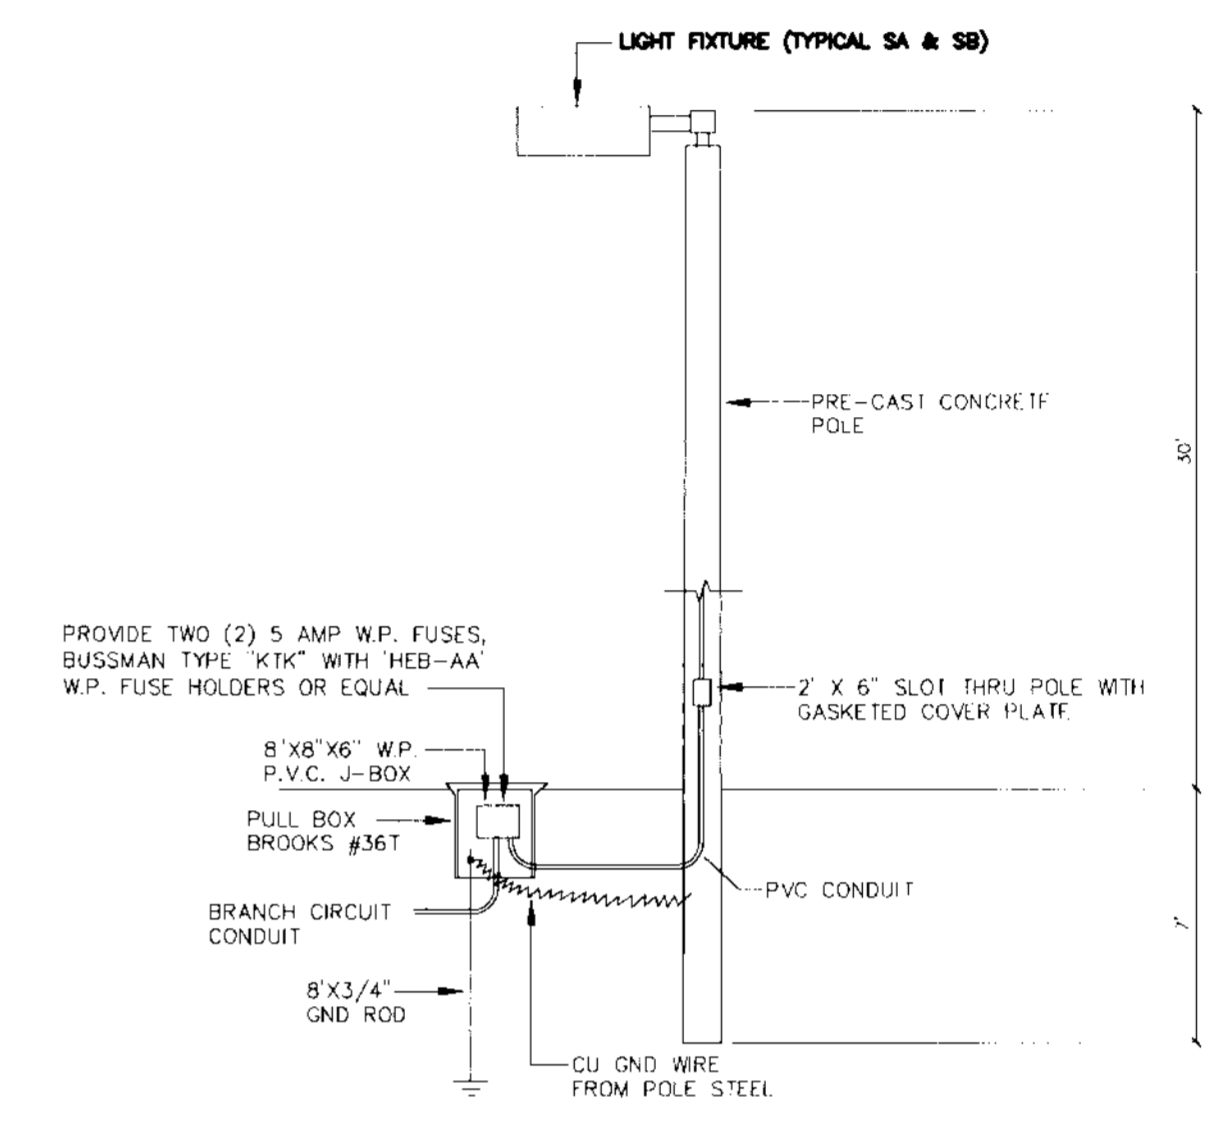

NOTE: POLE, FIXTURE AND BASE AS AN ASSEMBLY SHALL MEET THE WIND LOADING REQUIREMENTS OF STATE AND LOCAL CODES AND ORDINANCES, ASCE 7-98 AT 140 MPH, CATEGORY C. PROSPECTIVE LIGHTING SUPPLIER SHALL SUBMIT CERTIFIED DATA OF COMPLIANCE.

SITE LUMINAIRE & POLE DETAIL
N.T.S.

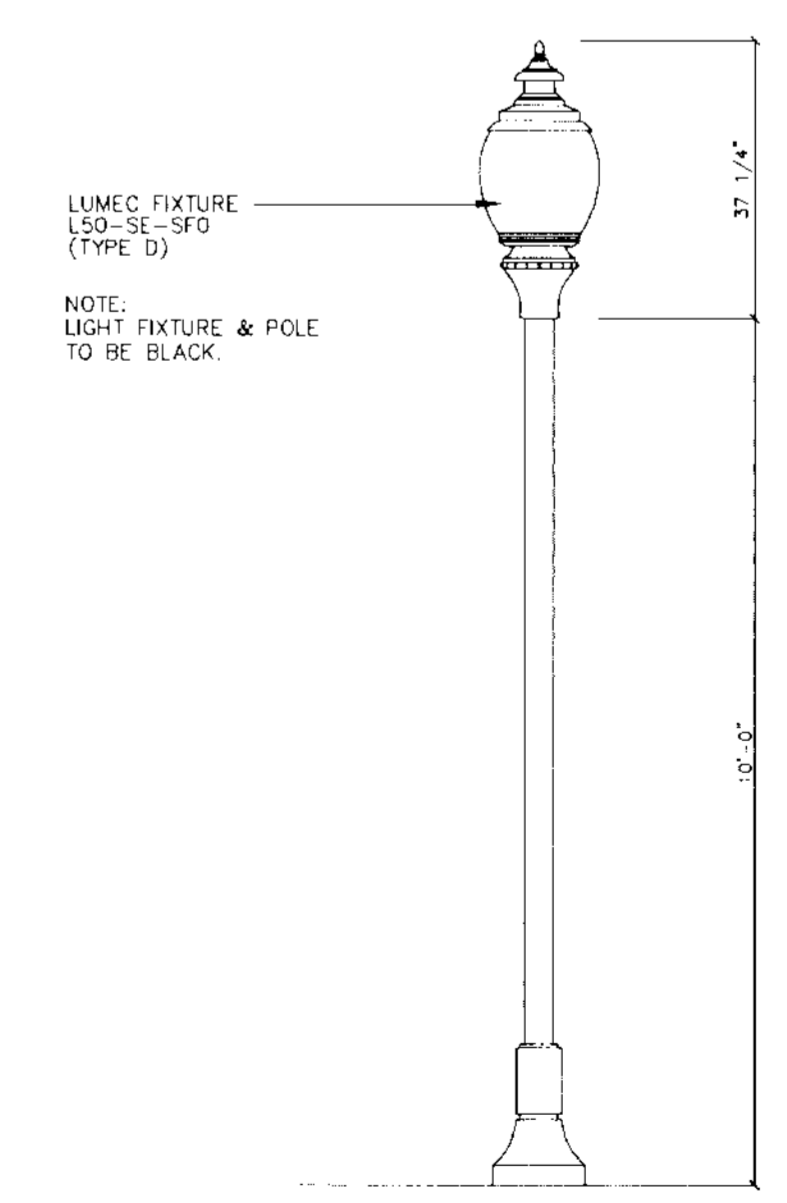

DECORATIVE POLE DETAIL
N.T.S.

OFFICE CONDOMINIUMS FOR
5150 HILLSBORO
COCONUT CREEK, FLORIDA

PROJECT NO. 06-29
DATE 8-25-06
BY MAP

KENT D. HAMILTON, A.I.A., ARCHITECT
NCARB REG. NO. 8622
235 COMMERCIAL BOULEVARD - SUITE 208 - LAUDERDALE-BY-THE-SEA - FLORIDA - 33308 - (954) 772-7240

PA
Fuge and Associates, Inc.
Engineers/Consultants
FH 000818
7288 S.W. 48 Street
Miami, Florida 33155
(305) 661-7700

NOV - 1 2006
J. DAVID RUPP
P.E. No. 41183

SHEET NO.
ESP-1
OF 1