



OWNER
 NORTH BROWARD
 PREPARATORY SCHOOL
 7600 LYONS ROAD
 COCONUT CREEK, FL 33073
 (T) 954.247.0011
 (F) 954.247.0012

ARCHITECT
PGAL
 Pierce Goodwin Alexander & Linville
 791 PARK OF COMMERCE BLVD.
 SUITE 400
 BOCA RATON, FL 33487
 (T) 561.988.4002
 (F) 561.988.3002

CONSULTANT

Kimley-Horn
 1690 S CONGRESS AVE, SUITE 100
 DELRAY BEACH, FL 33445
 PHONE: 561-330-2345 FAX: 561-330-2245
 WWW.KIMLEY-HORN.COM CA 0000096

PROJECT TITLE
 NORTH BROWARD
 PREPARATORY SCHOOL
 ATHLETIC & WELLNESS
 CENTER - BUILDING 900

PROJECT NUMBER
 R1002318.00

PROJECT LOCATION
 NORTH BROWARD
 PREPARATORY SCHOOL
 7600 LYONS ROAD
 COCONUT CREEK, FL 33073
 (T) 954.247.0011
 (F) 954.247.0012

DATE OF ISSUE
 APRIL 23, 2015

REVISIONS	DATE
AA	03/26/15
AA	04/23/15

DESIGNER
 JJ

CHECKED BY
 JAW

DRAWN BY
 JJ

SUBMITTAL PHASE /
 SET DESCRIPTION
 DRC ADMINISTRATIVE
 APPROVAL (AA)

APPROVED



JASON A. WEBBER, P.E.
 P.E. #7982
 TO THE BEST OF MY KNOWLEDGE, THE PLANS
 AND SPECIFICATIONS COMPLY WITH THE
 APPLICABLE MINIMUM BUILDING CODES AND
 APPLICABLE MINIMUM LIFE SAFETY STANDARDS
 COPYRIGHT © 2015

SHEET TITLE
 UTILITY PLAN


SHEET NUMBER
C-402

ADMINISTRATIVE APPROVAL (AA)

- LEGEND:**
- PROPERTY LINE/RIGHT OF WAY
 - - - - - EXISTING ELECTRIC LINE
 - - - - - EXISTING WATER MAIN
 - - - - - EXISTING STORM PIPE
 - SS --- SS --- SS --- PROPOSED SANITARY SEWER
 - STRM --- STRM --- PROPOSED STORM PIPE
 - W --- W --- W --- PROPOSED WATER MAIN

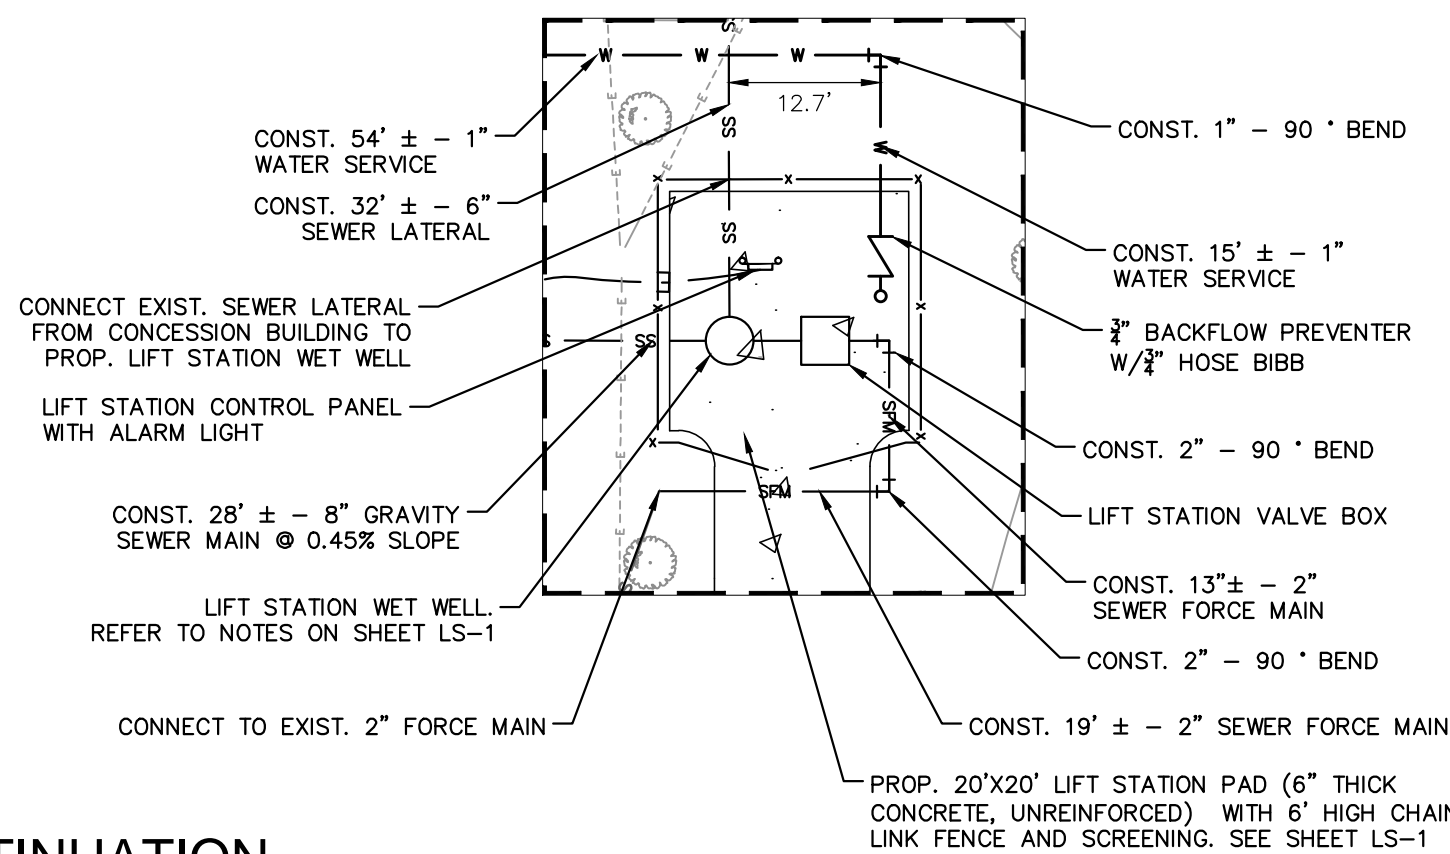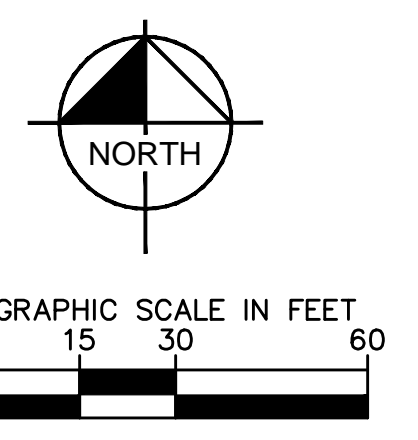

SEE SHEET C-401 FOR CONTINUATION

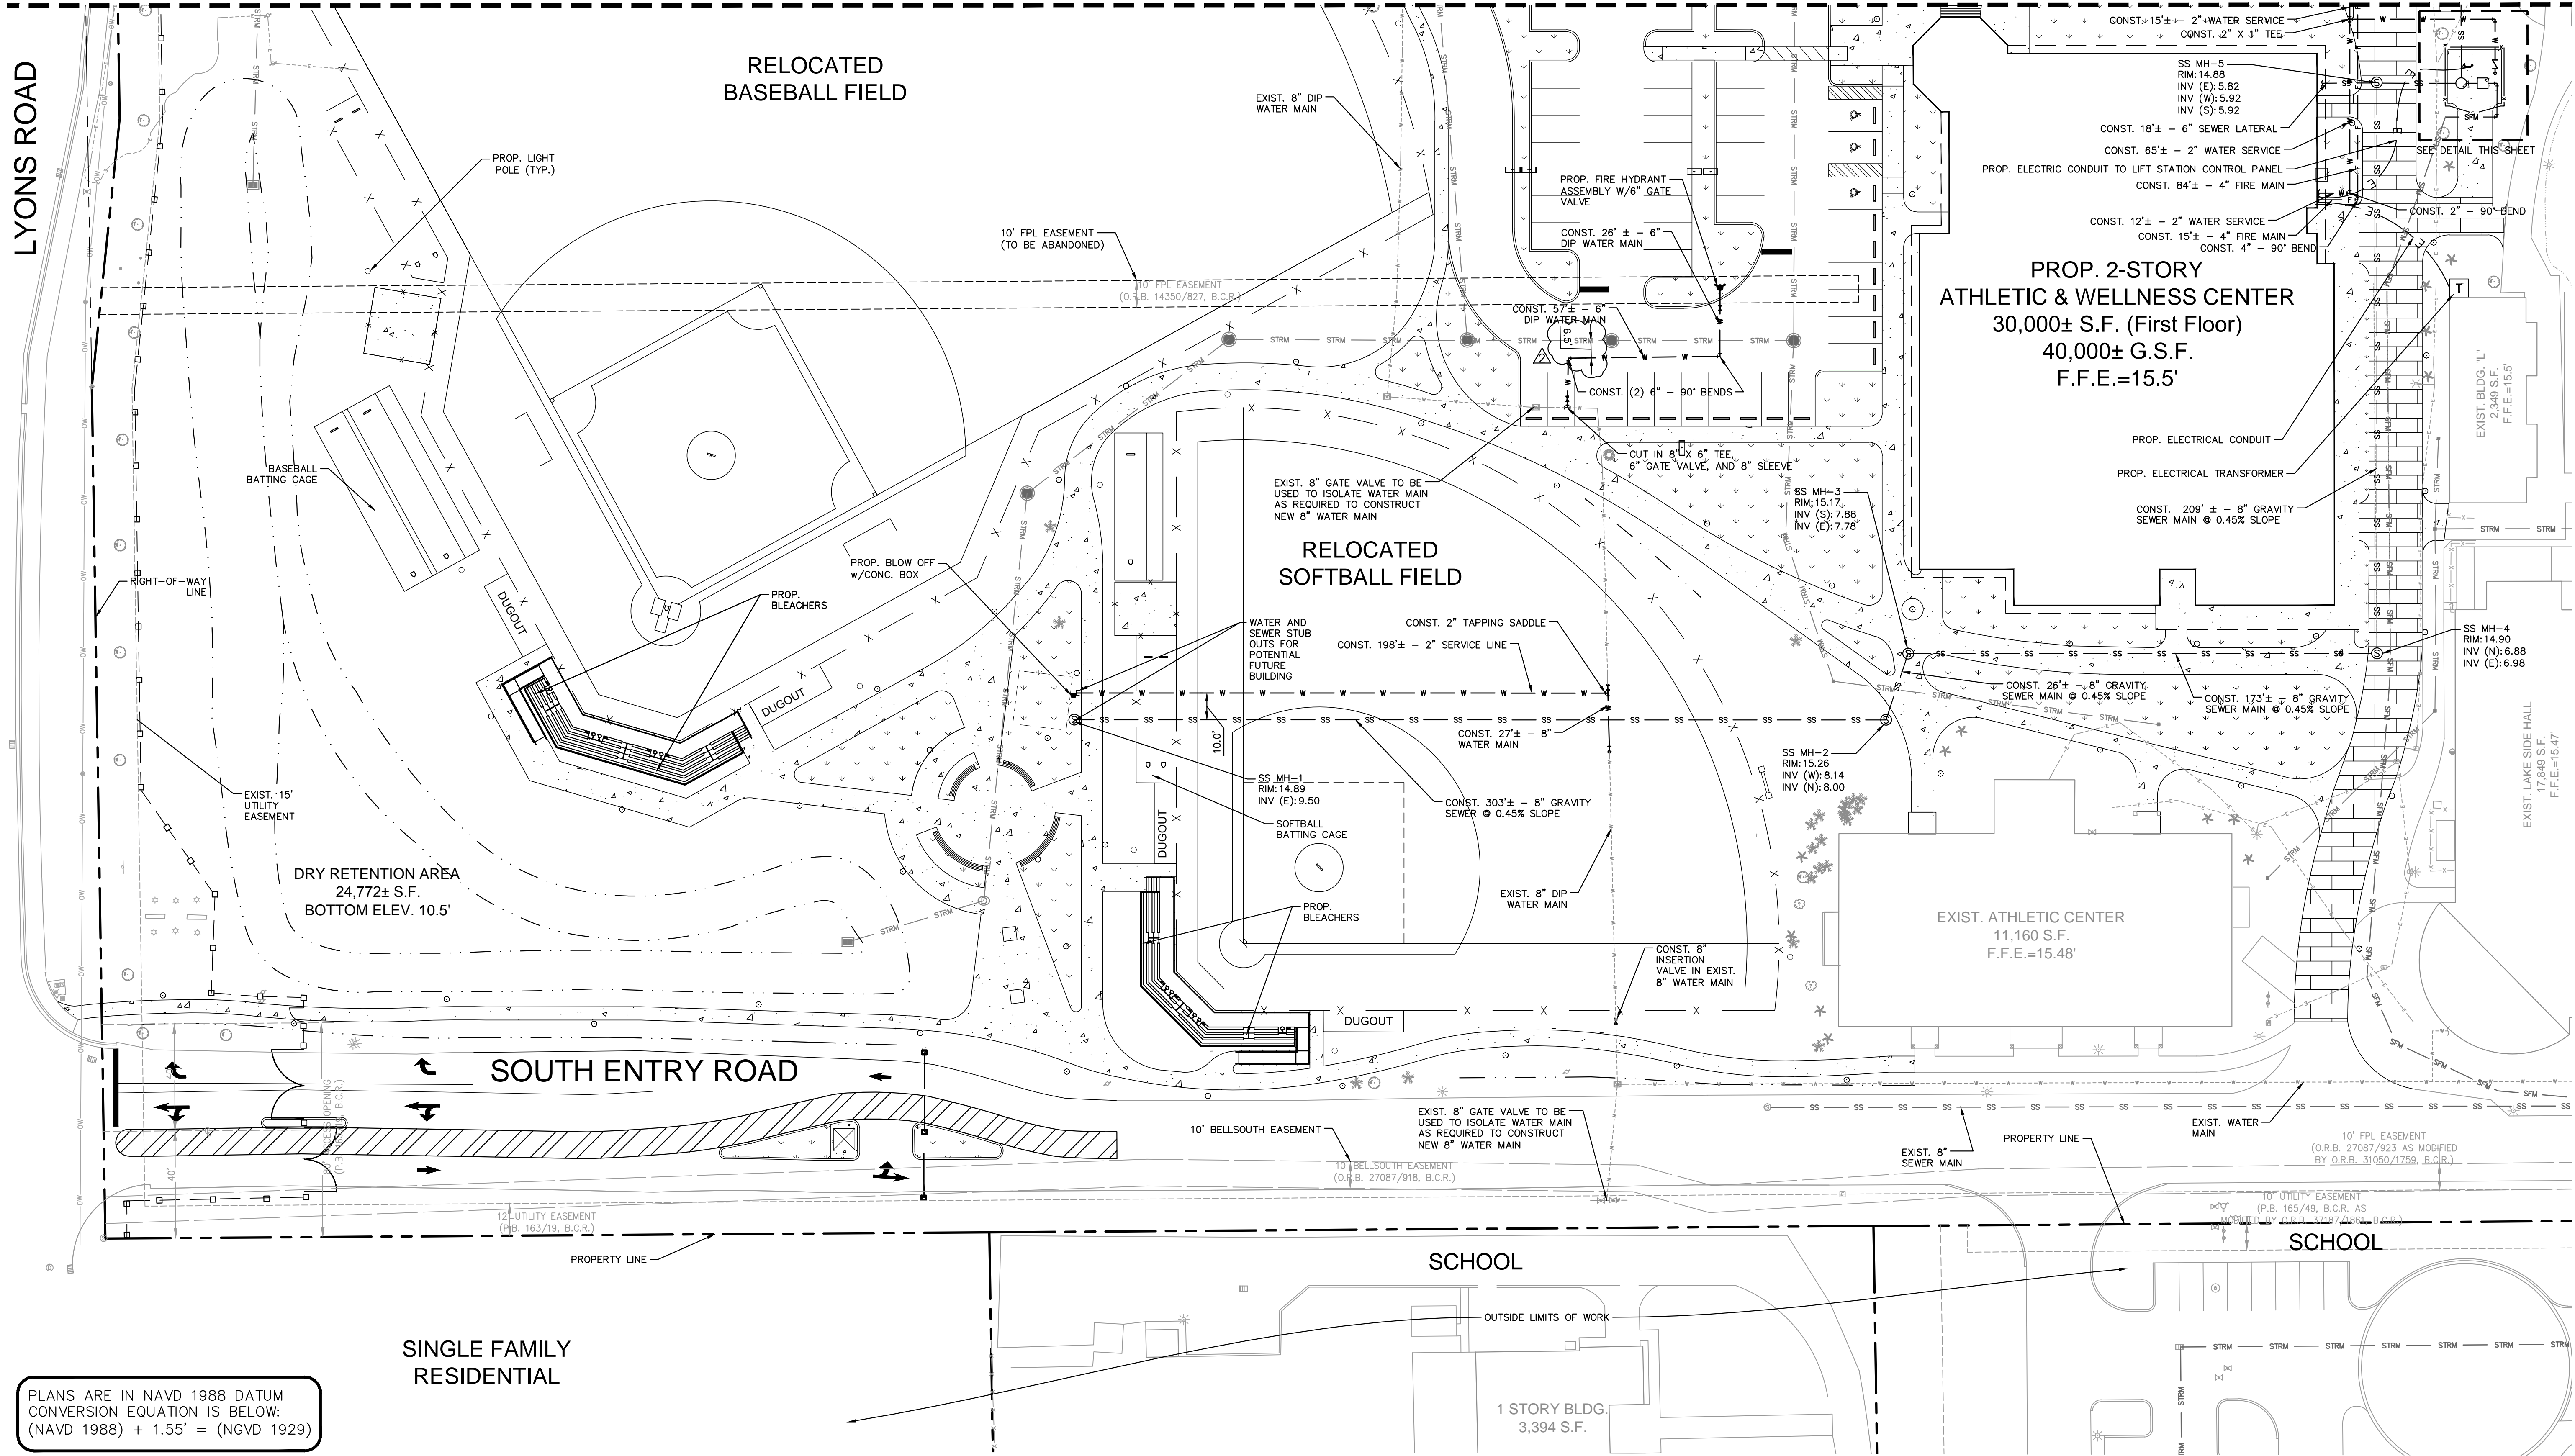

LYONS ROAD

PLANS ARE IN NAVD 1988 DATUM
 CONVERSION EQUATION IS BELOW:
 (NAVD 1988) + 1.55' = (NGVD 1929)

SINGLE FAMILY
 RESIDENTIAL