



PLAN

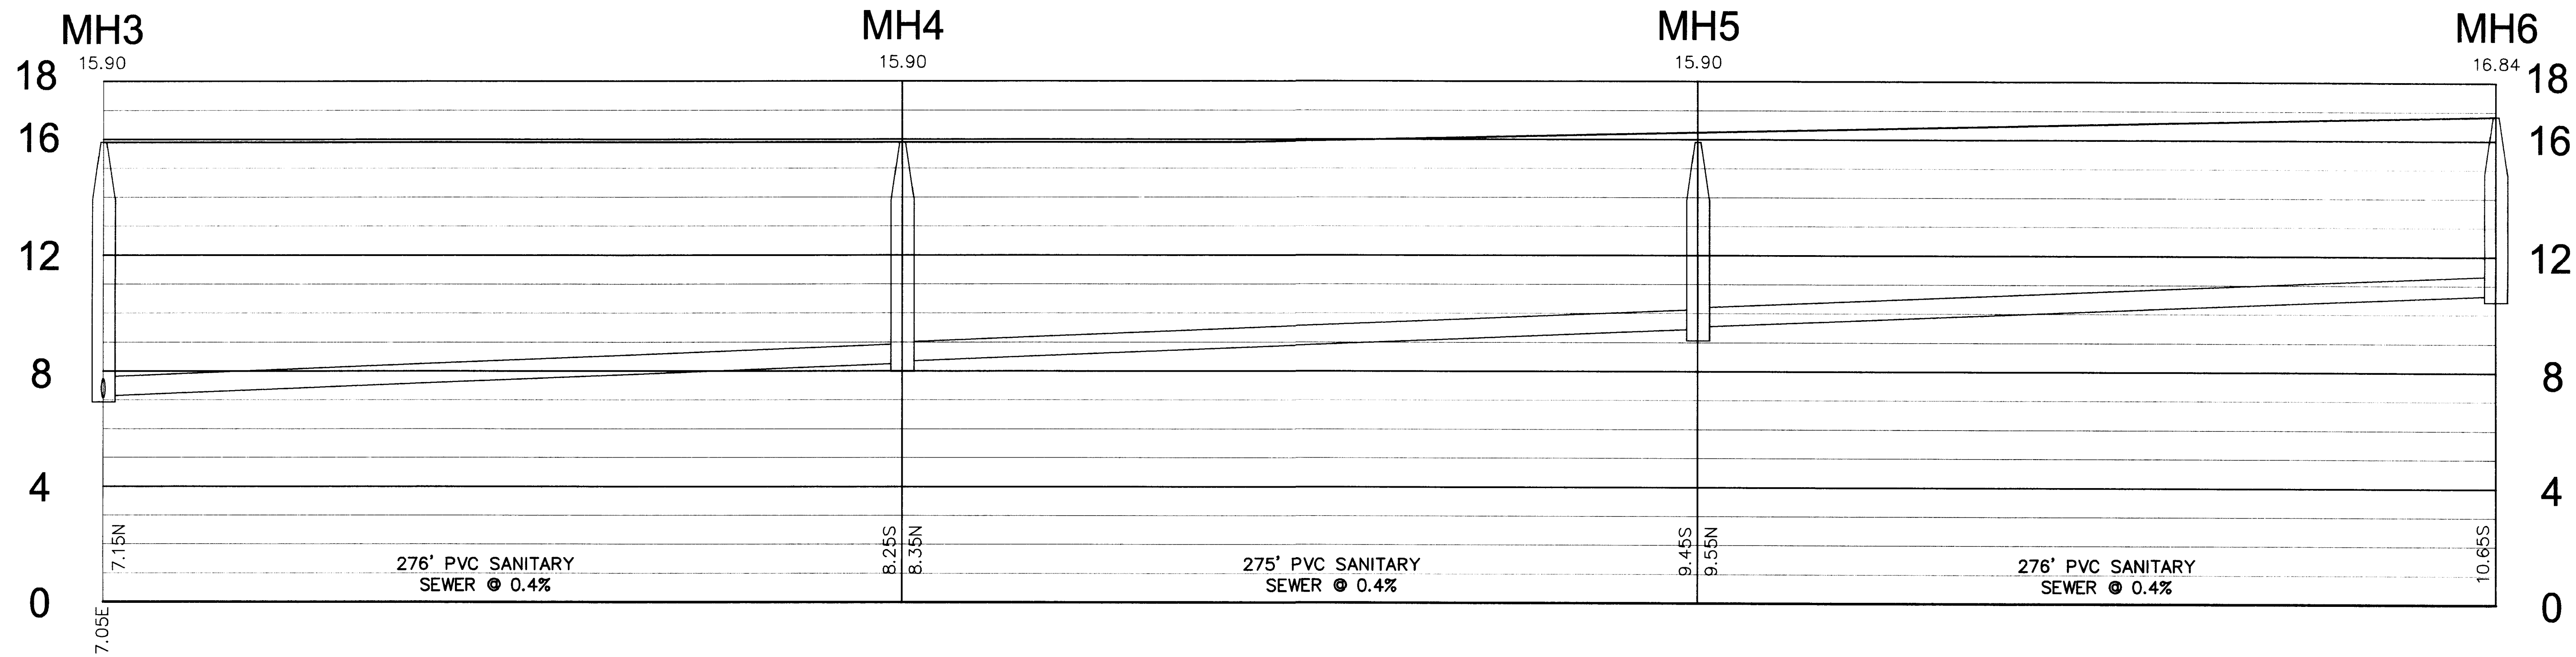

PROFILE

S:\040314\040314_C\dwg\040314\040314-SS.dwg, WSP, 6/19/2006 11:11:35 AM, KP6000.dwg, user defined field1

SCALE: 1:30 H, 1:3 V
 DATE: 09-27-05
 DRAWN BY: BDH
 CHECKED BY: DMA
 DESIGNED BY: DMA

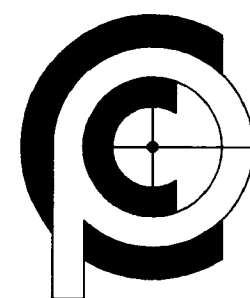

CARNAHAN-PROCTOR-CROSS, INC.

CONSULTING ENGINEERS • SURVEYORS • PLANNERS

8101 WEST ATLANTIC BOULEVARD, MARGATE, FLORIDA 33063
 PHONE: 954-972-3959 FAX: 954-972-4178
 3931 RCA BOULEVARD, SUITE 3114, PALM BEACH GARDENS, FLORIDA 33410
 PHONE: 561-799-5515 FAX: 561-799-5643

Website: www.carnahan-proctor.com

CERT. OF AUTH. # LB2936

PARK CREEK EXECUTIVE OFFICE

SANITARY SEWER PLAN AND PROFILE
 SR 7, COCONUT CREEK

D.M. AMBROSE
 FL. REG. NO. 12831

JUN 08 2006

SEAL

| NO | DATE | BY | CKD | REVISIONS |
|----|------|----|-----|-----------|
| | | | | |
| | | | | |
| | | | | |

FILE NO. 040314

SHEET C6 OF 9