


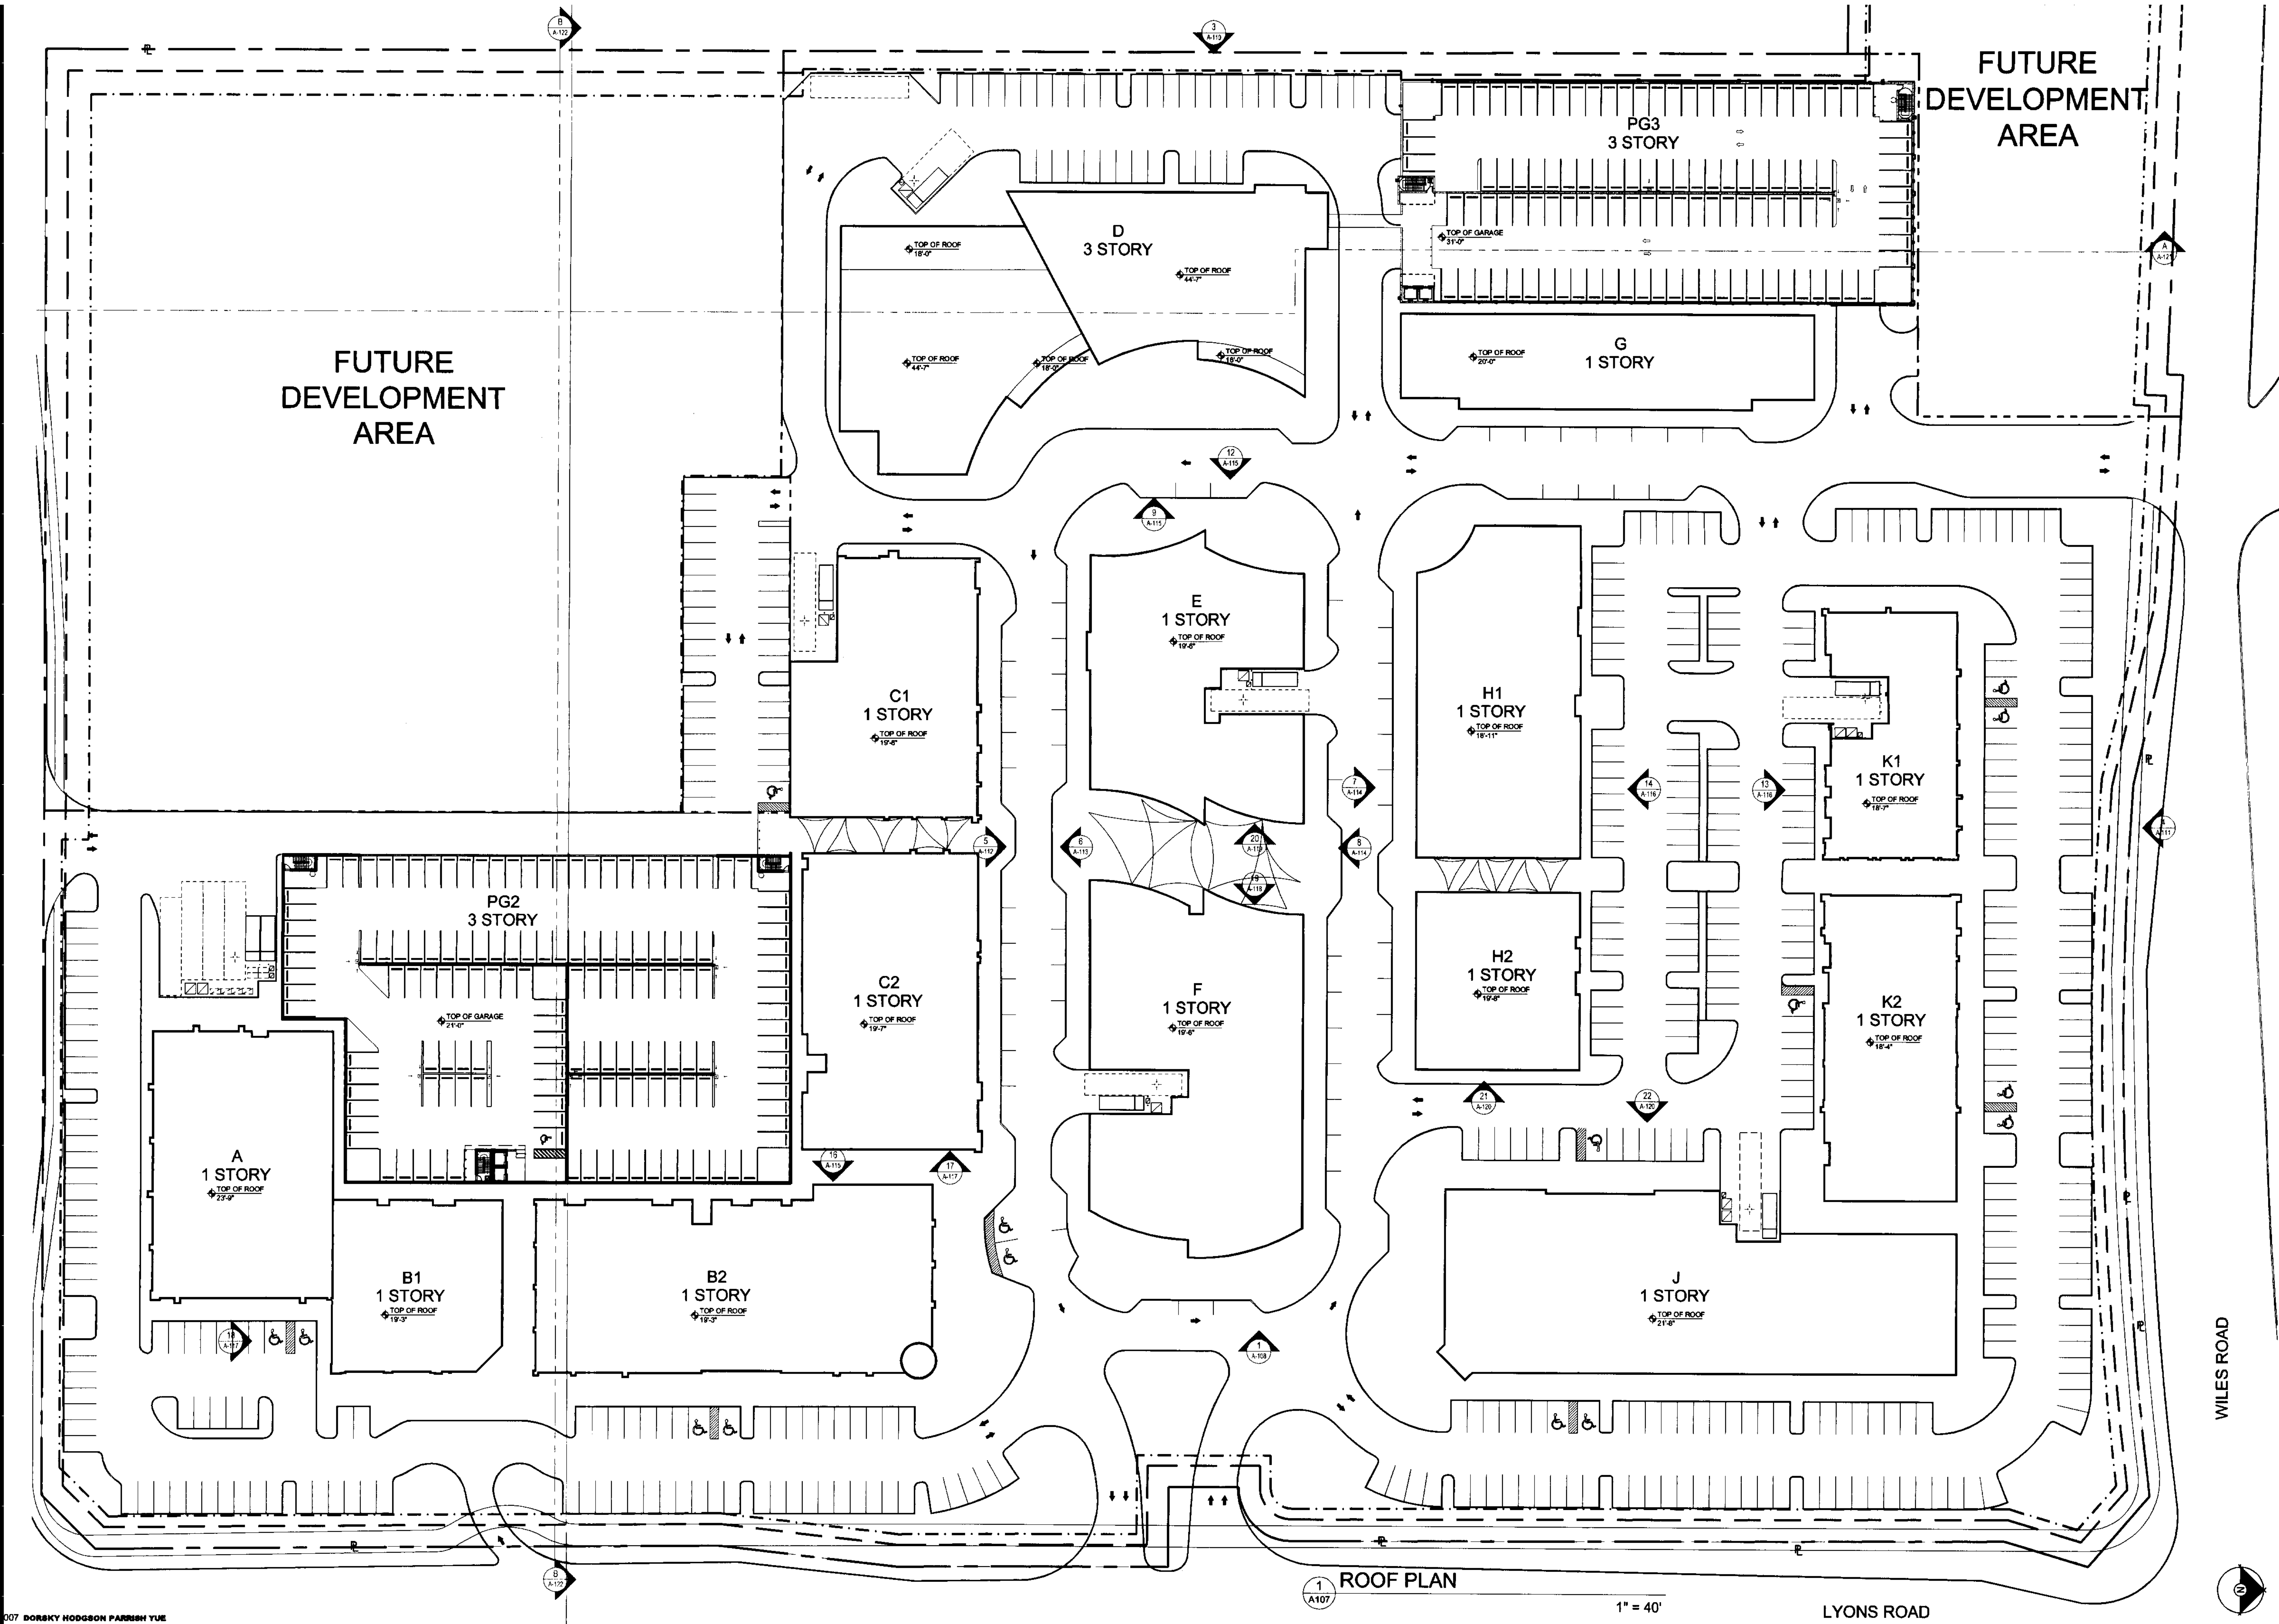

**DORSKY
HODGSON
PARRISH
YUE**

AA 26001261

Architecture
Planning
Interiors
Environmental
Graphics

Cleveland
Fort Lauderdale
Washington DC

Ft. Lauderdale, Florida 33394
Phone (954) 524-8686
Fax (954) 524-8604

APPLICANT: **COCONUT CREEK DEVELOPMENT LLC**

ROOF PLAN

Job No.: 2006113
Drawn: S.A.
Checked: V.S.
Date: 03-28-06

SOUTH WEST CORNER OF LYONS ROAD AND WILES ROAD, COCONUT CREEK, FLORIDA

ALL RIGHTS RESERVED