



**DORSKY
HODGSON
PARRISH
YUE**

AA 26001261

Architecture

Planning

Interiors

Environmental

Graphics


Cleveland

Fort Lauderdale

Washington DC

Ft. Lauderdale, Florida 33394
Phone (954) 524-8686
Fax (954) 524-8604

GROUND FLOOR PHOTOMETRIC FLOOR PLAN - BUILDING PG-3
APPLICANT: COCONUT CREEK DEVELOPMENT LLC
Job No.: 2005113
Date: 03/26/06
Checked: 03/26/06
Drawn: 03/26/06
SOUTH WEST CORNER OF LYONS ROAD AND WILES ROAD, COCONUT CREEK, FLORIDA
ALL RIGHTS RESERVED

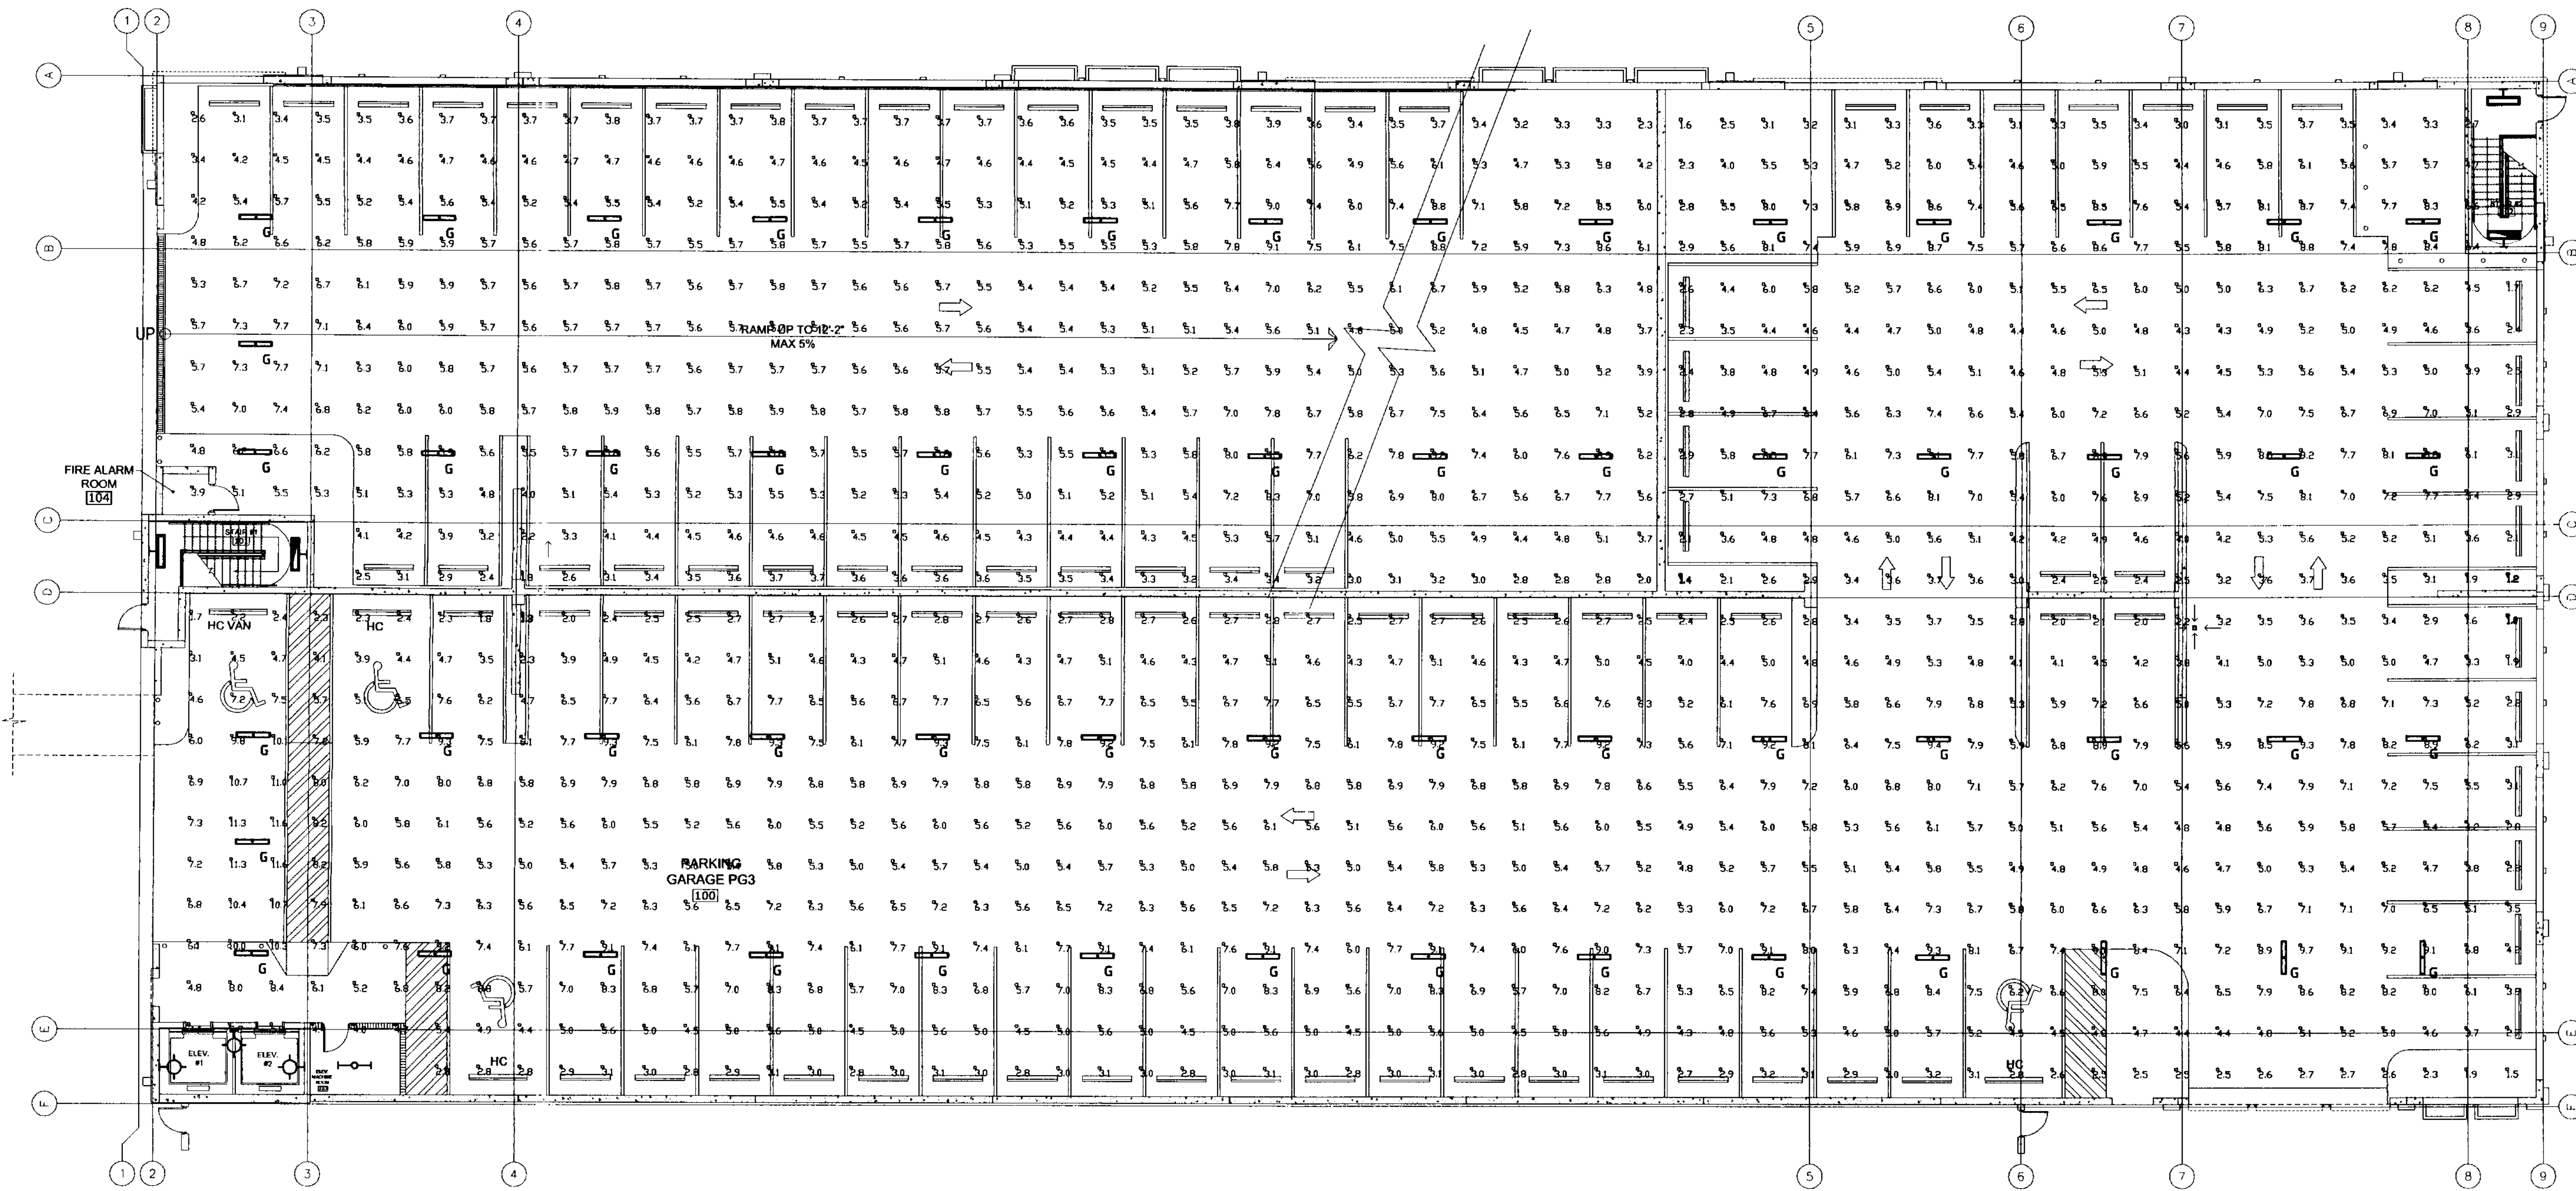


GROUND FLOOR PHOTOMETRIC FLOOR PLAN - BUILDING PG-3

3/32" = 1'-0"

Luminaire Schedule: PROMENADE CCTC 1ST LEVEL REV1					
Symbol	Qty	Label	Description	NOTE	LLF
	58	G	BEGHELLI: BS100-232TB		2900

Numeric Summary: PROMENADE CCTC 1ST LEVEL REV1					
Label	Avg	Max	Min	Avg/Min	Max/Min
Room_Floor	5.49	11.6	1.0	5.49	11.60

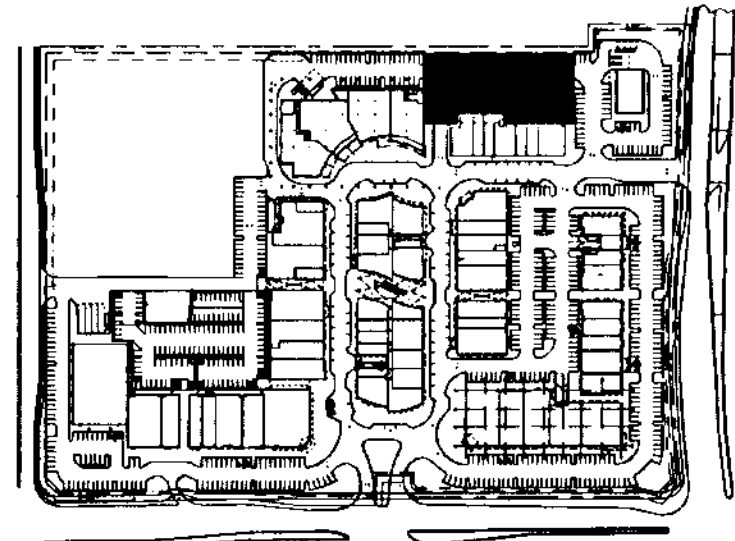

KEY PLAN

