



**DORSKY
HODGSON
PARRISH
YUE**

AA 26001261

Architecture
Planning
Interiors
Environmental
Graphics

Cleveland
Fort Lauderdale
Washington DC


Ft. Lauderdale, Florida 33394
 Phone (954) 524-8686
 Fax (954) 524-8604

APPLICANT: **COCONUT CREEK DEVELOPMENT LLC**

GROUND FLOOR PHOTOMETRIC PLAN - BUILDING PG-2

Job No.: 2006113
 Date: 03-28-06
 Drawn: Checked: ALL RIGHTS RESERVED

PH7.210

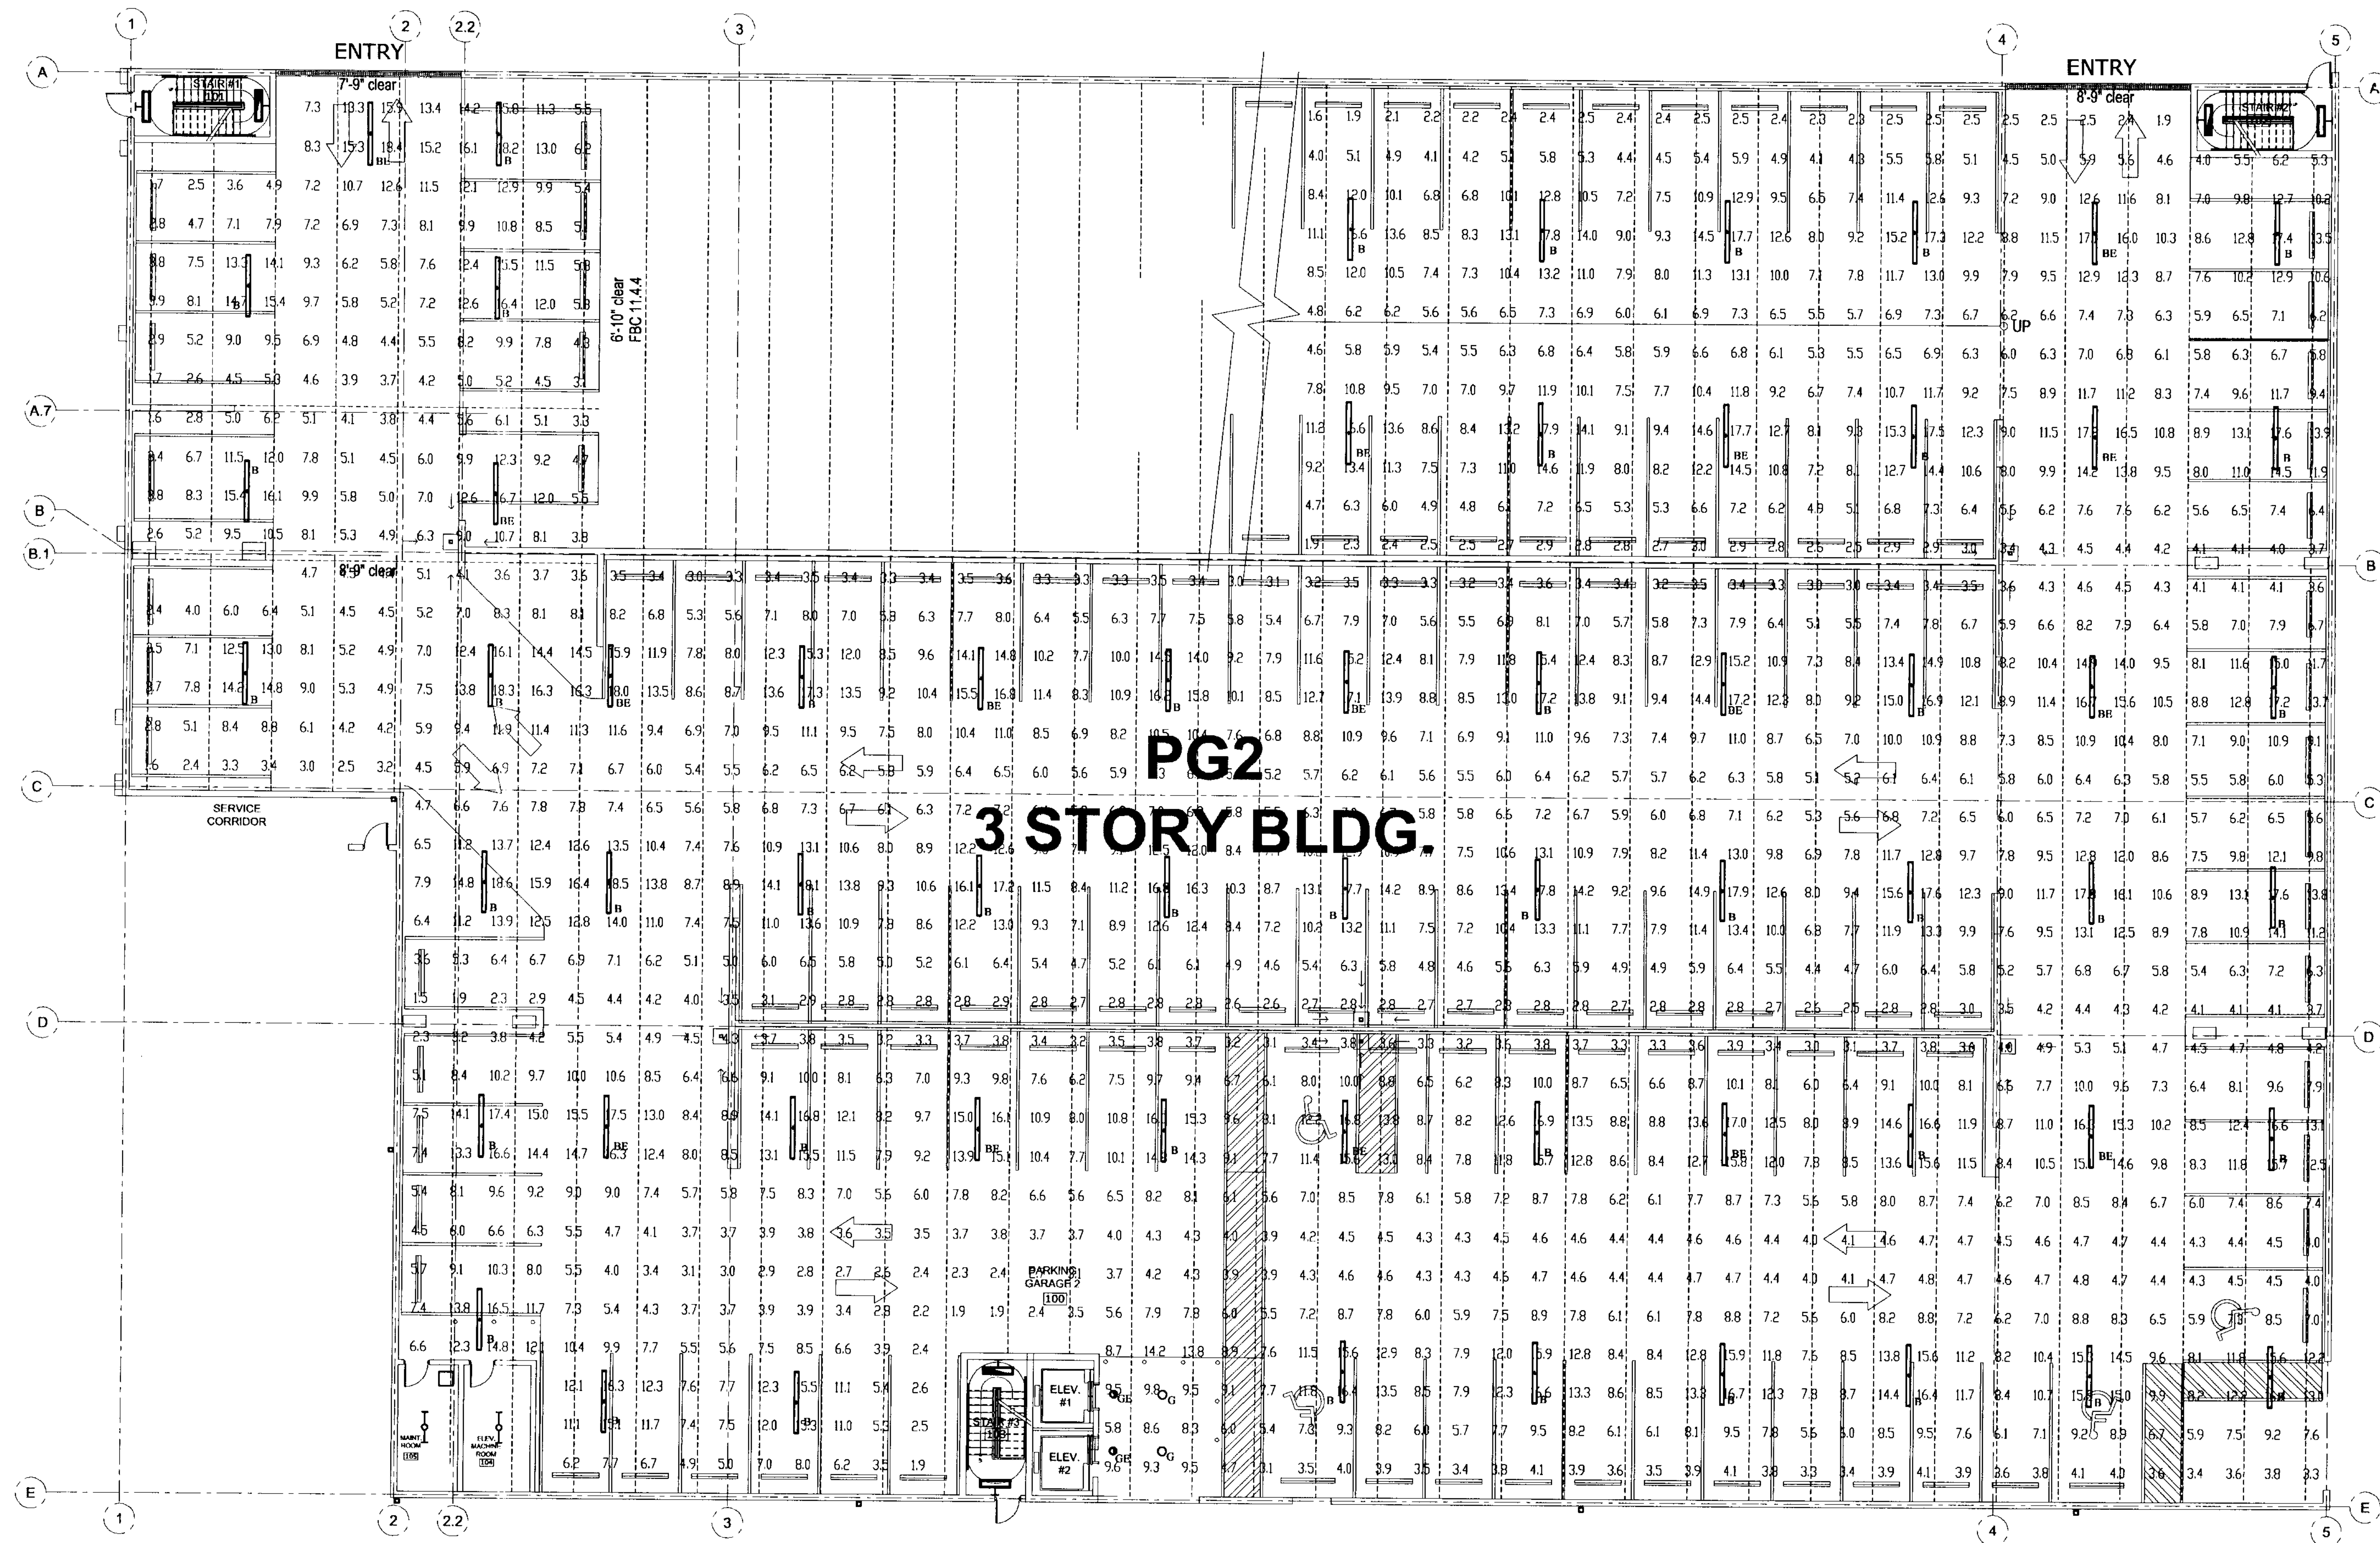

GROUND FLOOR PHOTOMETRIC PLAN - BUILDING PG-2


3/32" = 1'-0"

Numeric Summary: CCTC Parking Garage LEVEL GND

Label	Avg	Max	Min	Avg/Min	Max/Min
Room_Floor	7.94	18.6	1.5	5.29	12.40

Luminaire Schedule: CCTC Parking Garage LEVEL GND

Symbol	Label	Description	NOTE	Lumens	LLF
	B	Day-Brite TDVAE232		2900	0.750
	BE	Day-Brite TDVAE232-EMB			
	G	Luminaire SRV13-HD-2PLT42			
	GE	Luminaire SRV13-HD-2PLT42EB			

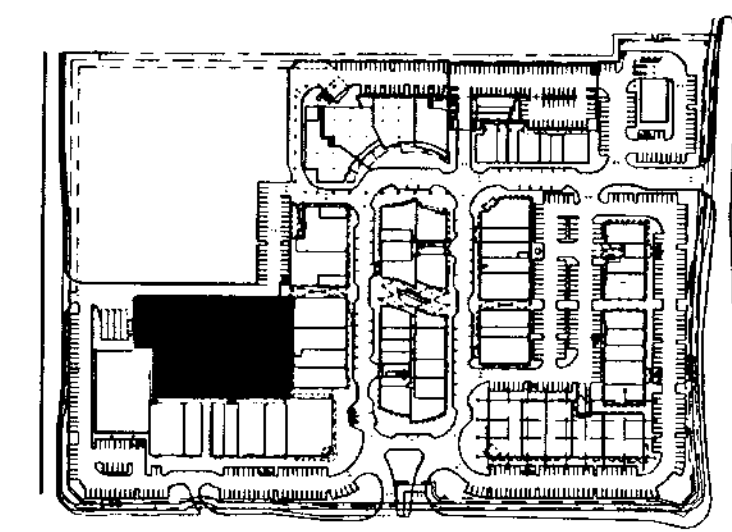

KEY PLAN

N.T.S.