


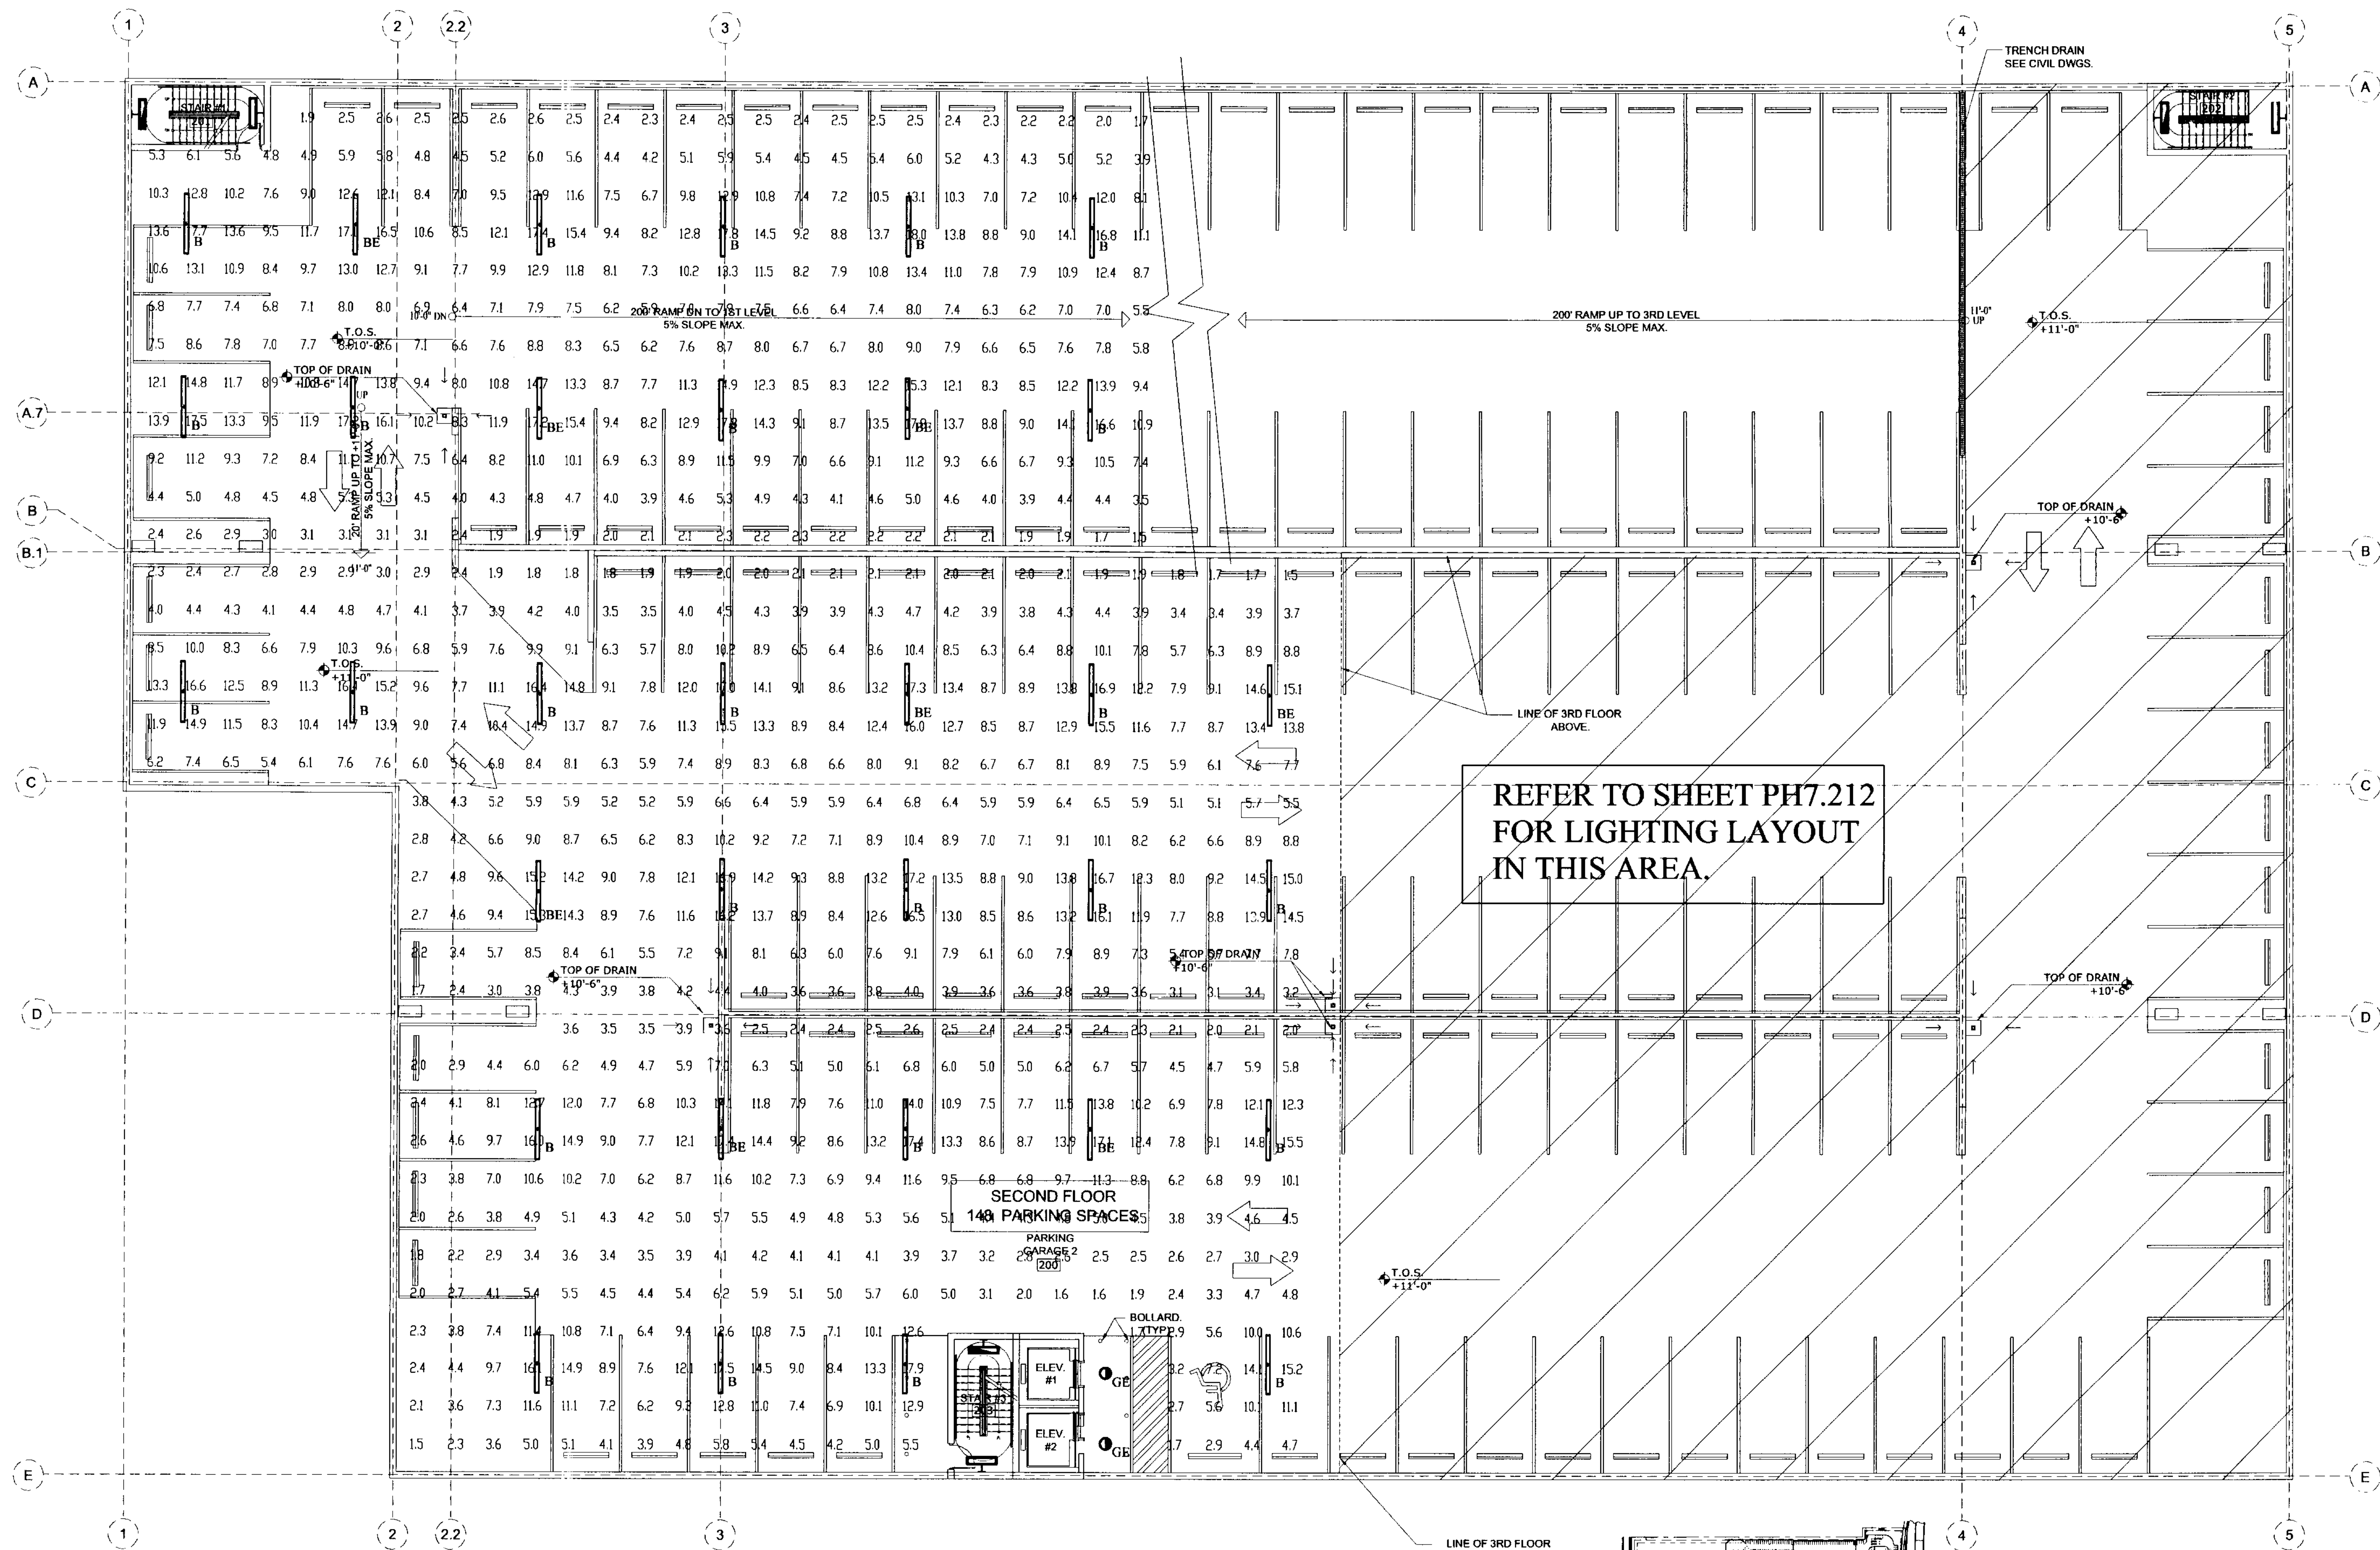


SECOND FLOOR PHOTOMETRIC PLAN - BUILDING PG-2

3/32" = 1'-0"

Numeric Summary: CCTC Parking Garage LEVEL 2ND					
Label	Avg	Max	Min	Avg/Min	Max/Min
Room_1_Floor	7.49	18.0	1.5	4.99	12.00

Luminaire Schedule: CCTC Parking Garage LEVEL 2ND					
Symbol	Label	Description	NOTE	Lumens	LLF
	B	Day-Brite TDVAE232		2900	0.750
	BE	Day-Brite TDVAE232-EMB			
	GE	Luminaire SRV13-HD-2PLT42-EMB			

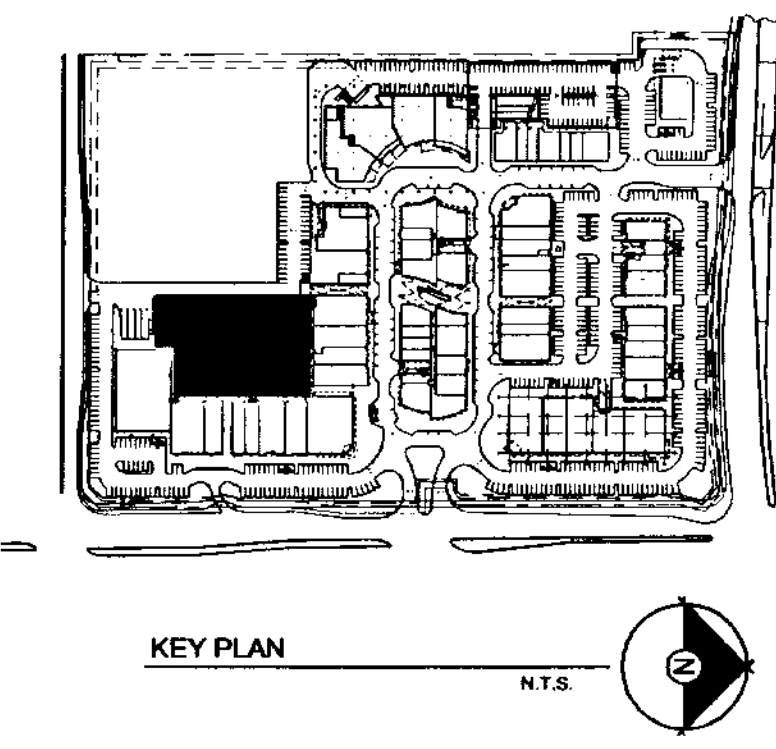

DELTA G
CONSULTING
ENGINEERS, INC.

307 N.E. 34th Ave., Suite 200
Fort Lauderdale, FL 33304
(954) 527-1112 FAX (954) 527-1113

GEORGE SANDOZ, P.E.
14800 E. LAKESHORE BLVD. #46100
DATE: 07/20/07
PJT MGR: JENNA GOLDENBERG
PROJECT #: 001110

Issue:	Date:
STTE PLAN Submittal	03-28-2006
DRC Comments #1	04-27-2006
DRC Comments #2	07-06-2006
Rev. #3 Tree & Plant	07-19-2006
Rev. #4 Final Engin.	12-15-2006
Rev. #5 Final Site App.	01-29-2007
Rev. #6 Admin. App.	06-25-2007
Rev. #7 Admin. App.	08-16-2007

**DORSKY
HODGSON
PARRISH
YUE**

AA 26001261

Architecture
Planning
Interiors
Environmental
Graphics

Cleveland
Fort Lauderdale
Washington DC

Fl. Lauderdale, Florida 33394
Phone (954) 524-8686
Fax (954) 524-8604

SECOND FLOOR PHOTOMETRIC PLAN - BUILDING PG-2

APPLICANT: **COCONUT CREEK DEVELOPMENT LLC**

Job No.: 2005113

Date: 03/28/06

Checked: 03/28/06

Drawn: 03/28/06

ALL RIGHTS RESERVED