


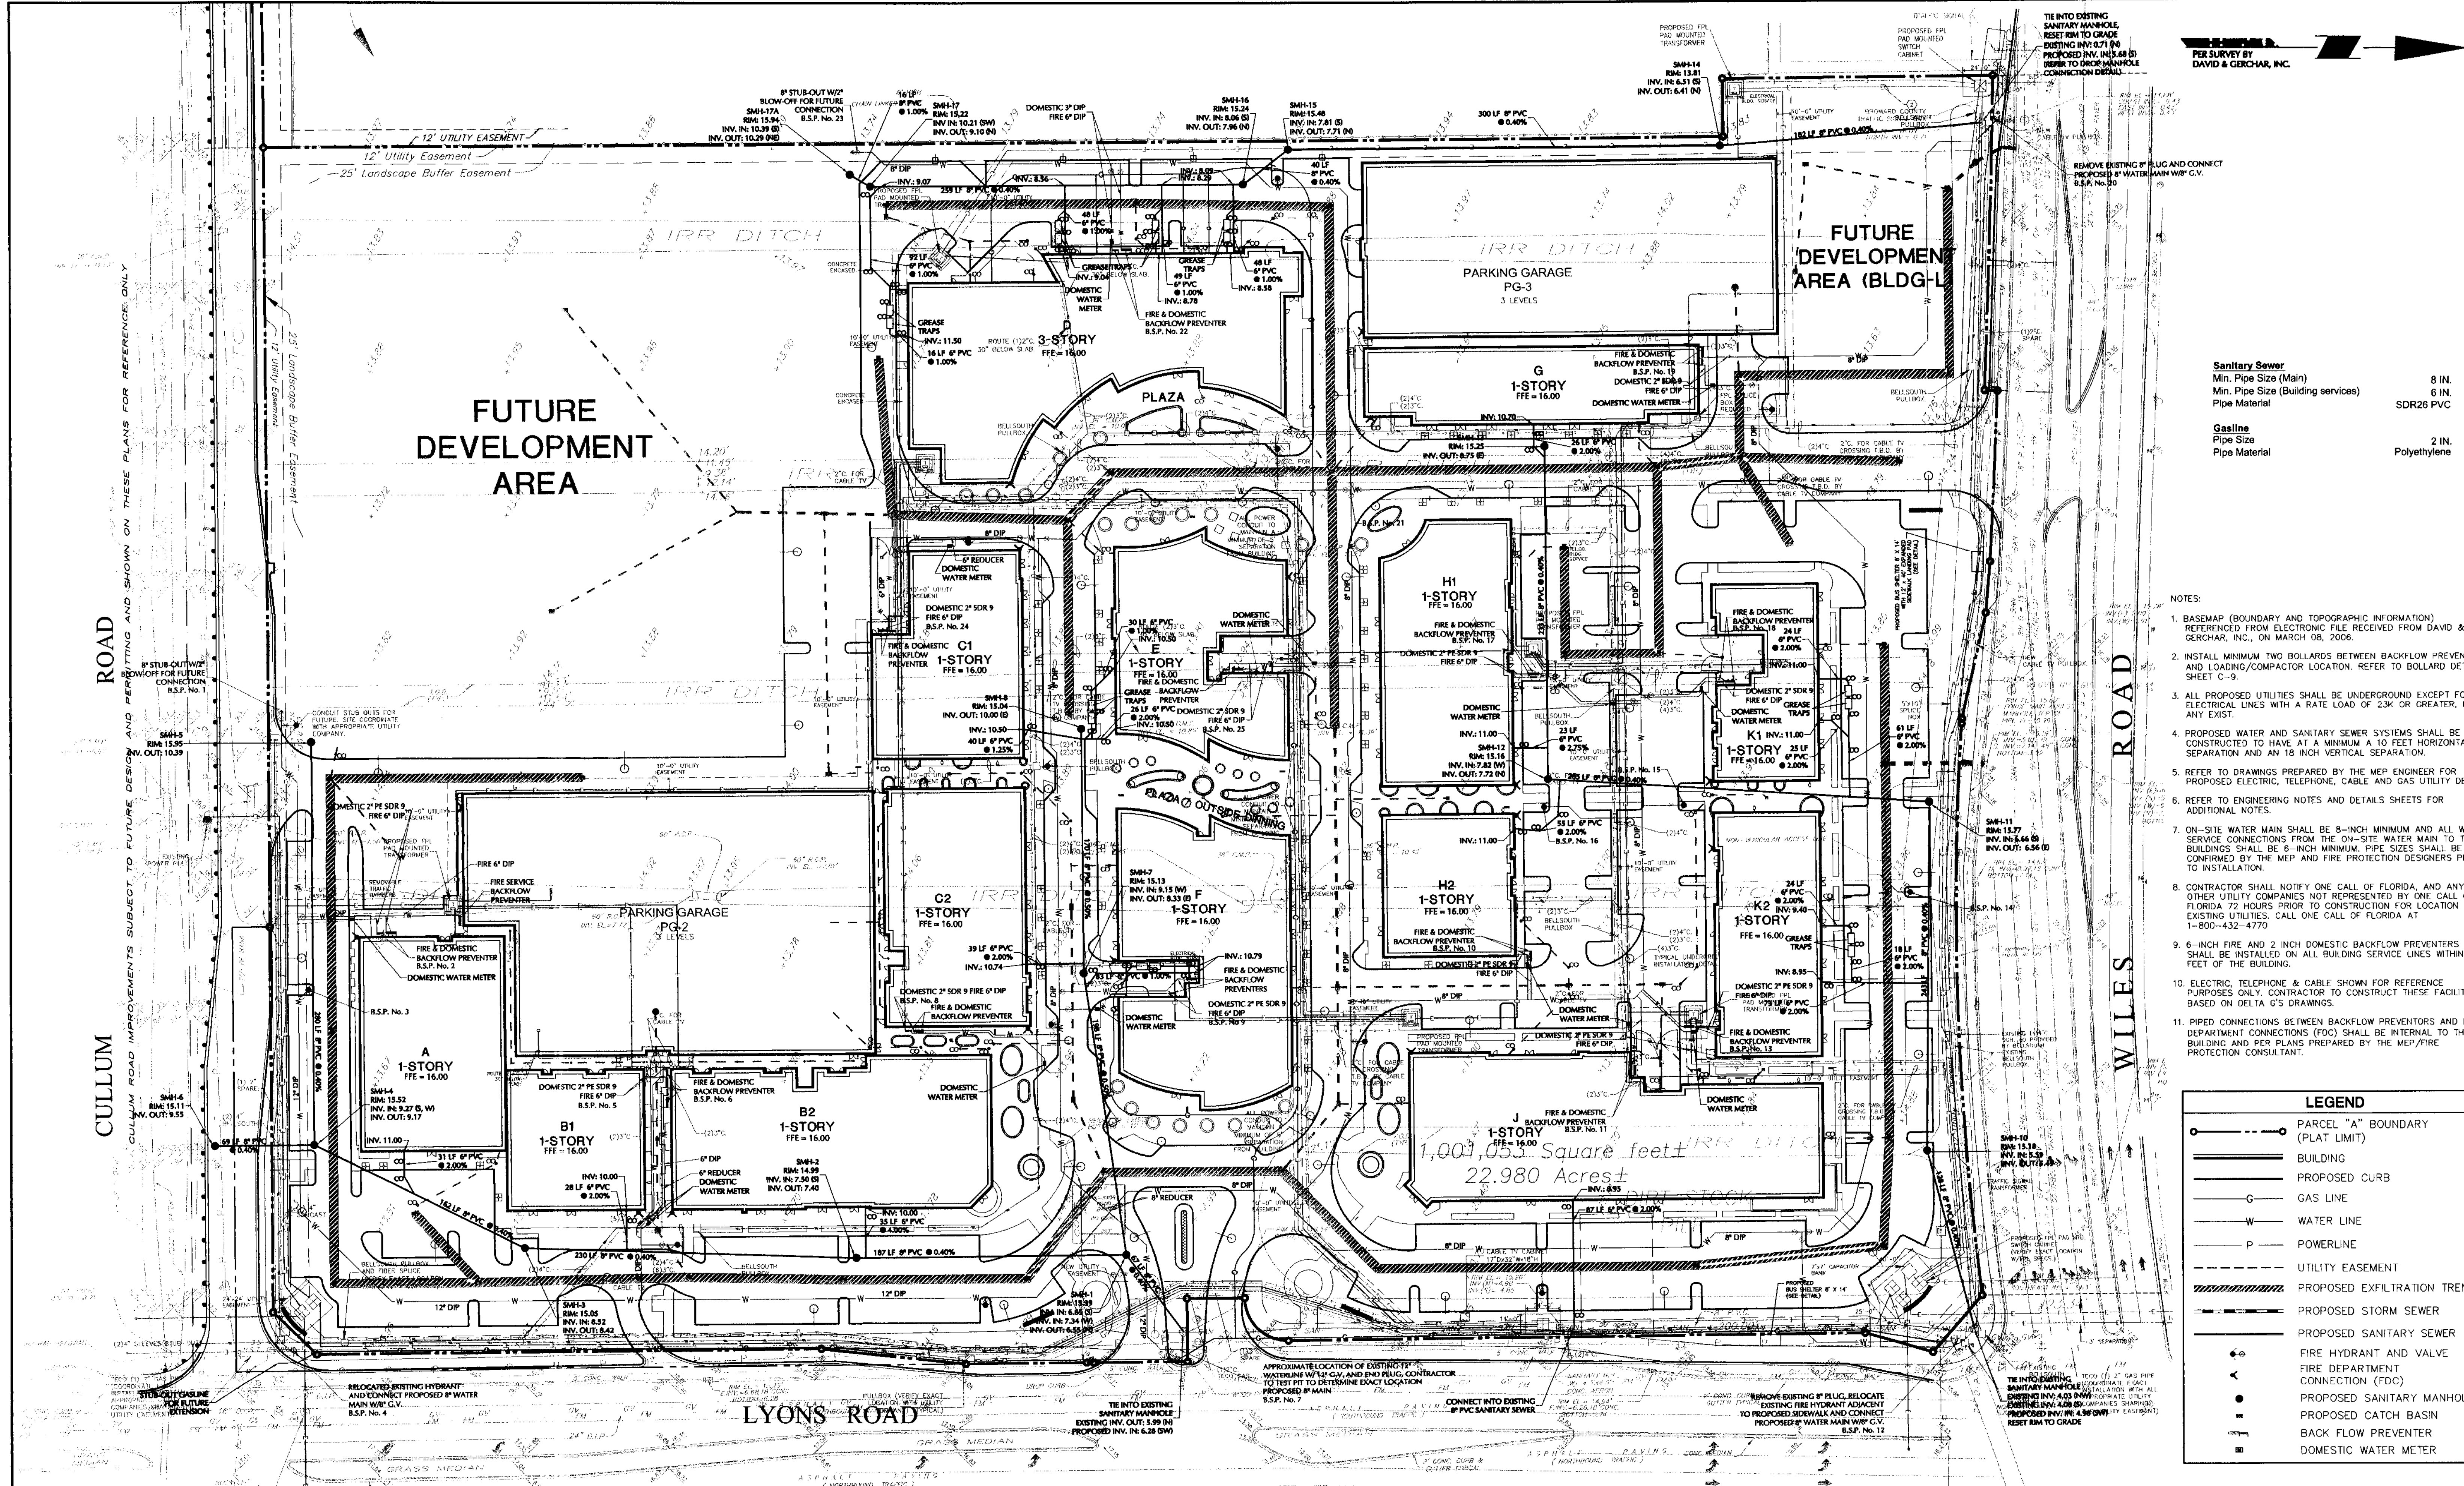

08/15/07

REVISED BASED ON REVIEW COMMENTS AND COORDINATION WITH PROJECT TEAM

6

07/24/07

REVISED PER JULY 16, 2007 EPO REVIEW COMMENTS

5

07/02/07

REMOVED BUILDING L FROM PLAN

4

06/25/07

REVISED FOR ADMINISTRATIVE APPROVAL - MODIFICATION OF SITE PLAN

3

06/05/07

REVISED PER COUNTY EPO - IRO AND CITY REVIEW COMMENTS

2

04/27/07

REVISED PER COORDINATION WITH ARCHITECT

1

Date

Description

No.

Revisions

ERIC B. SCHWARZ, P.E.

PROFESSIONAL ENGINEER FL LIC. No. 62196

LANGAN

ENGINEERING & ENVIRONMENTAL SERVICES

Parkside Corporate Center
15150 NW 79th Court, Suite 200
Miami Lakes, FL 33016
P: 786.264.7200 F: 786.264.7201
www.langan.com

NEW JERSEY PENNSYLVANIA NEW YORK CONNECTICUT FLORIDA NEVADA
FL Certificate of Authorization No. 00009601

Project

**THE PROMENADE AT LYONS
(COCONUT CREEK
DEVELOPMENT, LLC)**
CITY OF COCONUT CREEK

Drawing Title

**SANITARY SEWER
UTILITY PLAN**

Project No.

6110501

Date

APRIL 18, 2007

Scale

1" = 50'

Drn. By

PK

Chkd. By

EB

Drawing No.

C-5B

Of

01

Filename: G:\Data\6110501\Cadd Data - 6110501\DWG\6110501 C-5B.dwg

Date: 8/7/2007

Time: 17:00

User: pkilch

Style Table: Langan_OCE.stb

Layout: D Size Sheet (Bottom)