




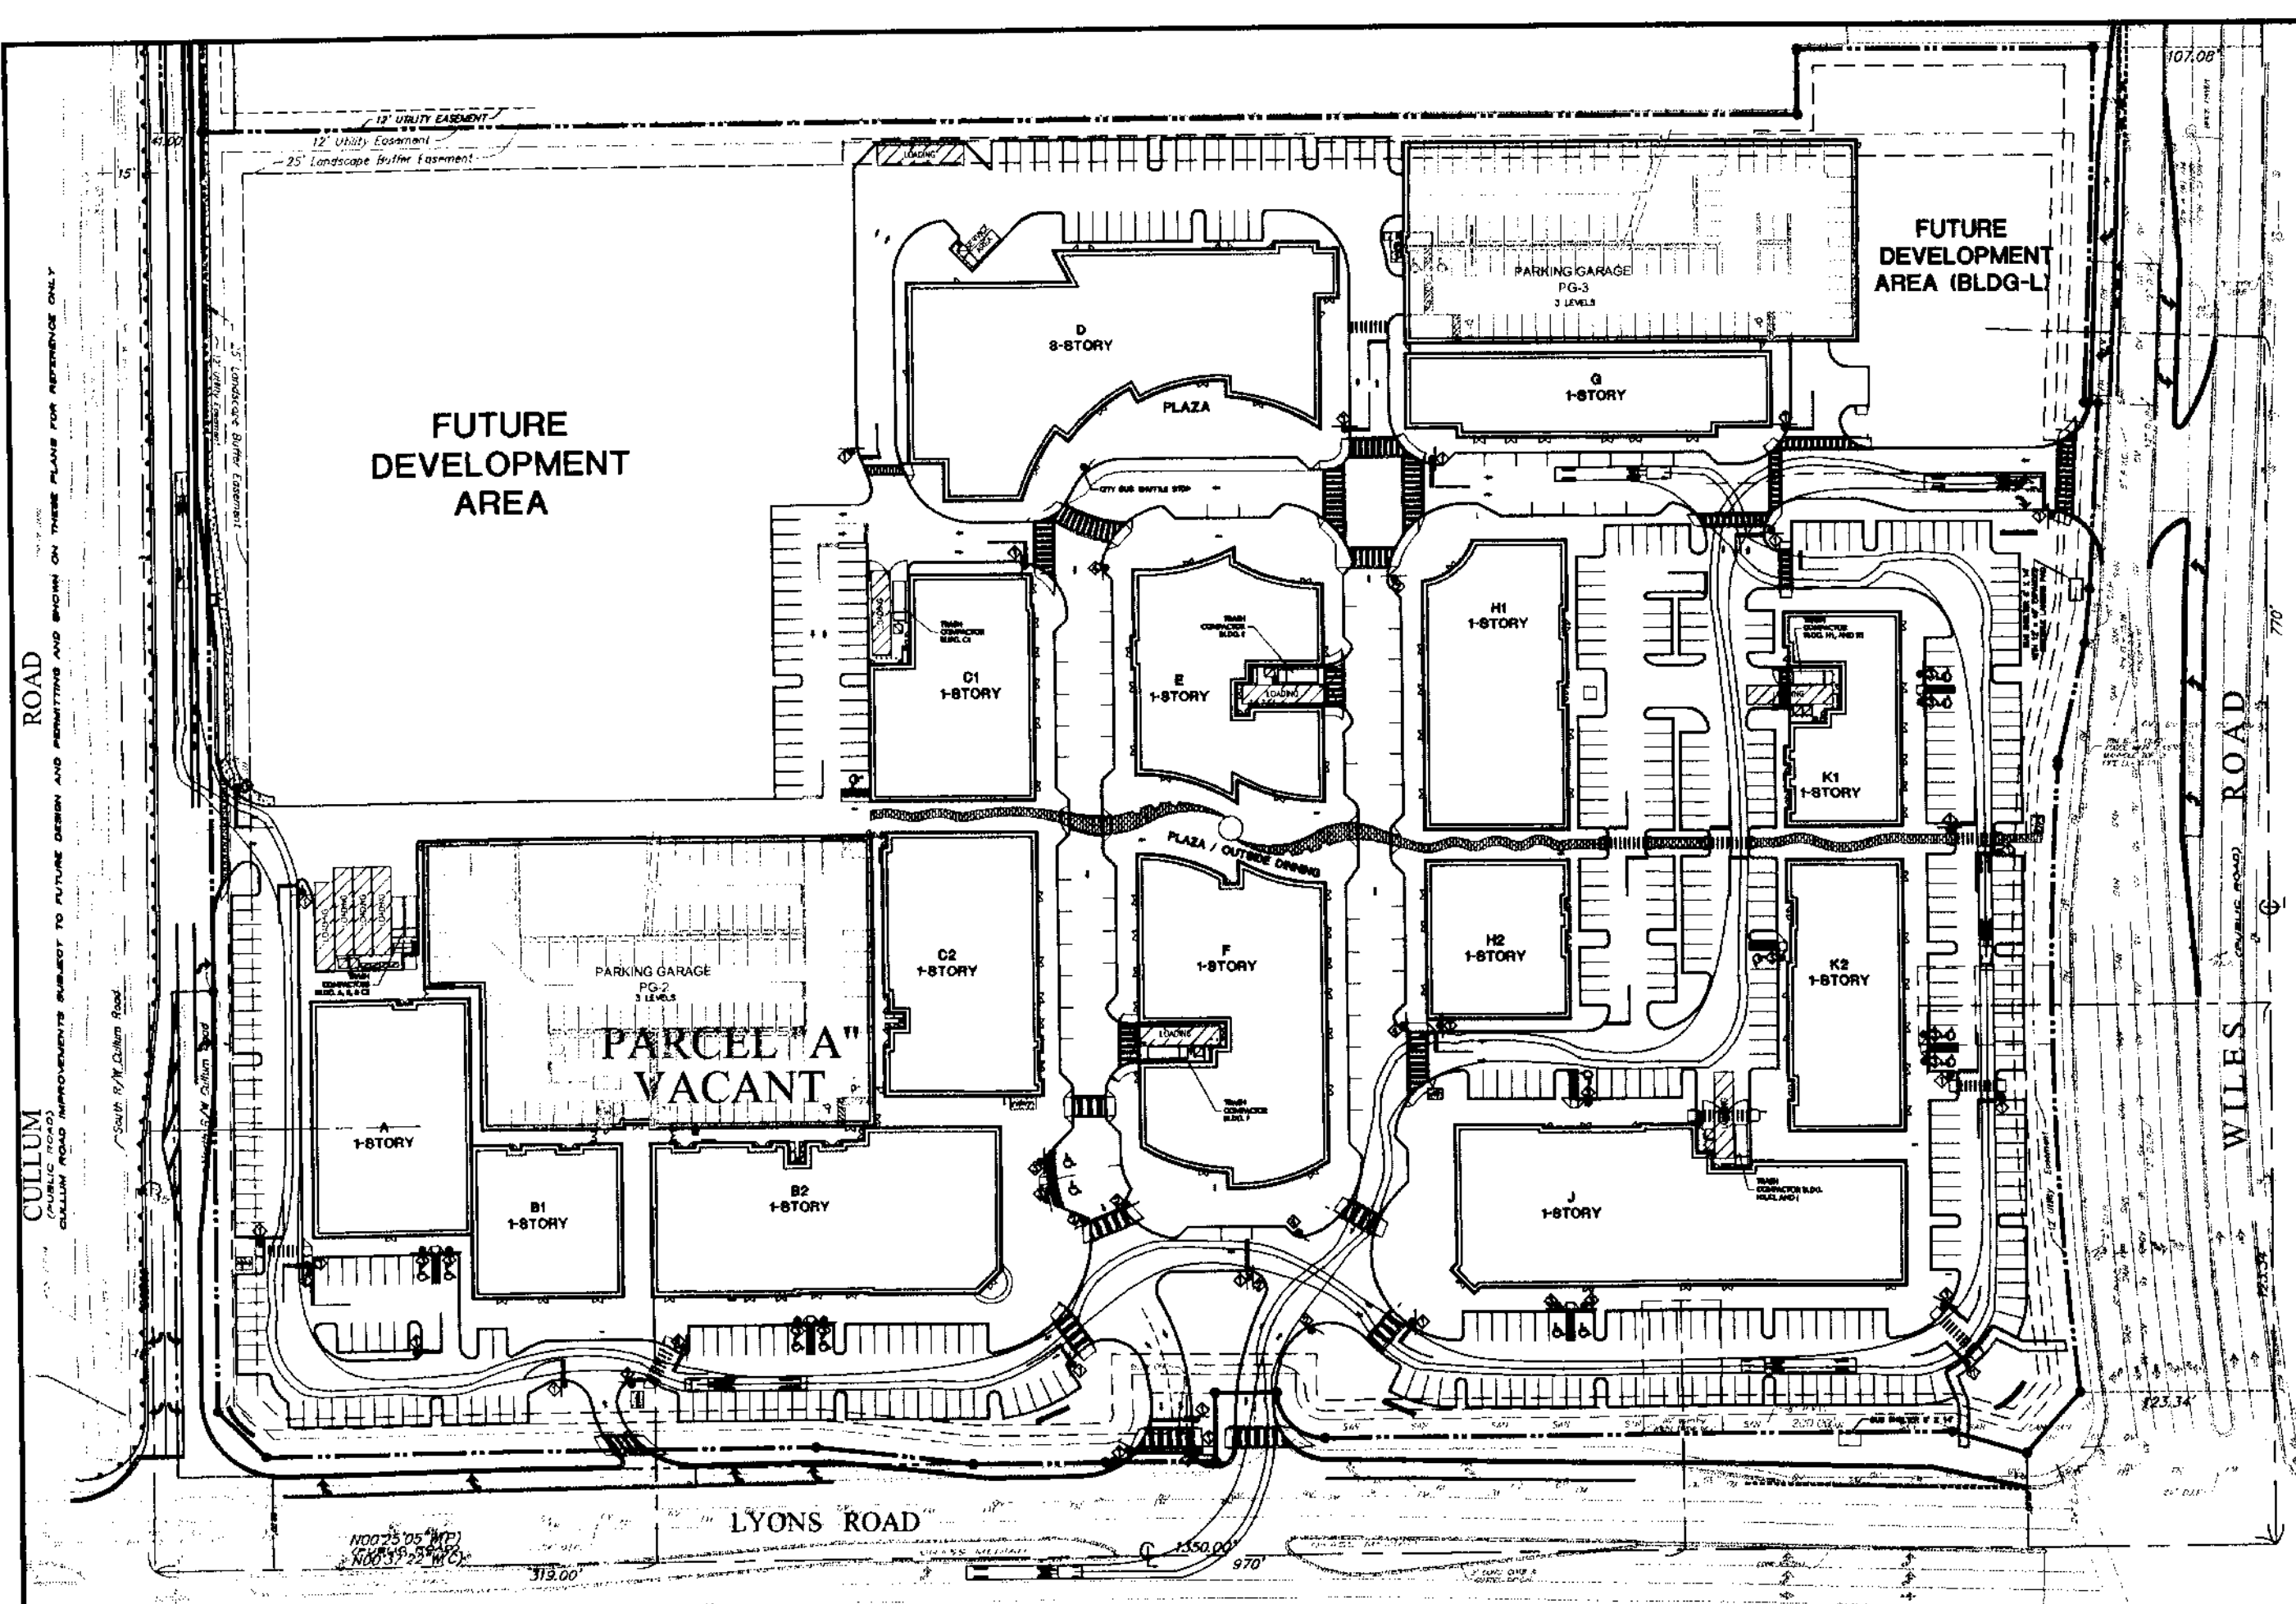


VIEW A FIRE TRUCK

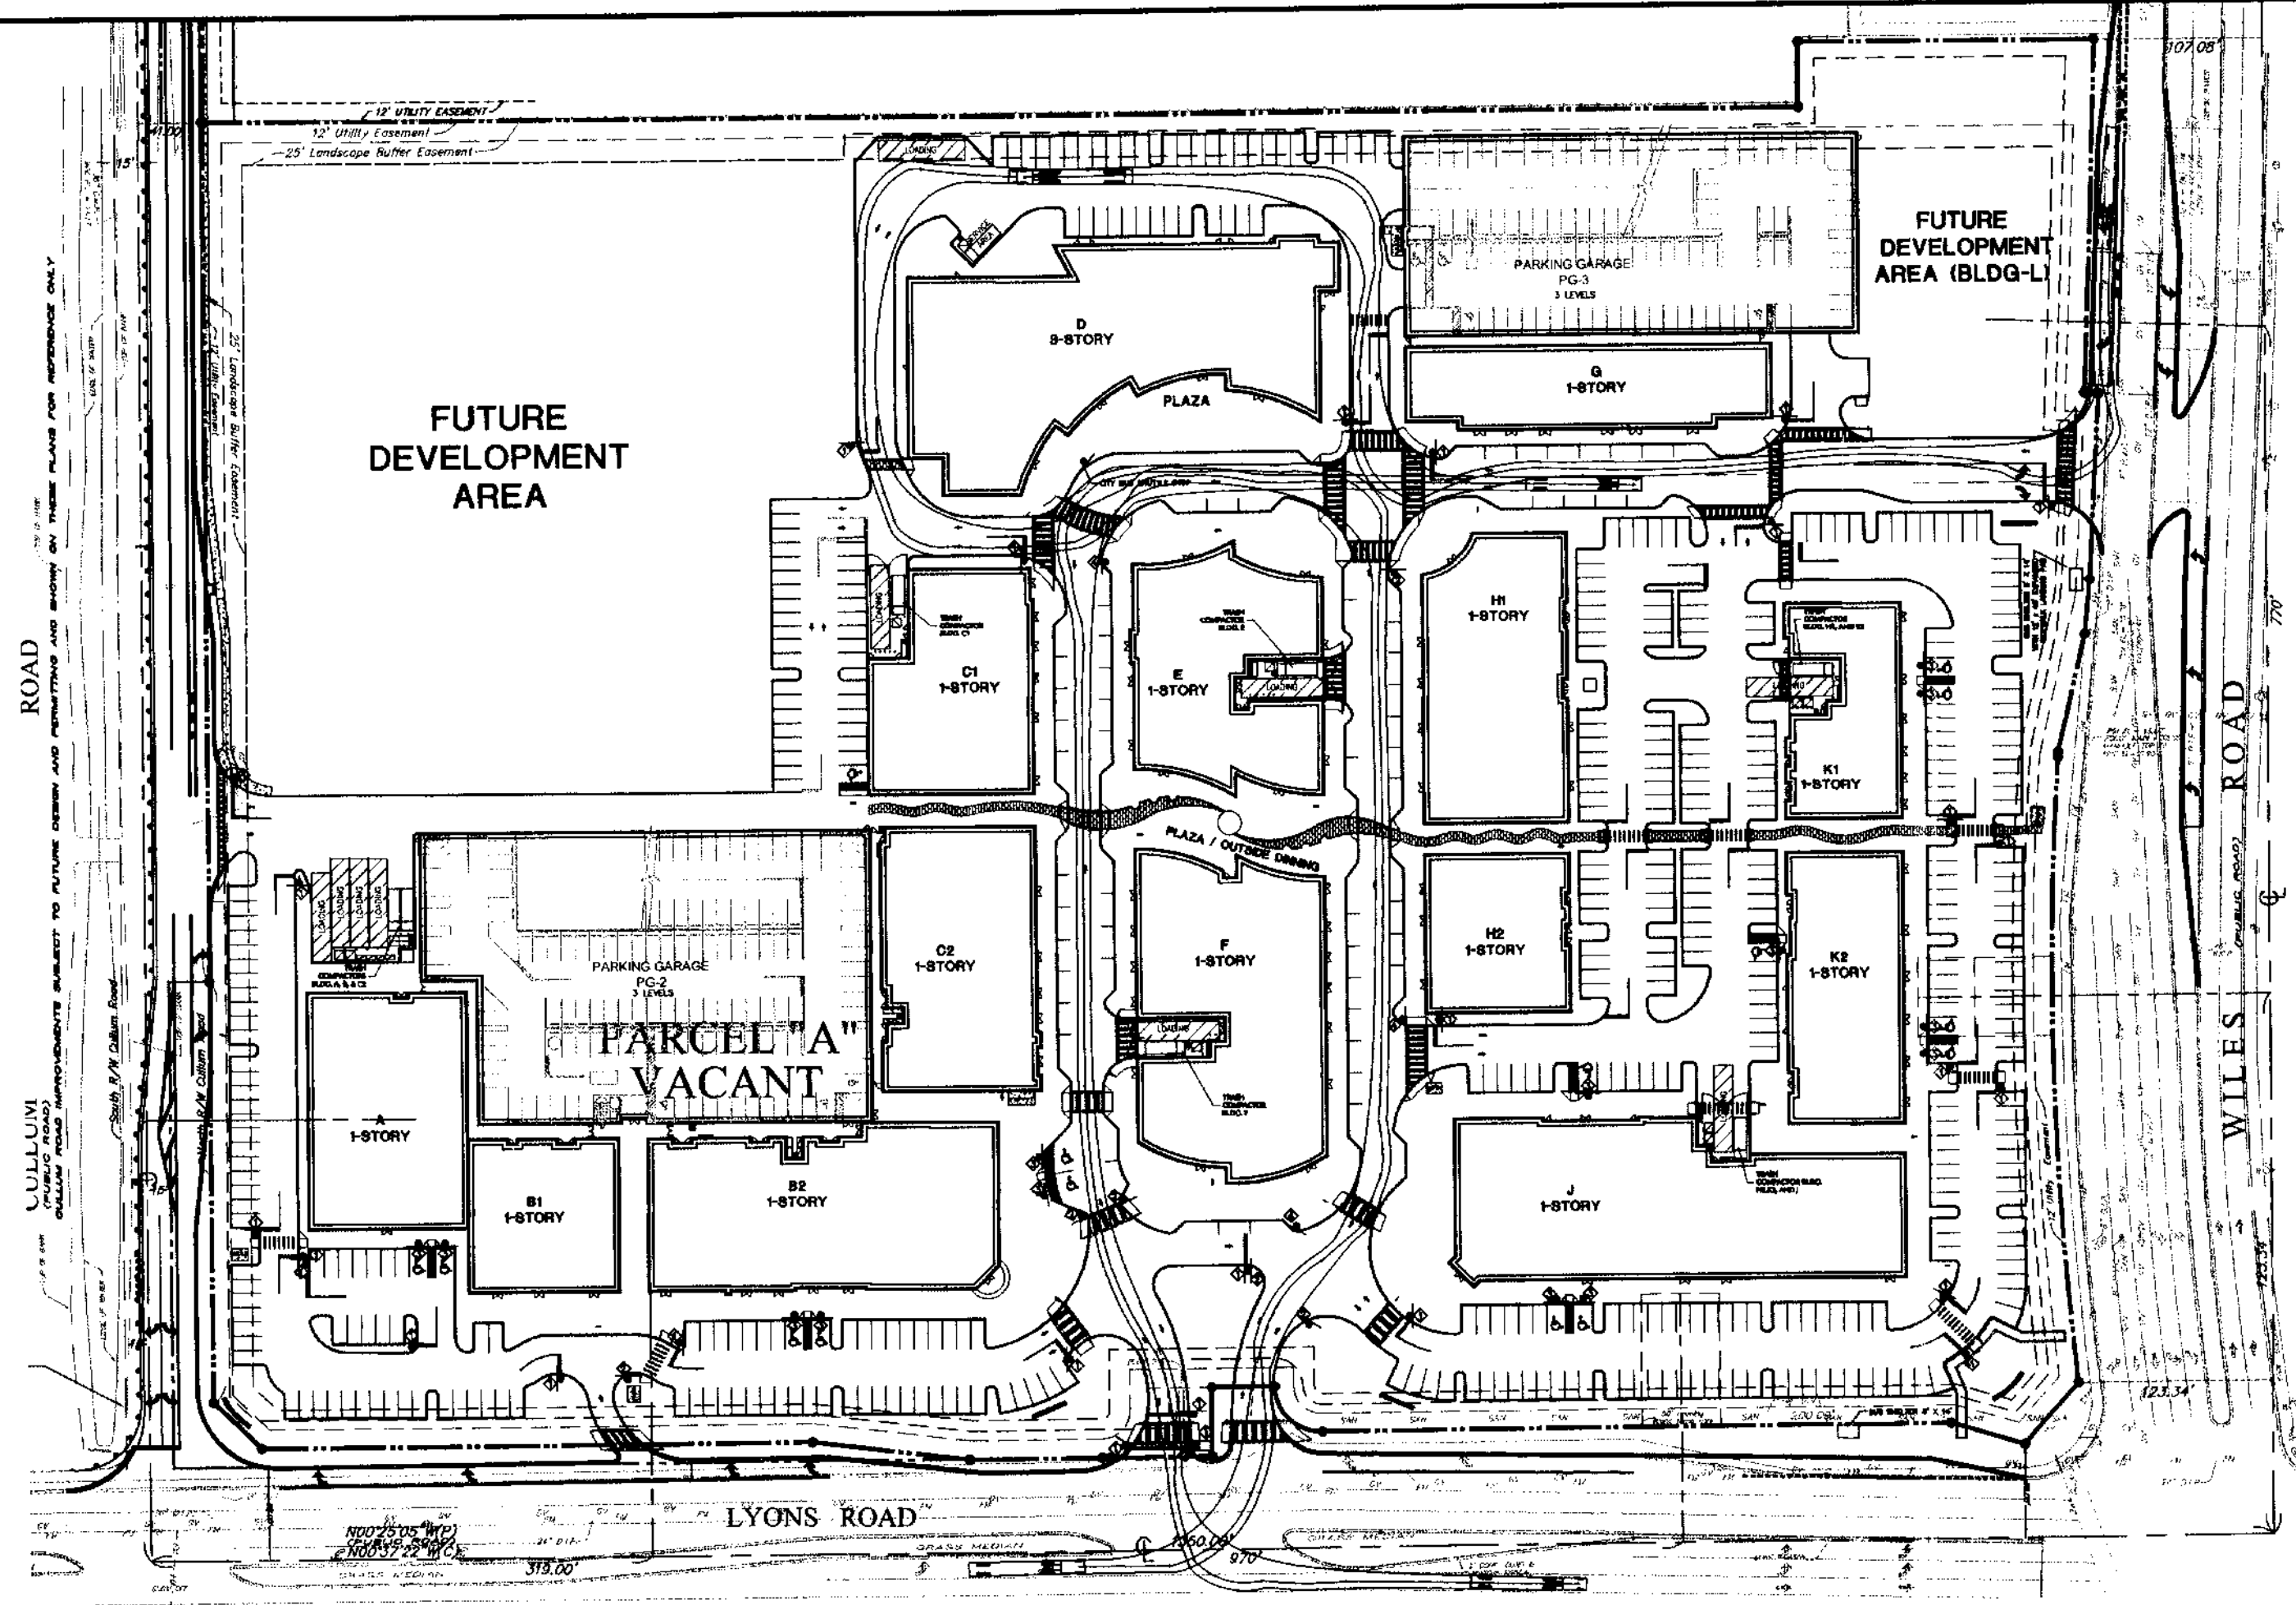


VIEW B FIRE TRUCK

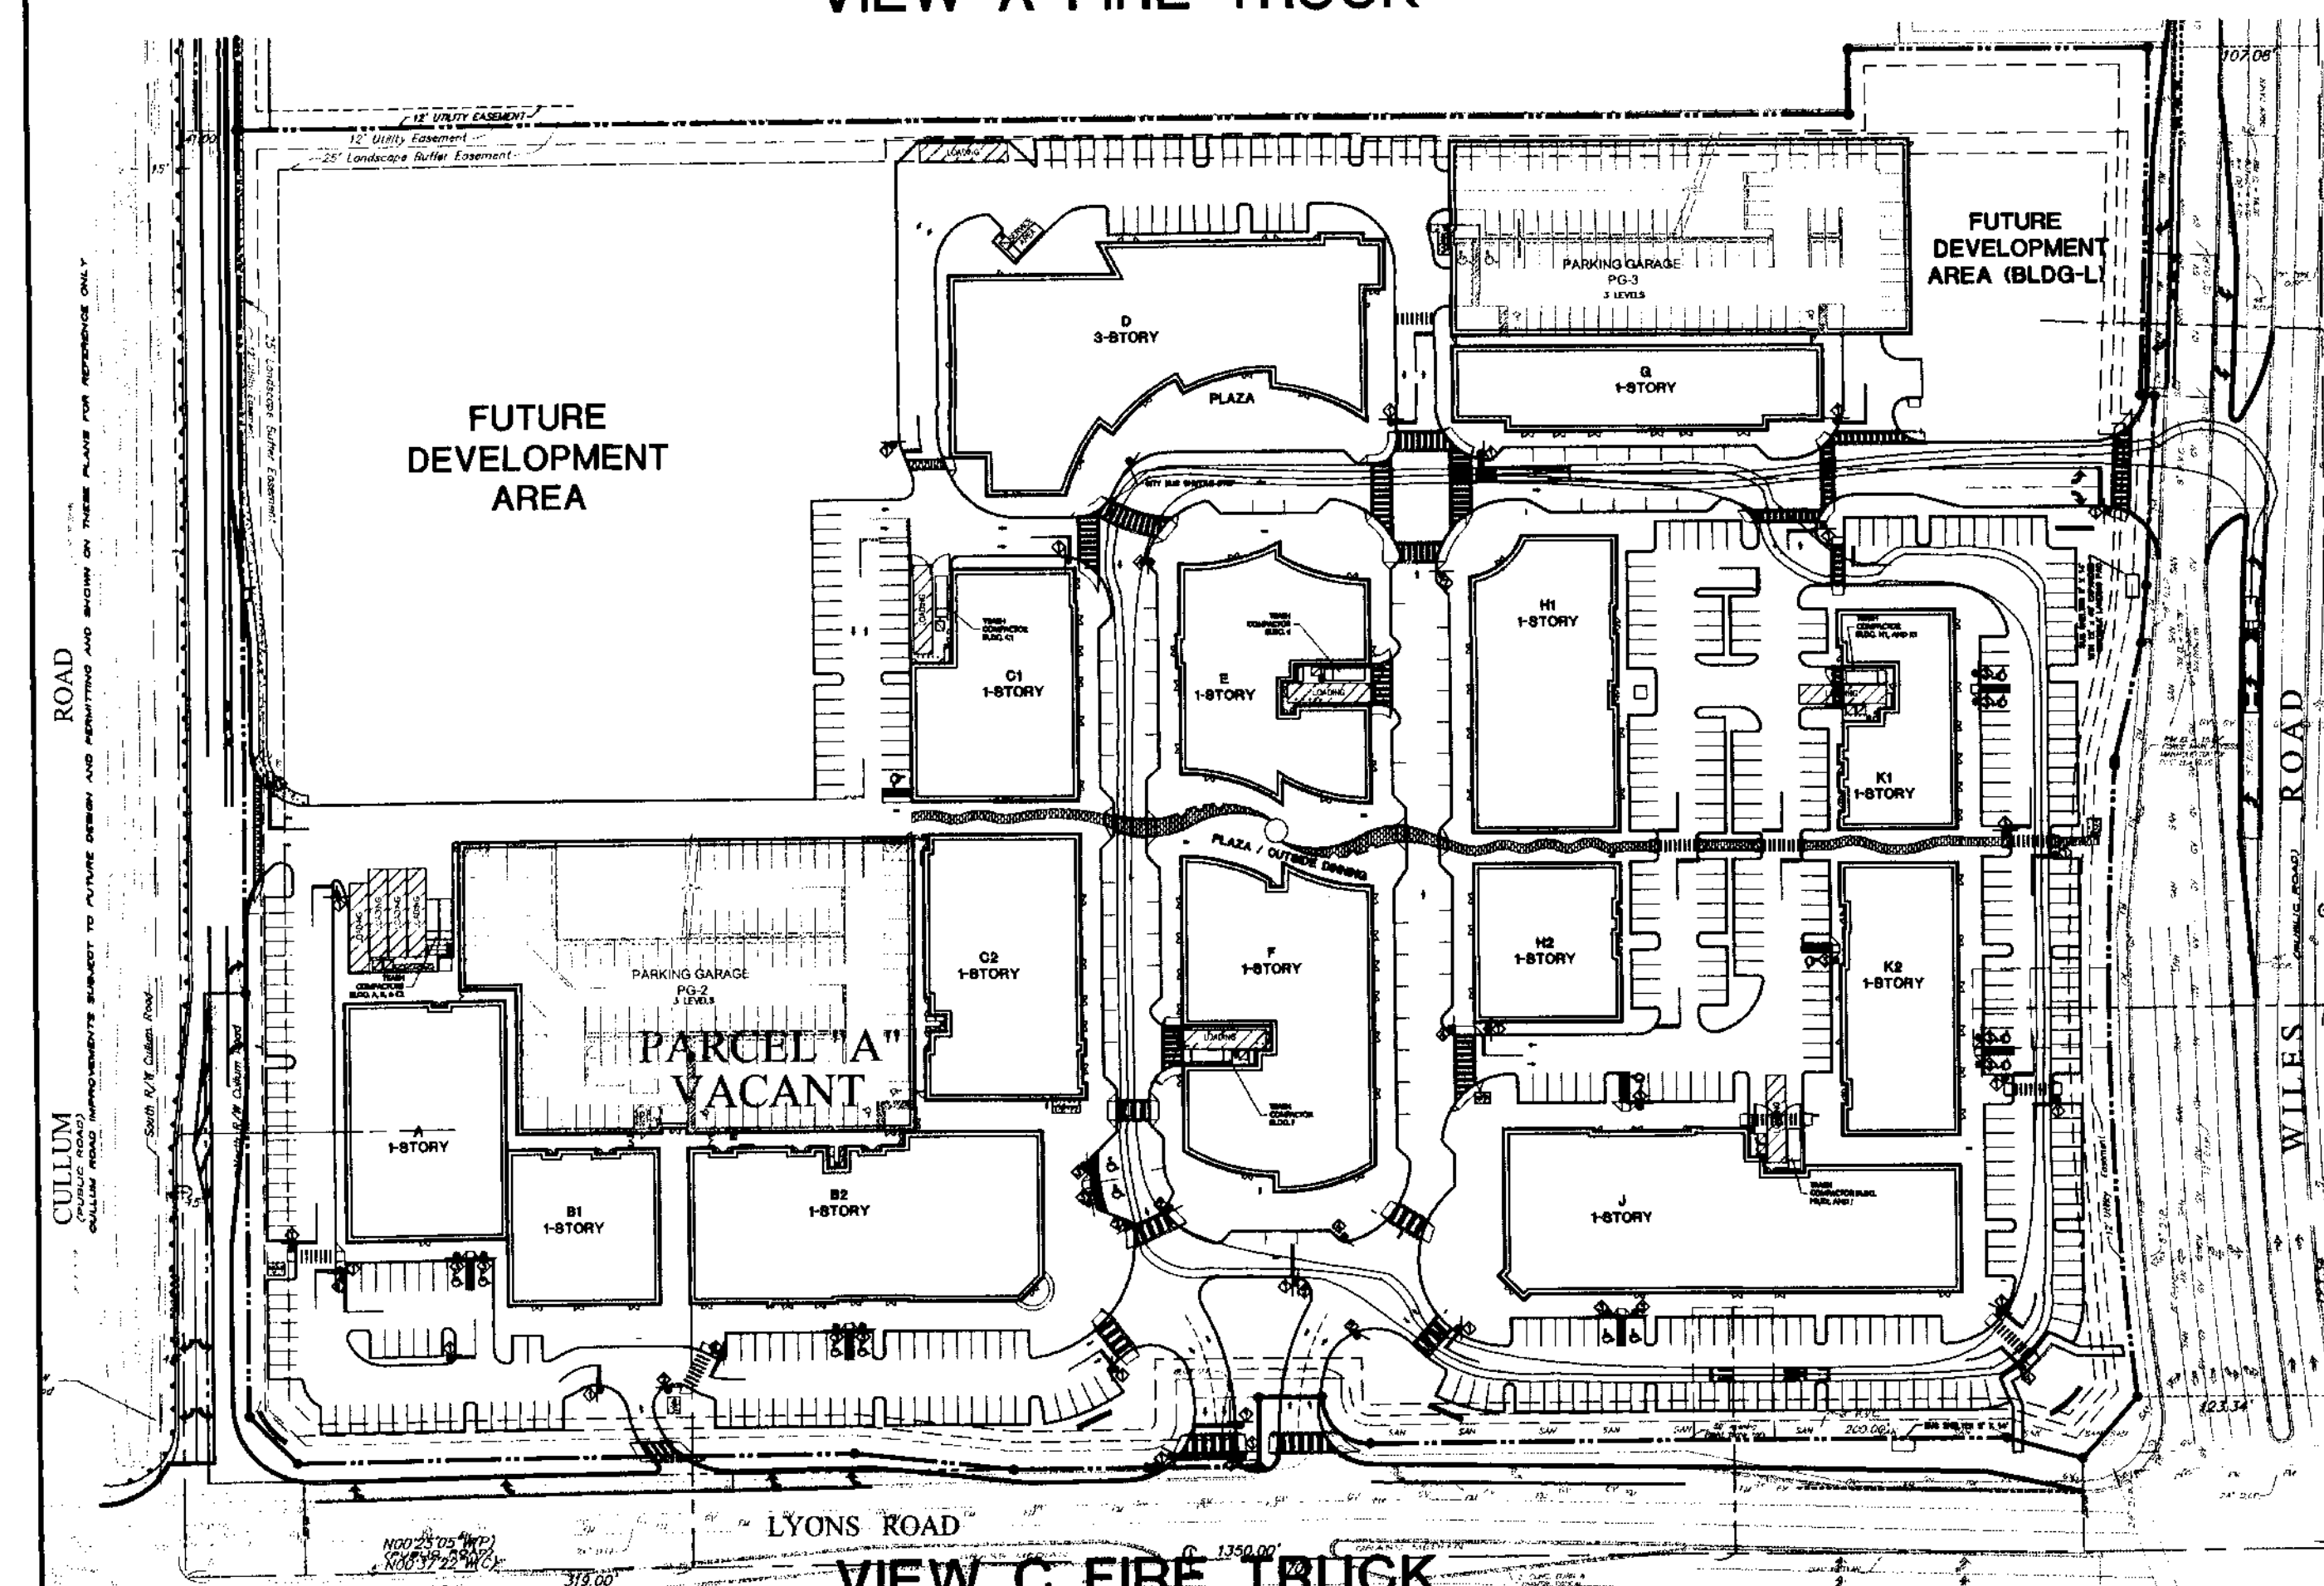

VIEW C FIRE TRUCK

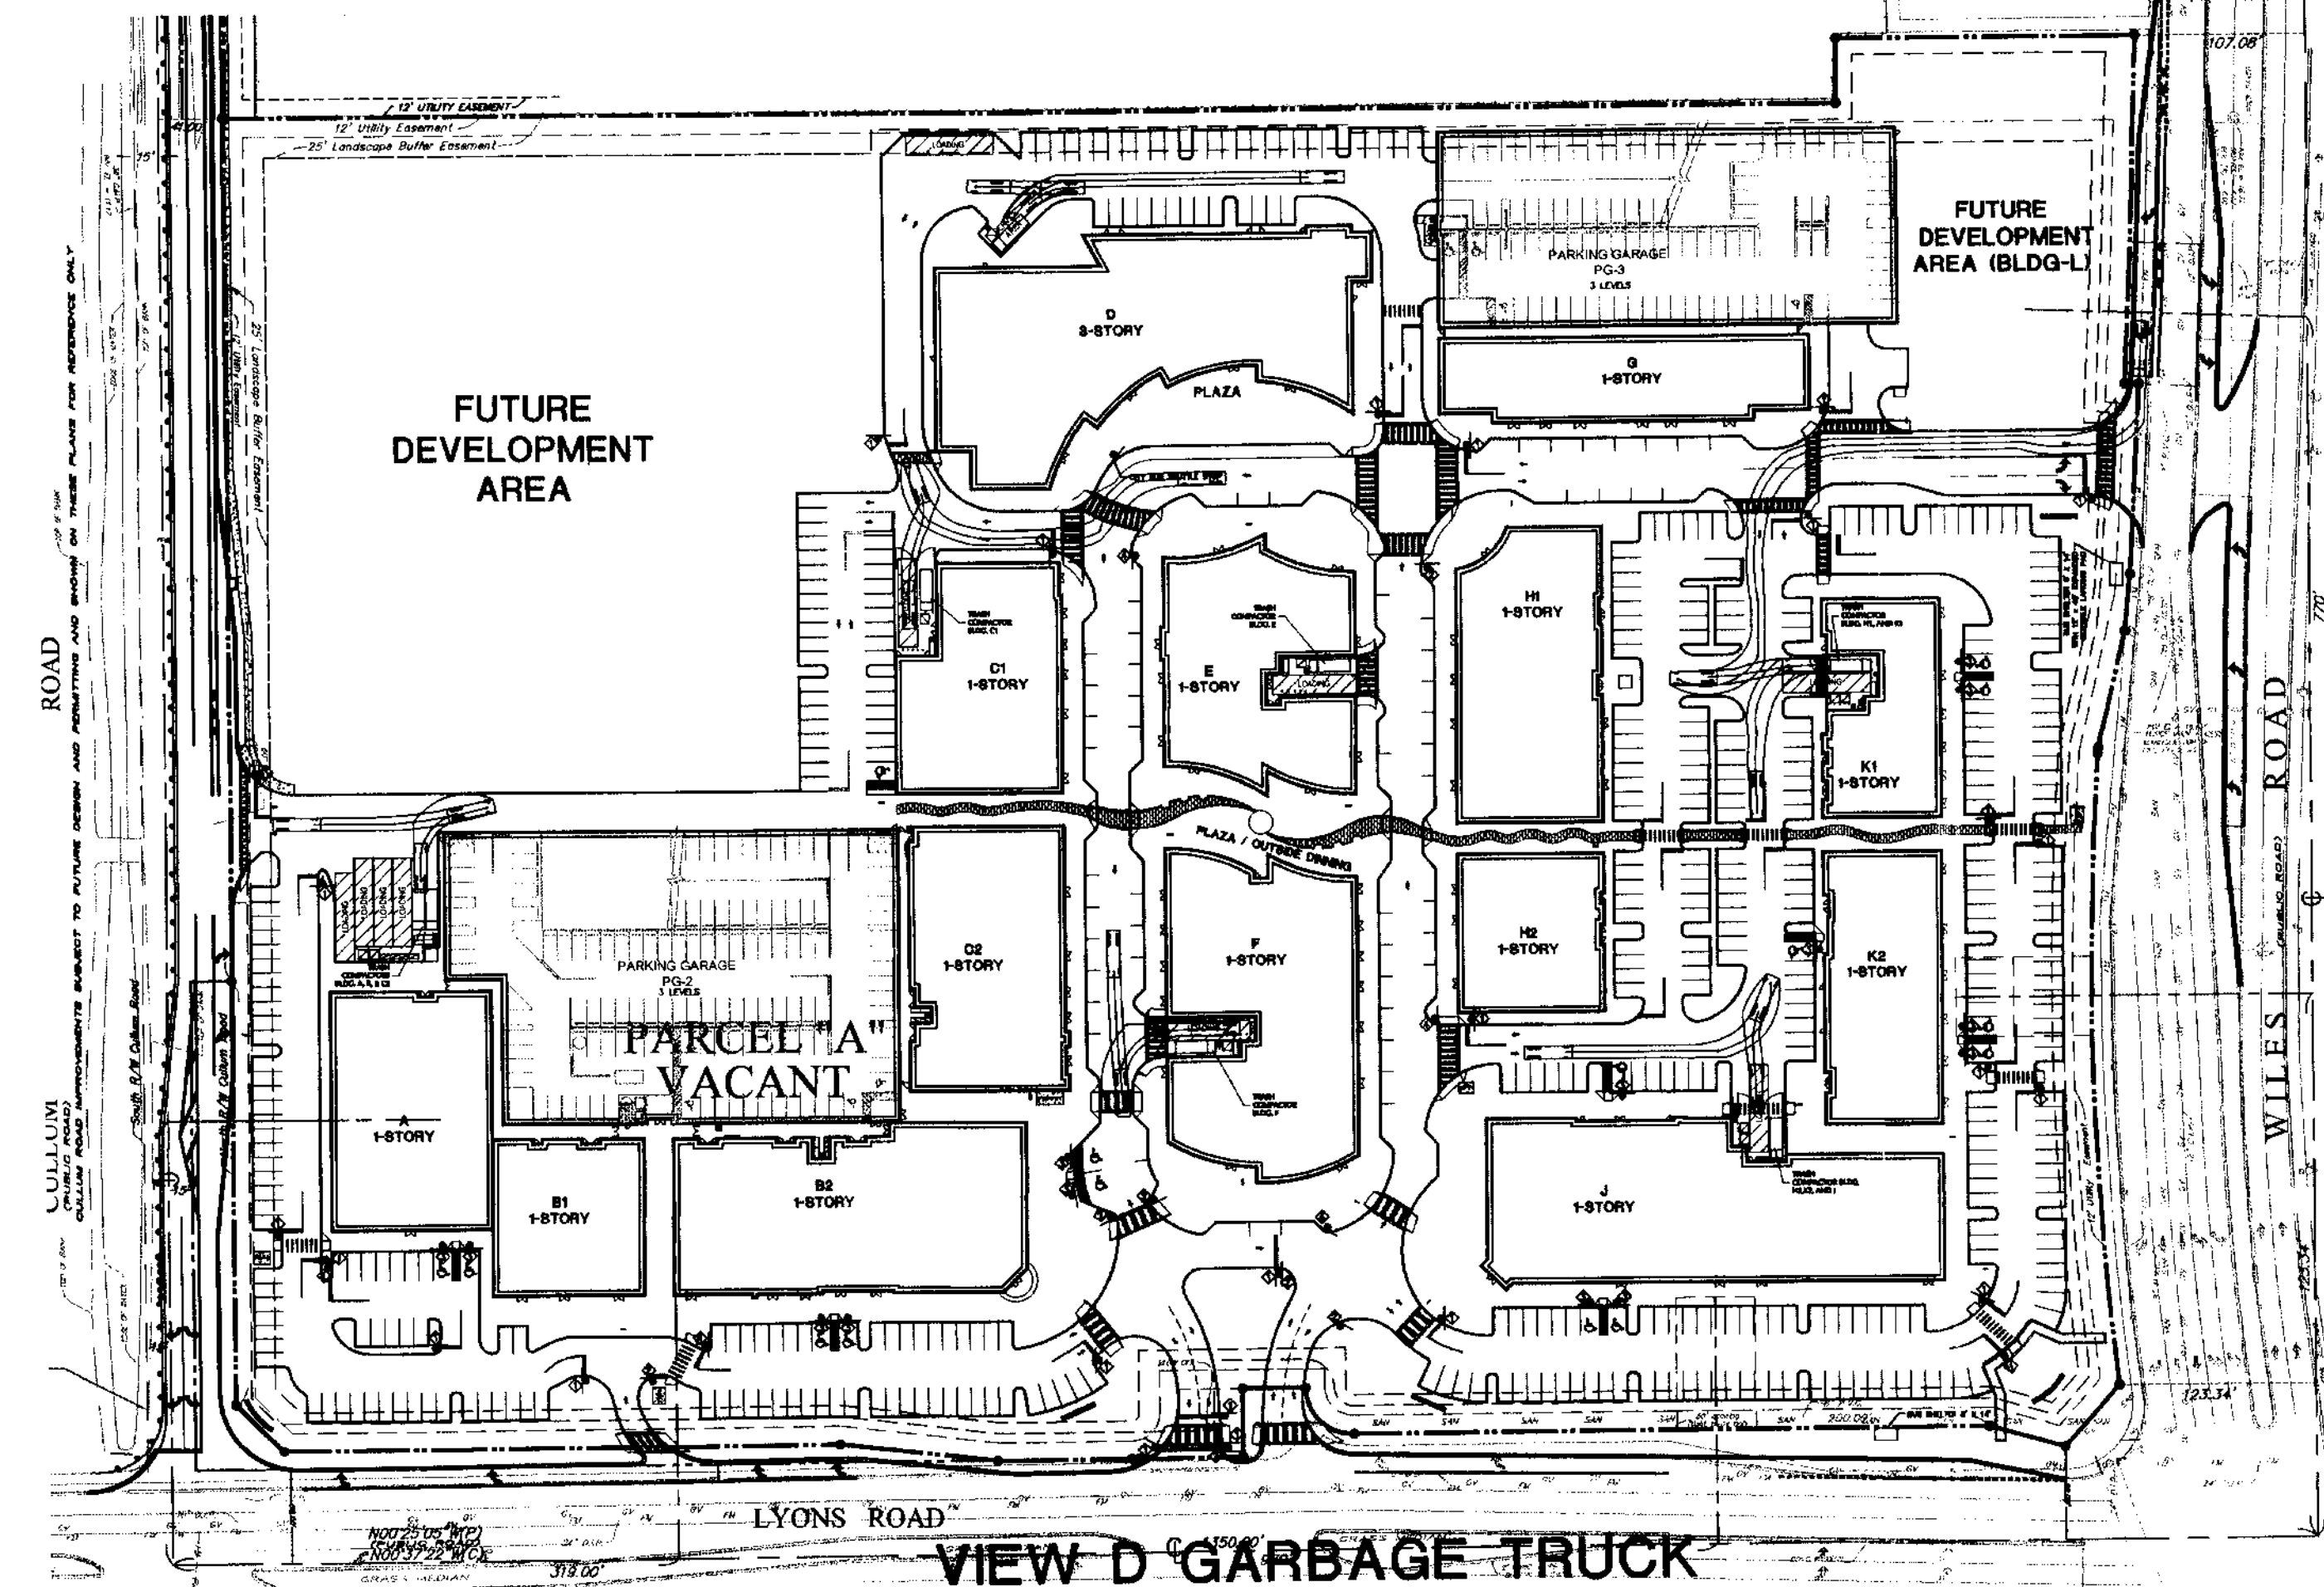


VIEW D GARBAGE TRUCK

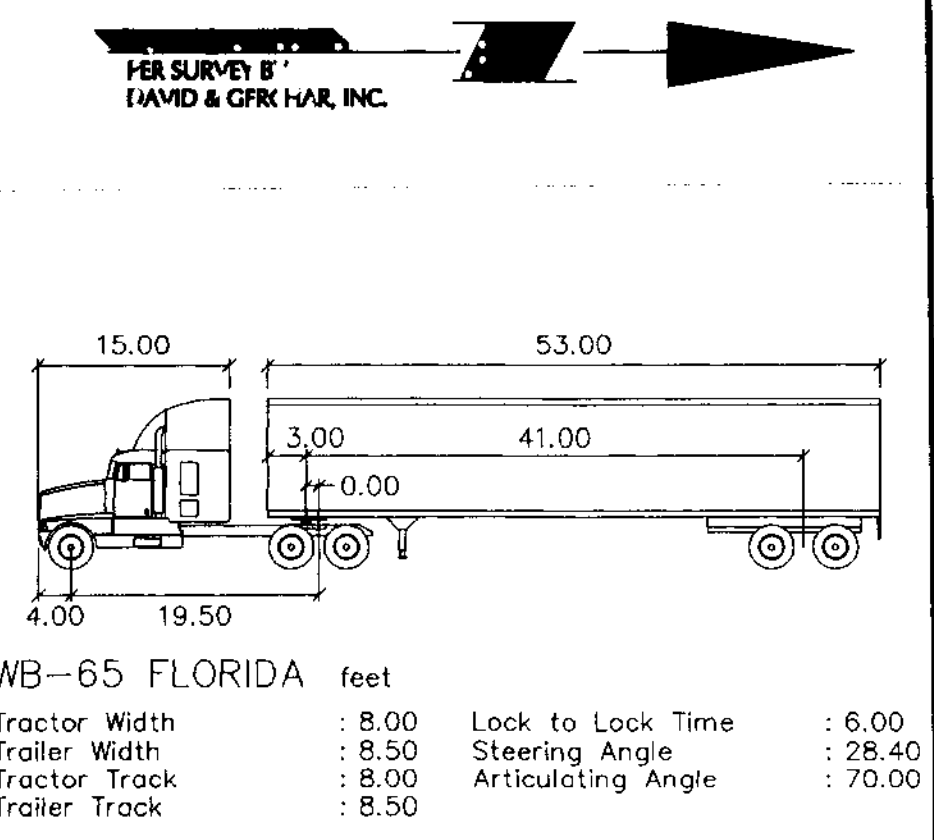


NOTE:
1. MINIMUM CENTERLINE TURNING RADIUS = 50 FEET


**FIRE TRUCK
WB-65 CIRCULATION
NTS**

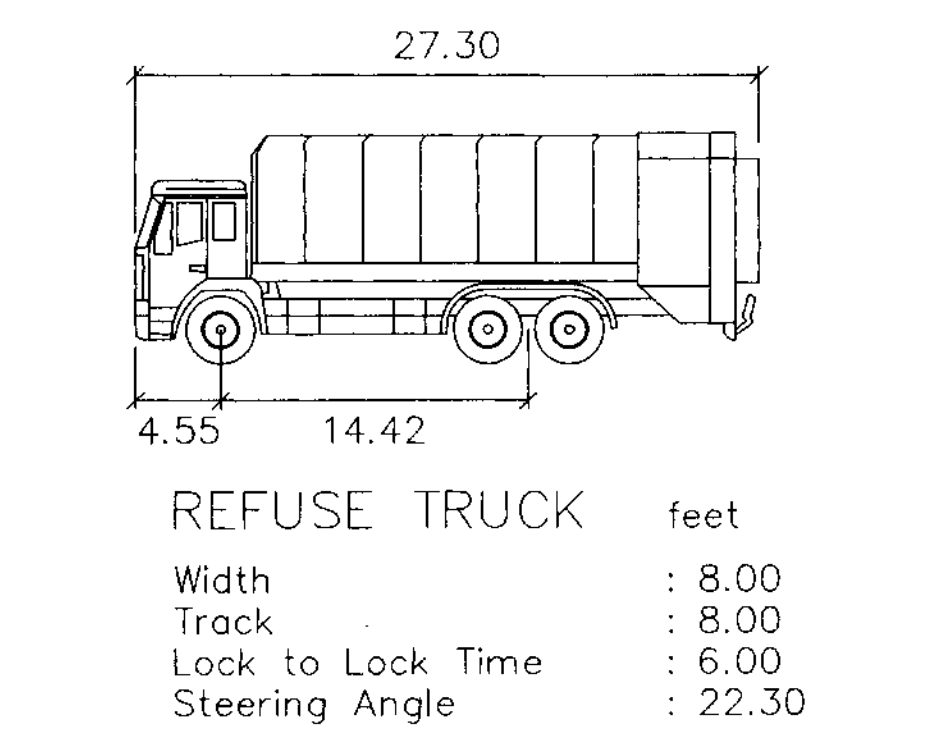

NOTE:
1. MINIMUM CENTERLINE TURNING RADIUS = 38 FEET

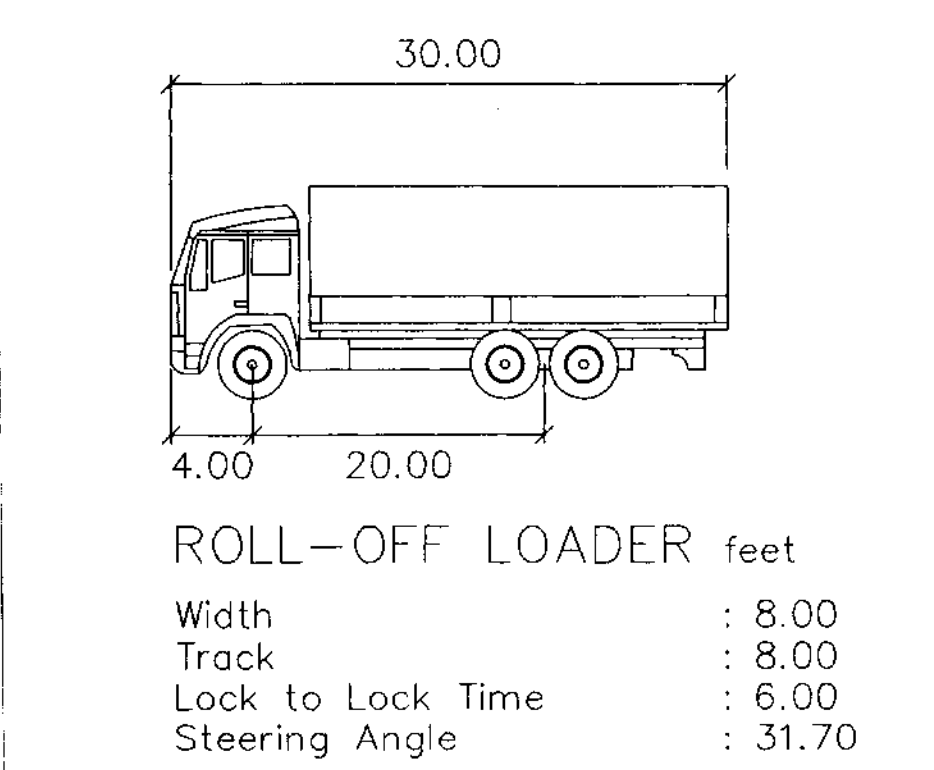

NOTE:
1. MINIMUM CENTERLINE TURNING RADIUS = 38 FEET

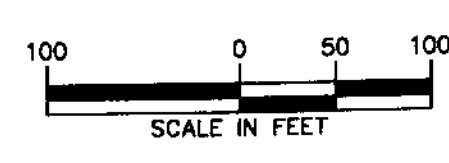

Revisions			Revisions		
Date	Description	No.	Date	Description	No.
08/15/07	REMOVED BUILDING "I" FROM PLAN	11	08/15/07	REVISED TRUCK MOVEMENT AROUND BLDG L AND TRUCK TURNING SPECIFICATIONS	10
			08/25/07	REVISED FOR ADMINISTRATIVE APPROVAL - MODIFICATION OF SITE PLAN	9
			08/06/07	REVISED PER COUNTY EPO-WQ AND CITY REVIEW COMMENTS	8
			04/27/07	REVISED PER COORDINATION WITH ARCHITECT	7
			04/18/07	REVISED BASED ON CITY AND COUNTY COMMENTS	6
			02/16/07	REVISED FOR FINAL ENGINEERING PERMITS AND APPLICATIONS	5
			01/26/07	REVISED FOR FINAL SITE PLAN APPROVAL	4
			12/15/06	REVISED FOR FINAL ENGINEERING PERMITS AND APPLICATIONS	3
			07/05/06	REVISED BASED ON CITY REVIEW DATED MAY 17, 2006	2
			04/26/06	REVISED BASED ON CITY REVIEW DATED APRIL 13, 2006	1

ERIC B. SCHWARZ, P.E.
PROFESSIONAL ENGINEER FL LIC. No. 62196

LANGAN
ENGINEERING & ENVIRONMENTAL SERVICES
Parkside Corporate Center
15150 NW 79th Court, Suite 200
Miami Lakes, FL 33016
P: 786.264.7200 F: 786.264.7201
www.langan.com
NEW JERSEY PENNSYLVANIA NEW YORK CONNECTICUT FLORIDA VIRGINIA
FL Certificate of Authorization No: 00008601

Project
**THE PROMENADE AT LYONS
(COCONUT CREEK
DEVELOPMENT, LLC)
CITY OF COCONUT CREEK**

Drawing Title
**TRUCK TURNING
PLAN**

Project No. 6110501	Drawing No. C-6
Date MARCH 27, 2006	
Scale 1" = 100'	
Drn. By TMR	
Chkd. By EBB	Of