


NOTE:
ARCHITECTURAL ALLIANCE
8125 N. FOURTH AVENUE, FORT LAUDERDALE, FLORIDA 33315
TEL: (954) 784-8858 FAX: (954) 784-0731 E-MAIL: landscape@archall.net

OVERALL LA LIGHTING PLAN
SCALE: 1" = 40'-0"

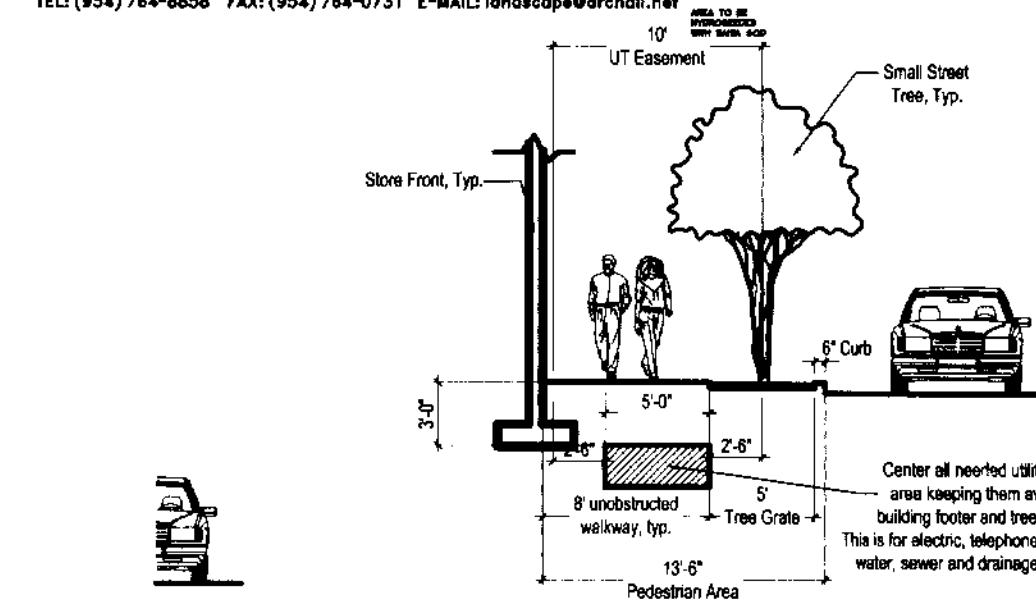


OO1 SECTION OF TREE TO BUILDING IN RELATION TO UNDERGROUND UTILITIES. TYP.

8/14/08 N.T.S.


LIGHTING FIXTURE SCHEDULE FOR ENTIRE SITE									
SYMBOL	TYPE	MANUFACTURER	MODEL / COLOR	LAMPS QTY	TYPE	VOLTS	REMARKS		
▲	UP-LIGHT	VISTA	1065 / Black	106	R30, PAR30 T50	120	Mounting stakes as needed, T50P-B0		
▲	UP-LIGHT	VISTA	1065 / Black	16	AIR, LED T50	120	Mount to Coconut Palm in MCS-B0 Black-36"		
●	PATH LIGHT	VISTA	D11 / Black	103	R30, PAR30 35-42W	120			
■	STEP LIGHT	VISTA	2146 / Copper	66	T3 (x2) LED 20W (x2)	120			
●	BOLLARD	VISTA	M3 / Black	101	ED T1 T50	120			
FOR FOUNTAIN LIGHTS SEE FOUNTAIN DRAWINGS SHEETS LC-14 THROUGH LC-17									
●	COLUMN LIGHT	BEACON	AL0338/AC/18"X42" D FOUNTAIN	2	T50	120			

PERIMETER OF FUTURE DEVELOPMENTS
HYDROSEEDED SOD AREA, TYPICAL.

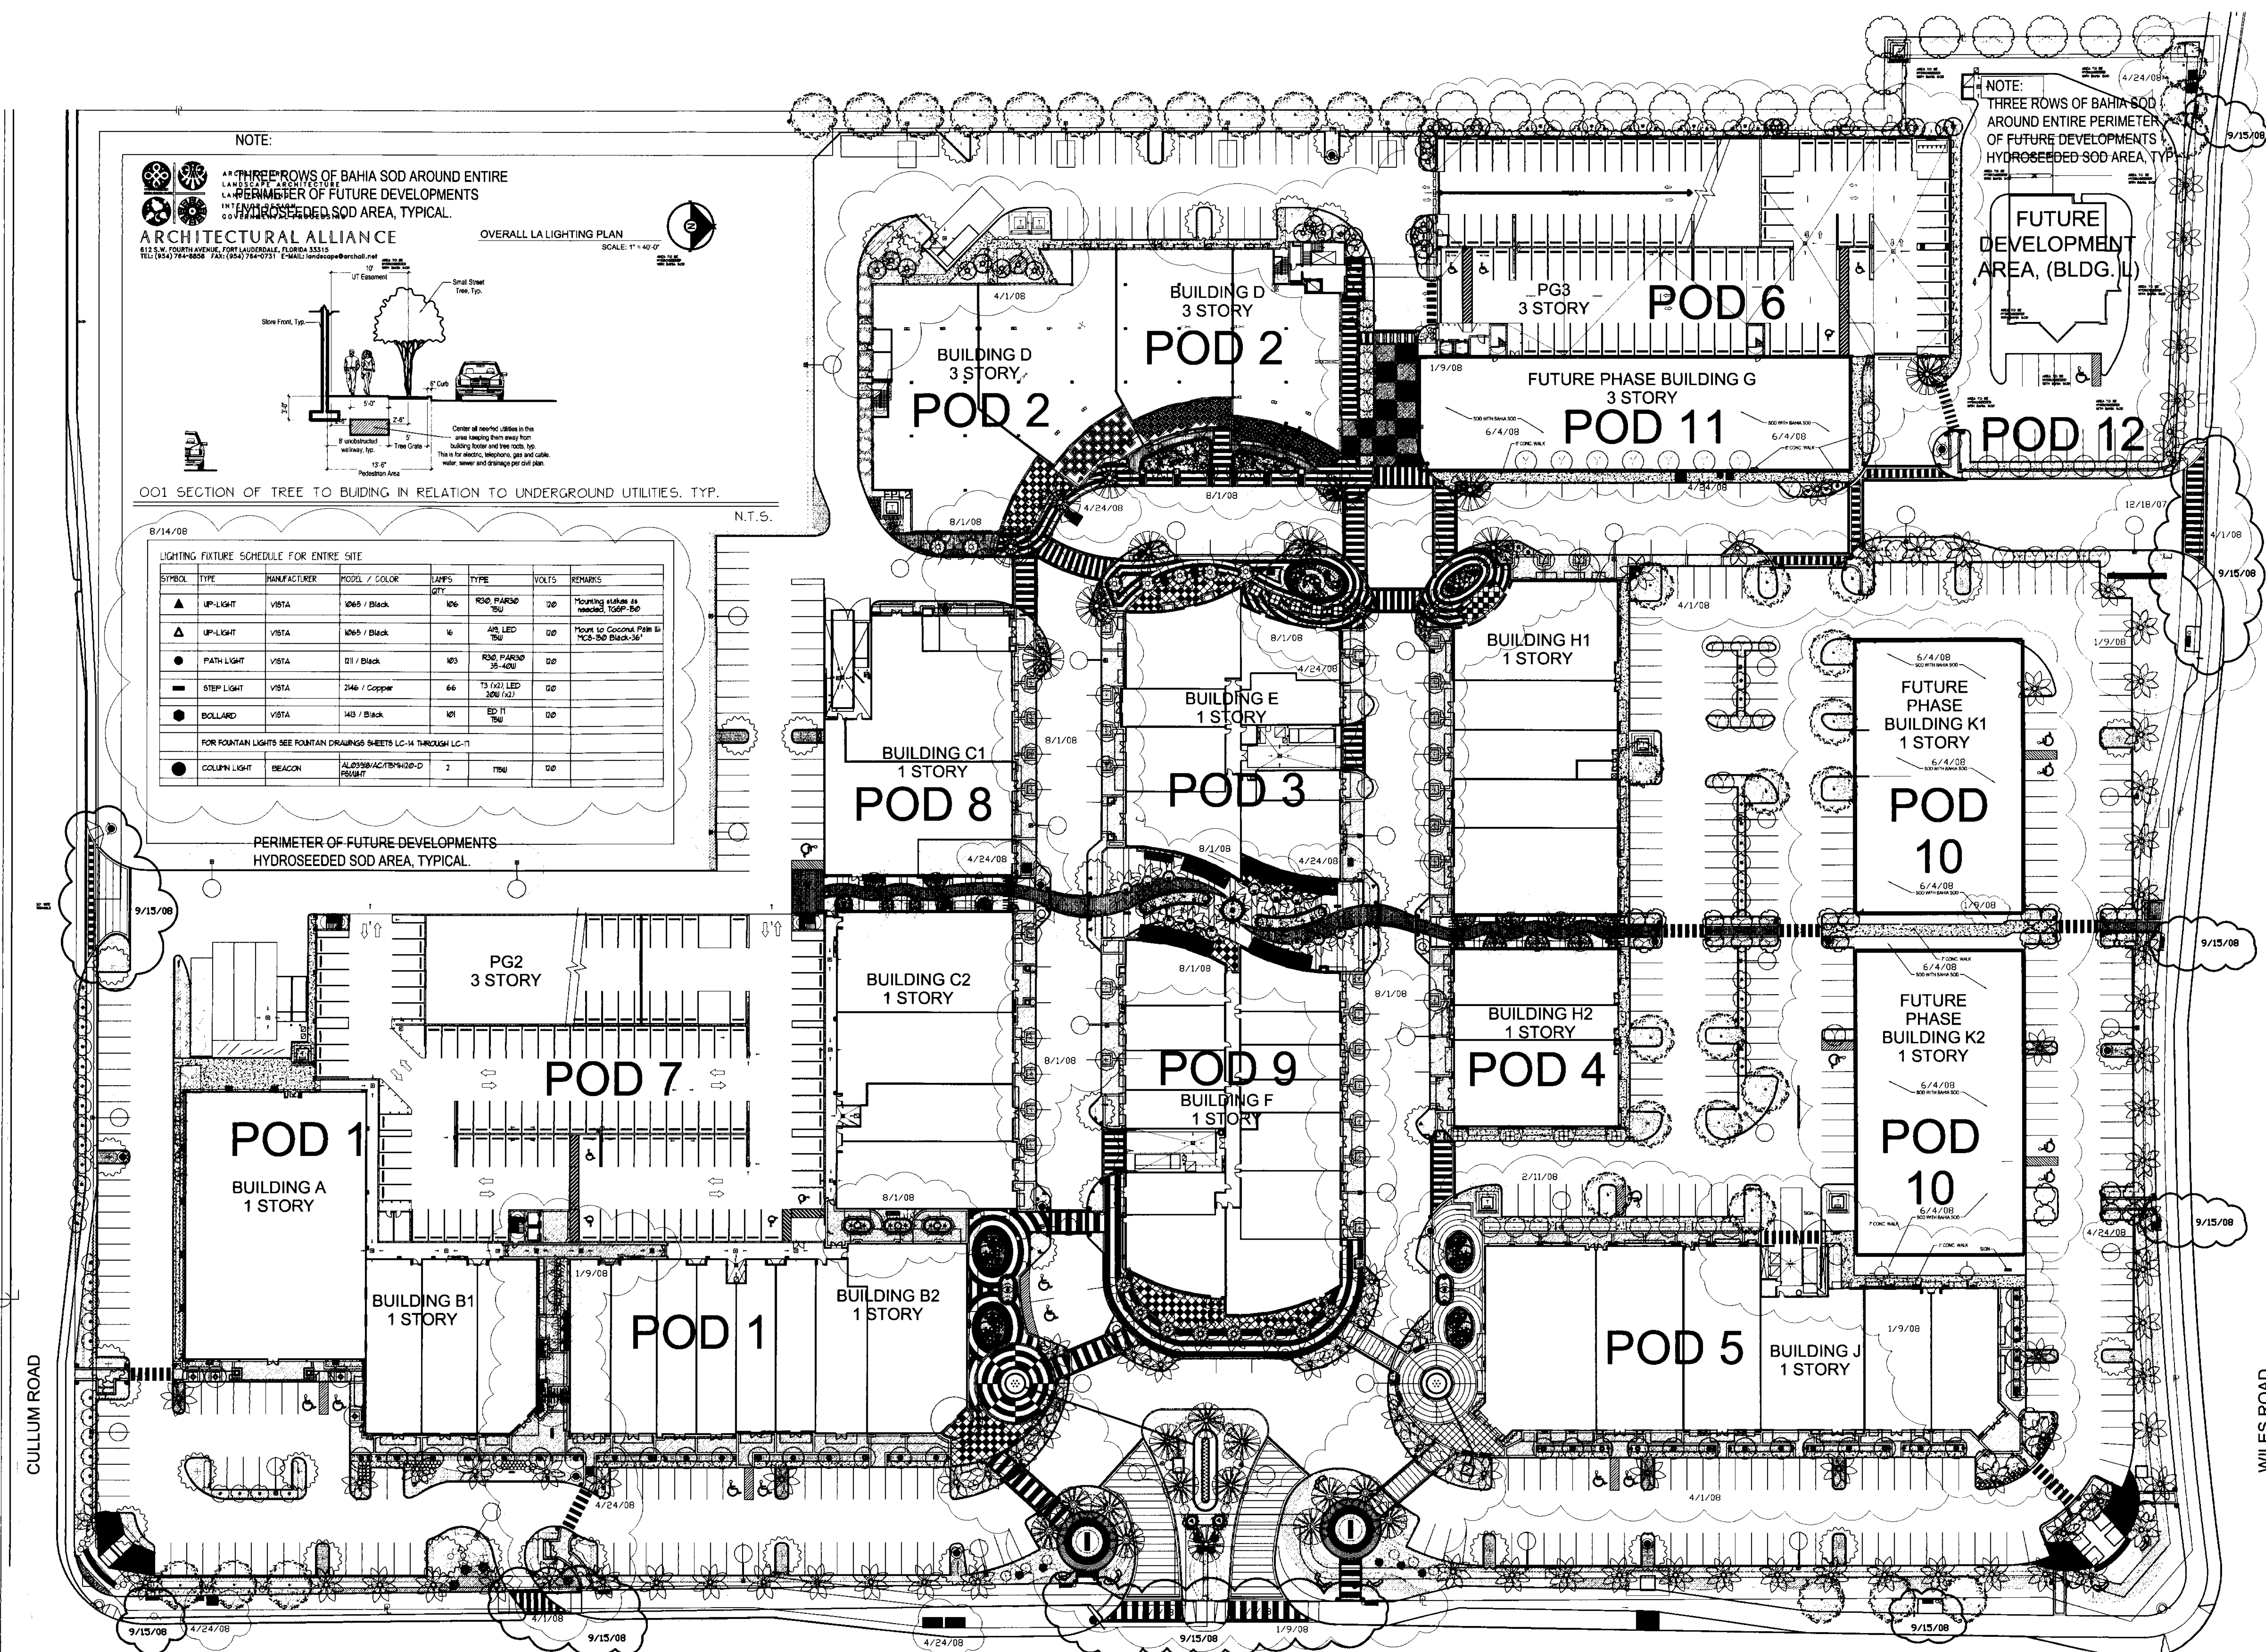

HUGH JOHNSON
RLA # C000237

Issue: City of CC Submittal
Revision #1 05-01-07
Revision #2 08-16-07
Revision #3 10-1-07
Revision #4 12-18-07
Revision #5 01-09-08
Revision #6 04-01-08
Revision #7 04-24-08
Revision #8 06-04-08
Revision #9 08-01-08
Revision #10 08-14-08
Revision #11 09-15-08

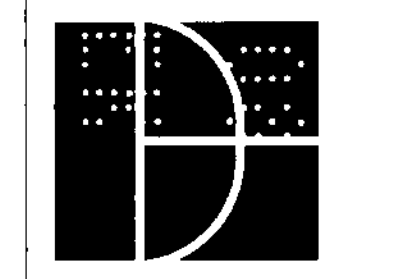

DORSKY
HODGSON
PARRISH
YUE

AA 26001261

Architecture
Planning
Interiors
Environmental
Graphics

Cleveland
Fort Lauderdale
Washington DC

Ft. Lauderdale, Florida 33394
Phone (954) 524-8686
Fax (954) 524-8604

Landscape
Lighting Plan
Job No.: 2005113
Drawn: Checked: Date: SOUTH WEST CORNER OF LYONS ROAD AND WILES ROAD, COCONUT CREEK, FLORIDA
ALL RIGHTS RESERVED

LL-1