


Issue:	Date:
City of CC Submittal	05-01-07
Revision #1	08-16-07
Revision #2	10-1-07
Revision #9	12-18-07
Revision #10	01-09-08
Revision #11	04-01-08
Revision #12	04-24-08
Revision #13	06-04-08
Revision #14	08-01-08
Revision #15	08-14-08
Revision #16	09-15-08

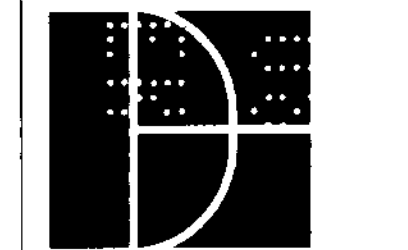

**DORSKY
HODGSON
PARRISH
YUE**

AA 26001261

Architecture
Planning
Interiors
Environmental
Graphics

Cleveland
Fort Lauderdale
Washington DC

Fort Lauderdale, Florida 33394
Phone (954) 524-8686
Fax (954) 524-8604

The Promenade at Coconut Creek
SOUTH WEST CORNER OF LYONS ROAD AND WILES ROAD, COCONUT CREEK, FLORIDA

**Landscape
Lighting Plan**

Job No.: 2005113
Drawn: [blank]
Checked: [blank]
Date: [blank]

ALL RIGHTS RESERVED

LL-2

NOTE:

THREE ROWS OF BAHIA SOD AROUND ENTIRE
PERIMETER OF FUTURE DEVELOPMENTS
HYDROSEEDED SOD AREA, TYPICAL.

AREA TO BE
HYDROSEEDED
WITH BAHIA SOD

AREA TO BE
HYDROSEEDED
WITH BAHIA SOD


AREA TO BE
HYDROSEEDED
WITH BAHIA SOD

BUILDING D
3 STORY
POD 2

MATCH LINE, LL-2 to LL-5

MATCH LINE, LL-2 to LL-3

Lighting schedule is
found on sheet LL-1

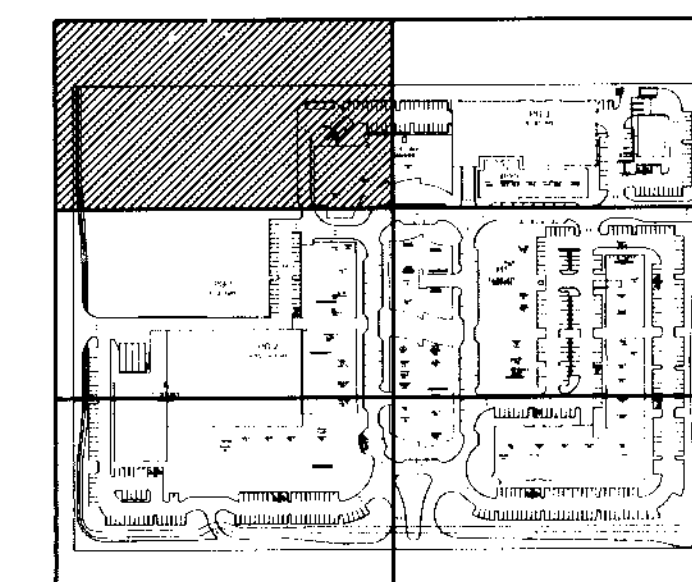

KEY PLAN

SCALE: 1" = 20'-0"