

Issue:	Date:
City of CC Submittal	05-01-07
Revision #1	08-16-07
Revision #2	10-1-07
Revision #9	12-18-07
Revision #10	01-09-08
Revision #11	04-01-08
Revision #12	04-24-08
Revision #13	06-04-08
Revision #14	08-01-08
Revision #15	08-14-08
Revision #16	09-15-08



**DORSKY
HODGSON
PARRISH
YUE**

AA 26001261

Architecture
Planning
Interiors
Environmental
Graphics

Cleveland
Fort Lauderdale
Washington DC

Ft. Lauderdale, Florida 33394
Phone (954) 524-8686
Fax (954) 524-8604

The Promenade at Coconut Creek

**Landscape
Lighting Plan**

Drawn: Checked: Date: 2005113

LL-6

MATCH LINE, LL-5 to LL-6

MATCH LINE, LL-6 to LL-7

8/1/08 ADDED 3 UP LIGHTS
TO PALMS IN SEAT WALL PLANTERS AND
9 PATH LIGHTS TO HIGHLIGHT AS WELL

8/1/08 ADDED
UP LIGHTS TO
2 PALMS IN
CIRCULAR ON
GRADE PLANTERS
2 EACH

7/23/08
TREE GRATES
REMOVED

4/1/08

9/15/08

1/9/08

9/15/08

**BUILDING H1
1 STORY**

6/4/08
SOD WITH BAHIA SOD
**FUTURE
PHASE
BUILDING K1
1 STORY**

6/4/08
SOD WITH BAHIA SOD
**POD
10**

7' CONC. WALK
6/4/08
SOD WITH BAHIA SOD
**FUTURE
PHASE
BUILDING K2
1 STORY**

6/4/08
SOD WITH BAHIA SOD
POD

**BUILDING H2
1 STORY**

POD 4

**BUILDING E
1 STORY**

POD 3

8/1/08 ADDED 2 UP
LIGHTS TO PALM IN
CIRCULAR SEAT WALL
PLANTER

8/1/08 ADDED 16 UP
LIGHTS STRAPPED TO
PALMS 8' ABOVE GRADE
OR HIGHER SEE THIS
SYMBOL. SEE LL-3
ALSO

4/24/08


8/1/08
4 CIRCULAR AT
GRADE PLANTERS
ROTATED TO GIVE
6' CLEAR WALK
SPACE BETWEEN
SEAT WALL AND
PLANTER

POD 9

**BUILDING F
1 STORY**

8/1/08
TREE GRATES
REMOVED

**Lighting schedule is
found on sheet LL-1**

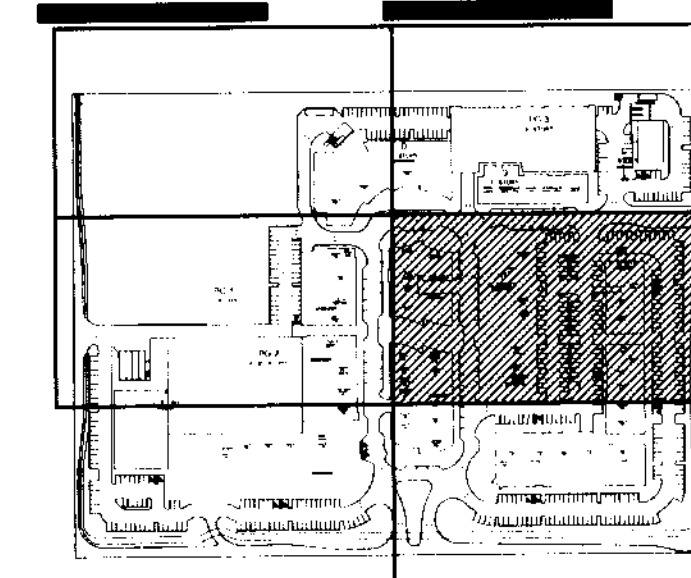

KEY PLAN

SCALE: 1" = 20'-0"



ALL RIGHTS RESERVED