


MATCH LINE, LL-4 to LL-7

MATCH LINE, LL-6 to LL-7

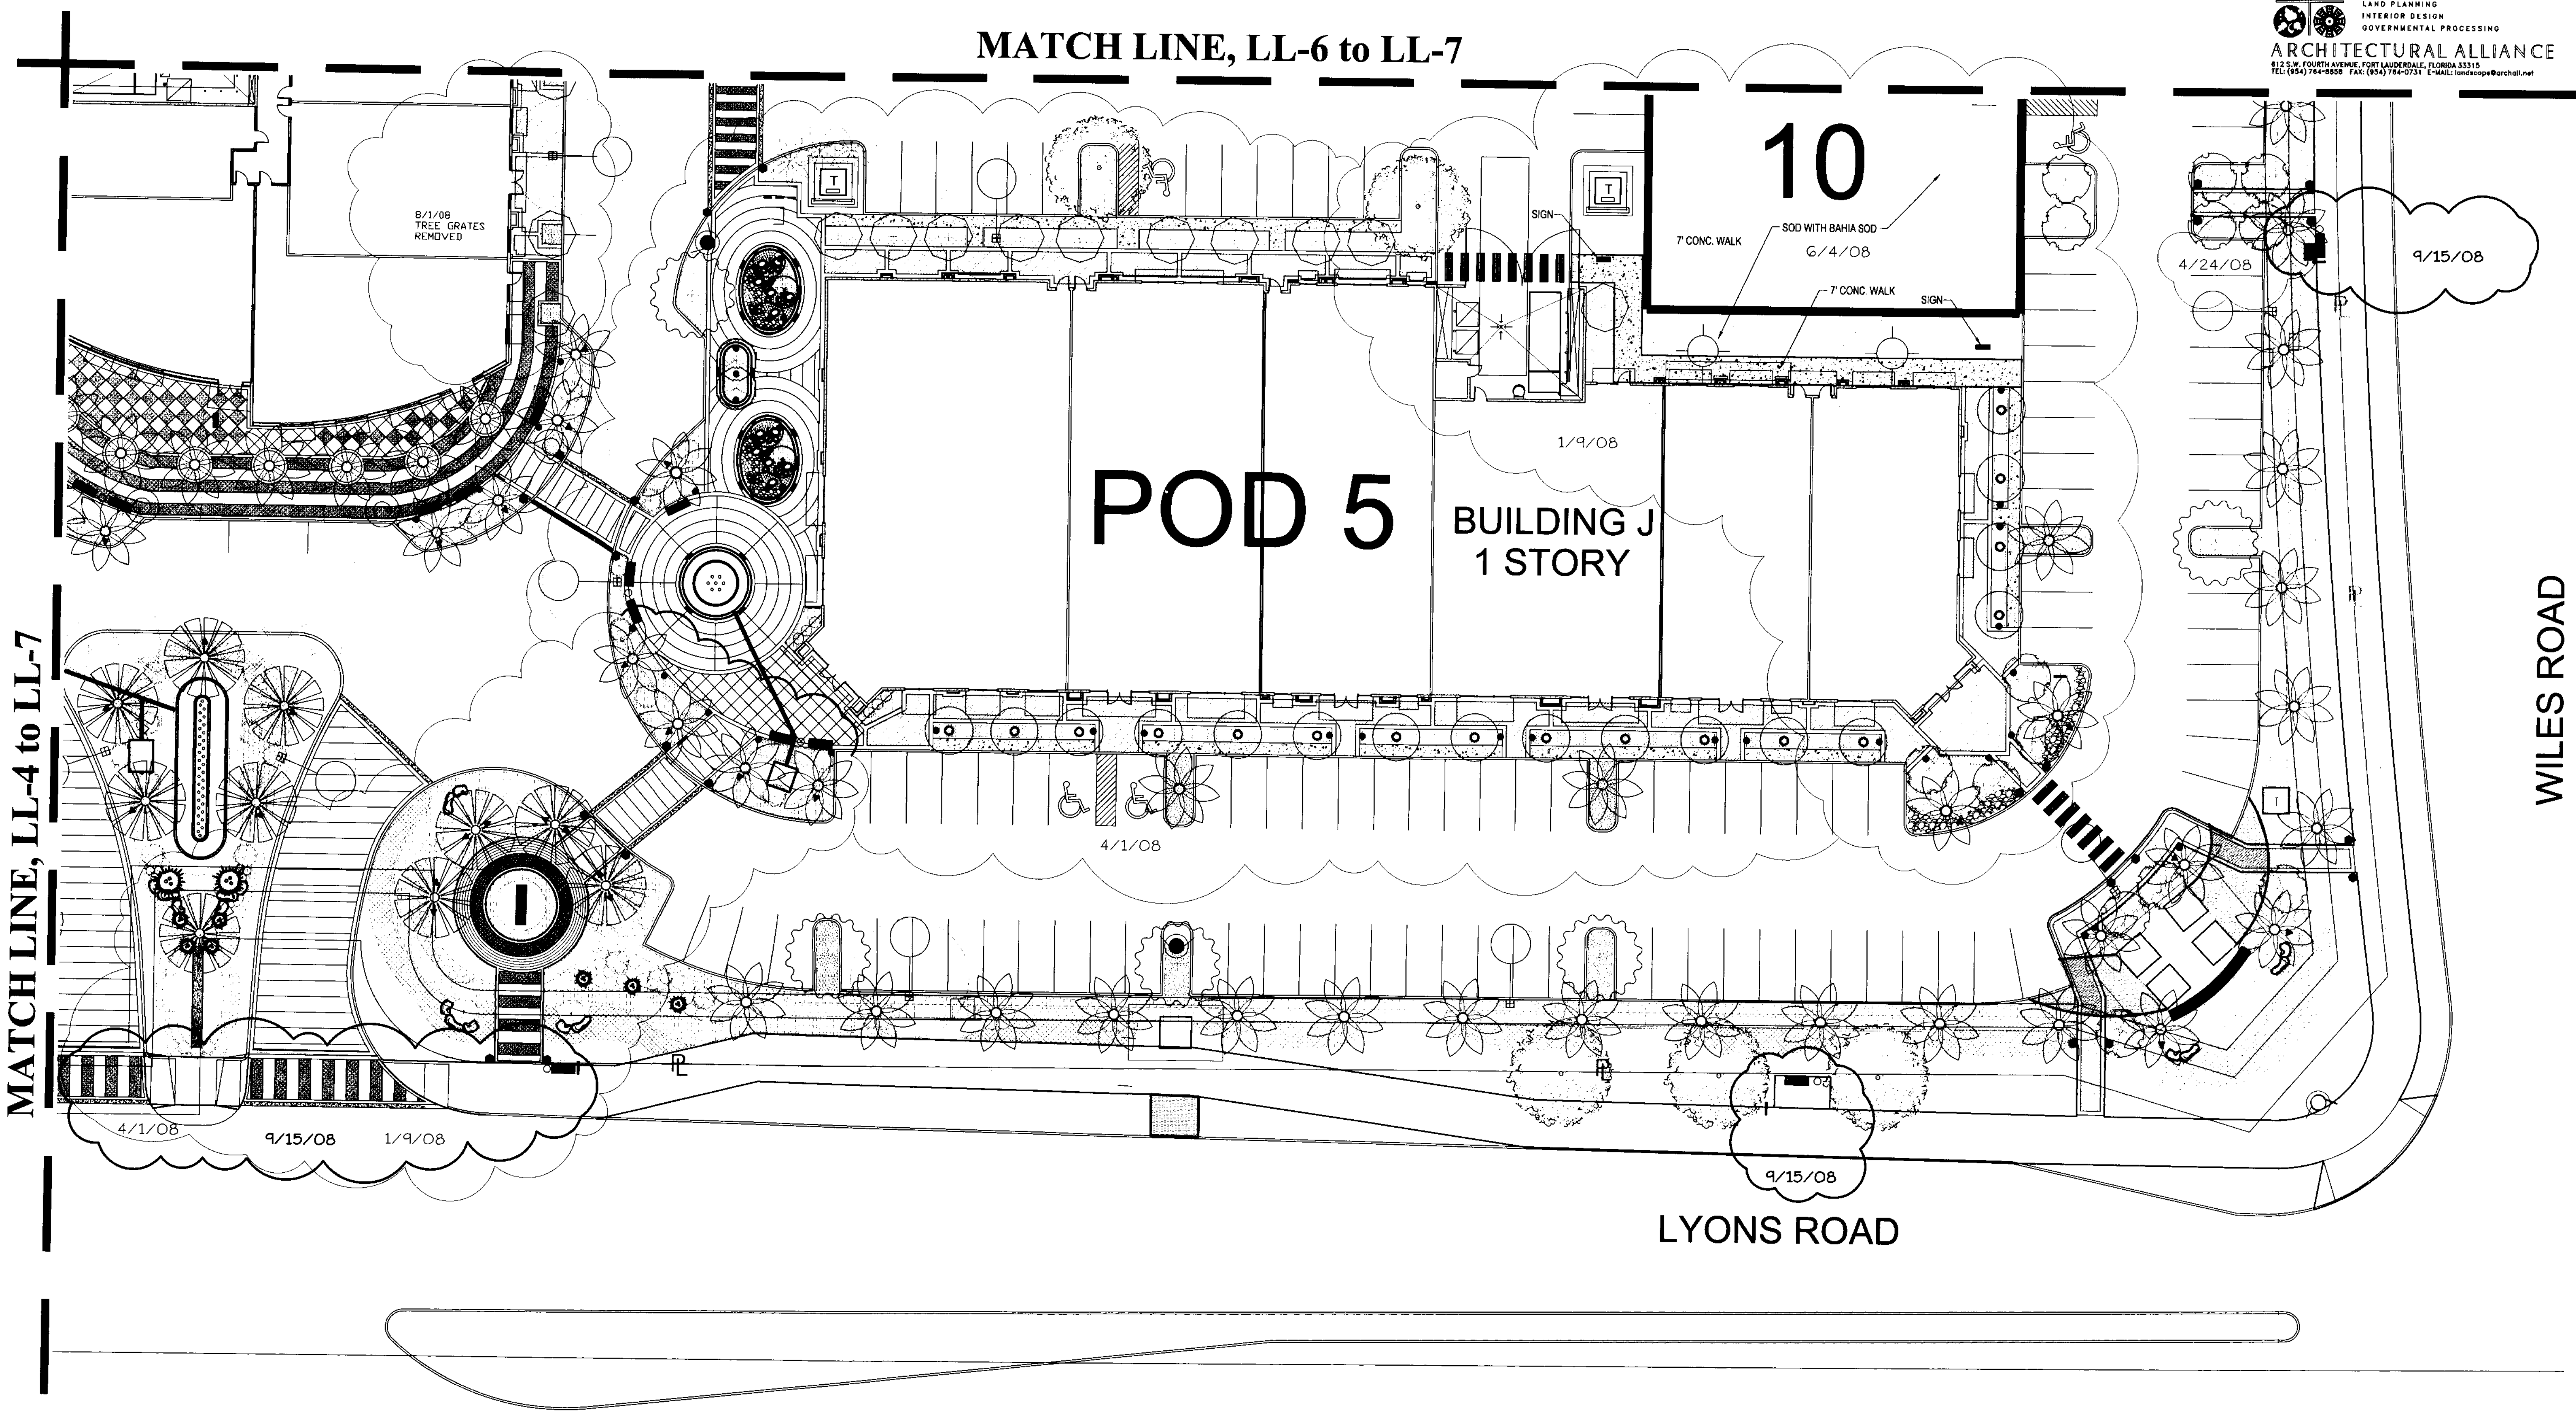


LYONS ROAD

WILES ROAD

ARCHITECTURE
LANDSCAPE ARCHITECTURE
LAND PLANNING
INTERIOR DESIGN
GOVERNMENTAL PROCESSING
ARCHITECTURAL ALLIANCE
812 S.W. FOURTH AVENUE, FORT LAUDERDALE, FLORIDA 33315
TEL: (954) 764-8858 FAX: (954) 764-0751 E-MAIL: landscape@archall.net

HUGH JOHNSON
RLA # C000237

Issue:	Date:
City of CC Submittal	05-01-07
Revision #1	08-16-07
Revision #2	10-1-07
Revision #9	12-18-07
Revision #10	01-09-08
Revision #11	04-01-08
Revision #12	04-24-08
Revision #13	06-04-08
Revision #14	08-01-08
Revision #15	08-14-08
Revision #16	09-15-08

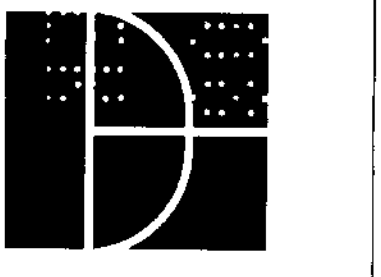

**DORSKY
HODGSON
PARRISH
YUE**

AA 26001261

Architecture
Planning
Interiors
Environmental
Graphics

Cleveland
Fort Lauderdale
Washington DC


Ft. Lauderdale, Florida 33394
Phone (954) 524-8686
Fax (954) 524-8604

**Landscape
Lighting Plan**
The Promenade at Coconut Creek
SOUTH WEST CORNER OF LYONS ROAD AND WILES ROAD, COCONUT CREEK, FLORIDA

Job No.:	2005113
Drawn:	
Checked:	
Date:	

ALL RIGHTS RESERVED

Lighting schedule is
found on sheet LL-1

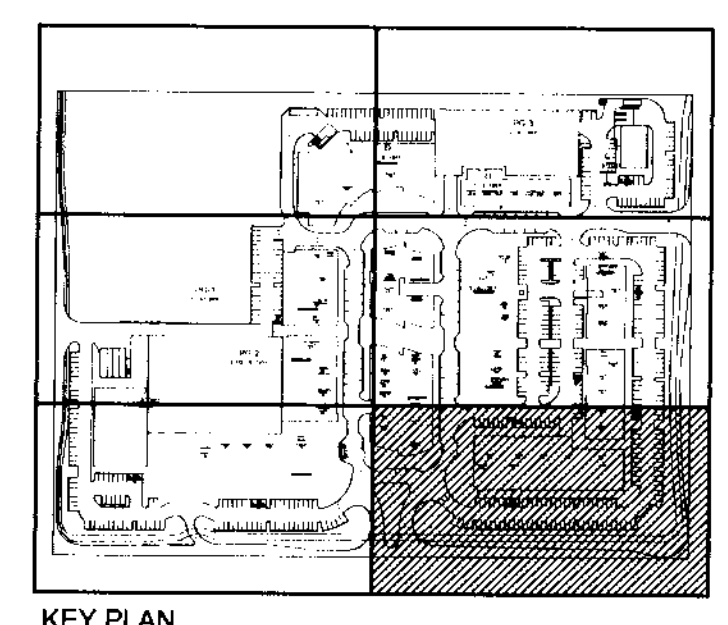

KEY PLAN

SCALE: 1" = 20'-0"