


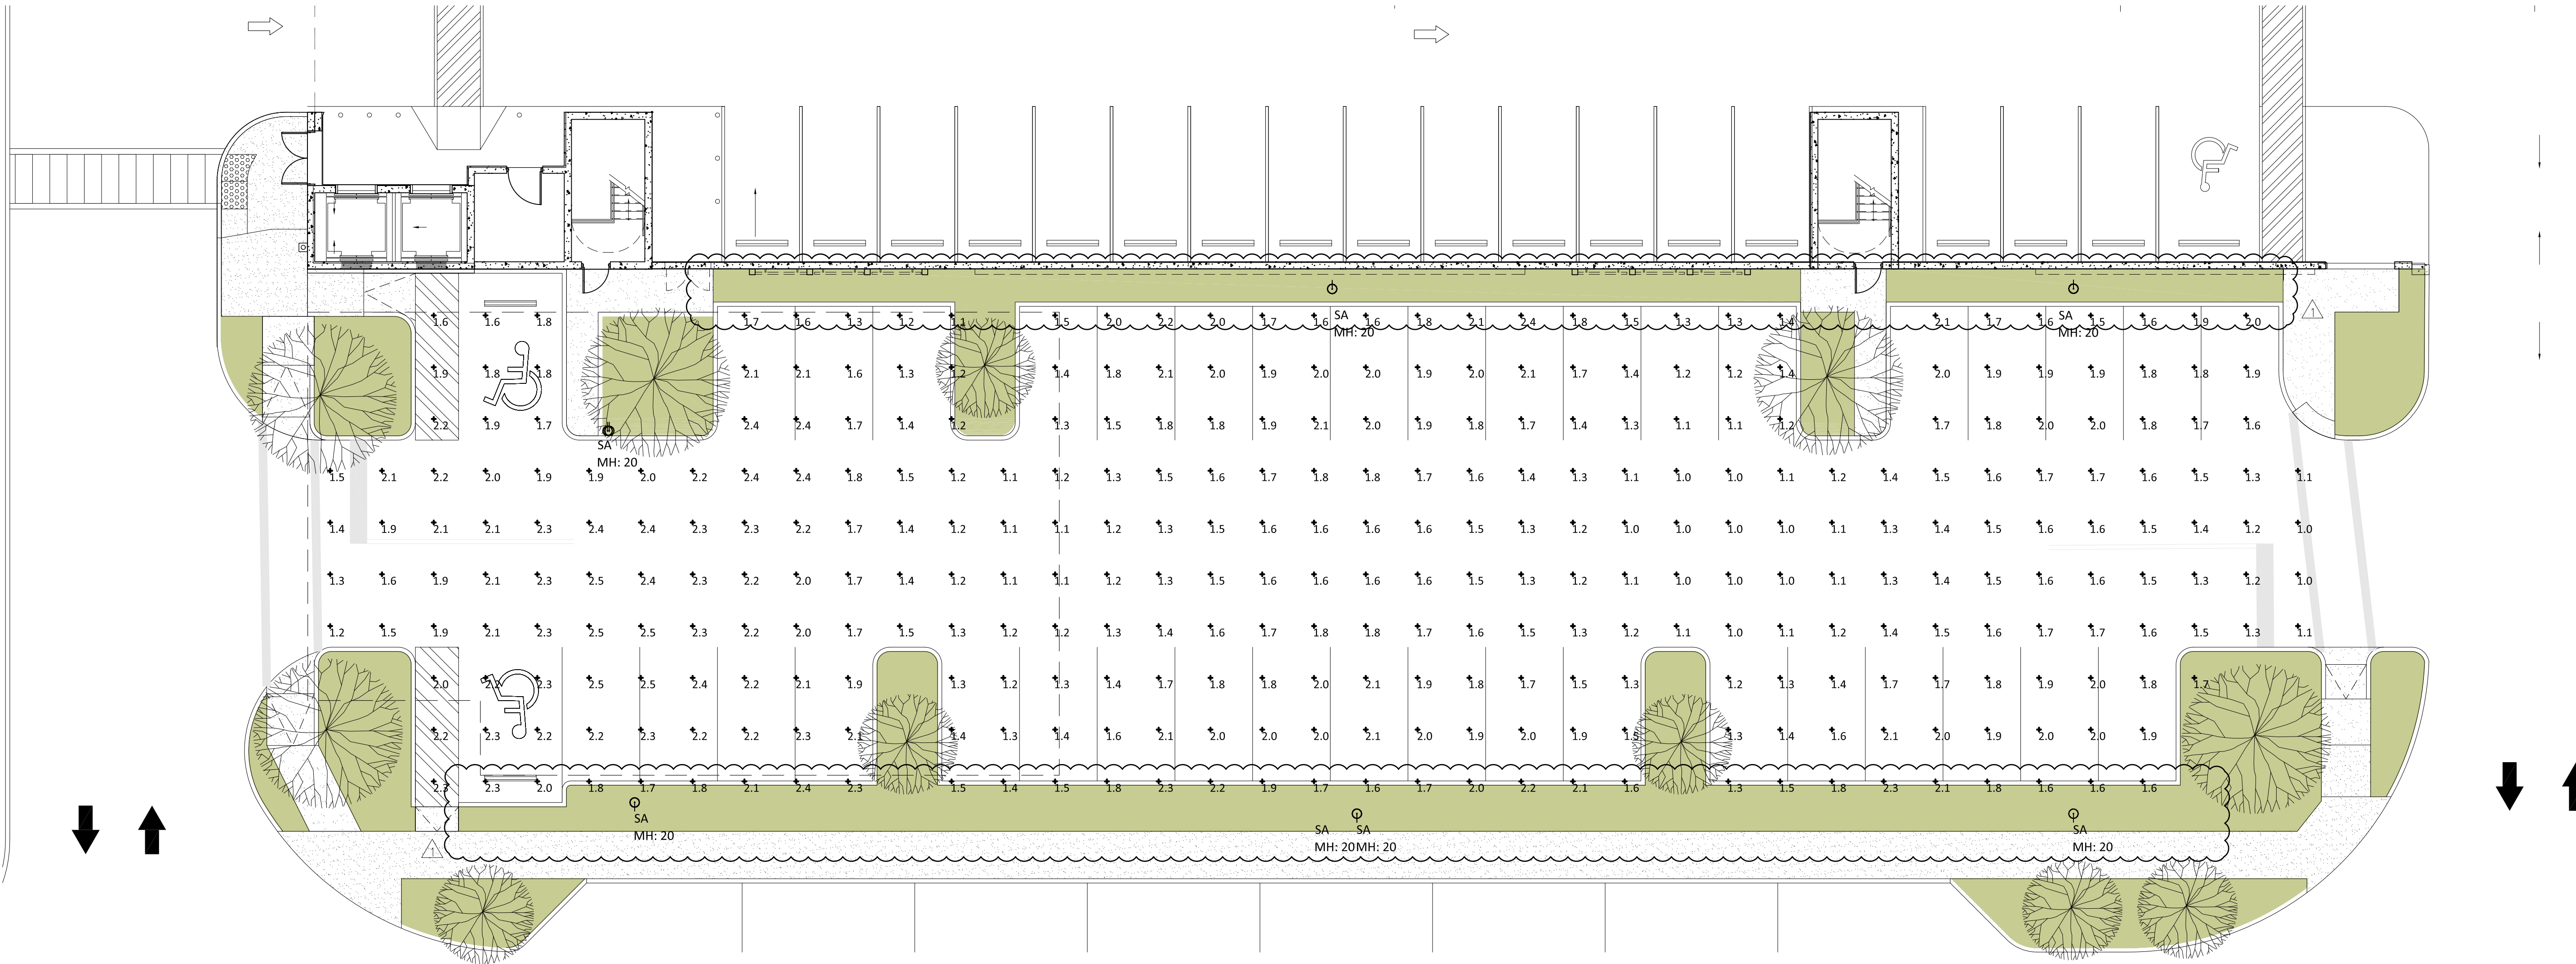


Luminaire Schedule							
Symbol	Qty	Label	Arrangement	Lum. Lumens	LLF	Lum. Watts	Arr. Watts
	6	SA	SINGLE	9969	0.900	108	108

Calculation Summary								
Label	CalcType	Units	Avg	Max	Min	Avg/Min	Max/Min	
SITE @ 3' AFG	Illuminance	Fc	1.69	2.5	1.0	1.69	2.50	

**Note: Coconut Creek Code: Complies with no more than 10fc at 3' AFG
Broward County Code: Complies with the max is 2.5fc

THE PROMENADE AT COCONUT CREEK								
LIGHTING FIXTURE SCHEDULE								
TYPE	DESCRIPTION	MFR	CATALOG NUMBER	VOLTS	LAMPS	INPUT WATTS	MOUNTING	REMARKS
SA	LED SITE LUMINAIRE	McGRAW-EDISON	TT-C6-LED-E1-RW-PM-FINISH	UNV	LED	108	POLE	Note 1
POLE	20' ALUMINUM POLE	VALMONT	R-190840705T4-D1-FINISH	N/A	N/A	N/A	20' POLE	Note 1
FIXTURE SCHEDULE NOTES								
NOTE 1: CONFIRM FINISH								
FOR QUESTIONS PERTAINING TO THIS FIXTURE SCHEDULE PLEASE CONTACT LEDIA KARAJ @ LIGHTING DYNAMICS (786) 801-7622								

LIGHTING COMPLIANCE CHART			
LAMP DESCRIPTION	QTY	LUMINAIRE LUMENS	TOTAL
108w LED	6	9969	59,814
TOTAL LUMINAIRE LUMENS			59,814
SITE ALLOWED TOTAL LUMENS (13,700 SQFT X 7.5LMS/SQFT)			102,750
PROJECT IS COMPLIANT?			YES

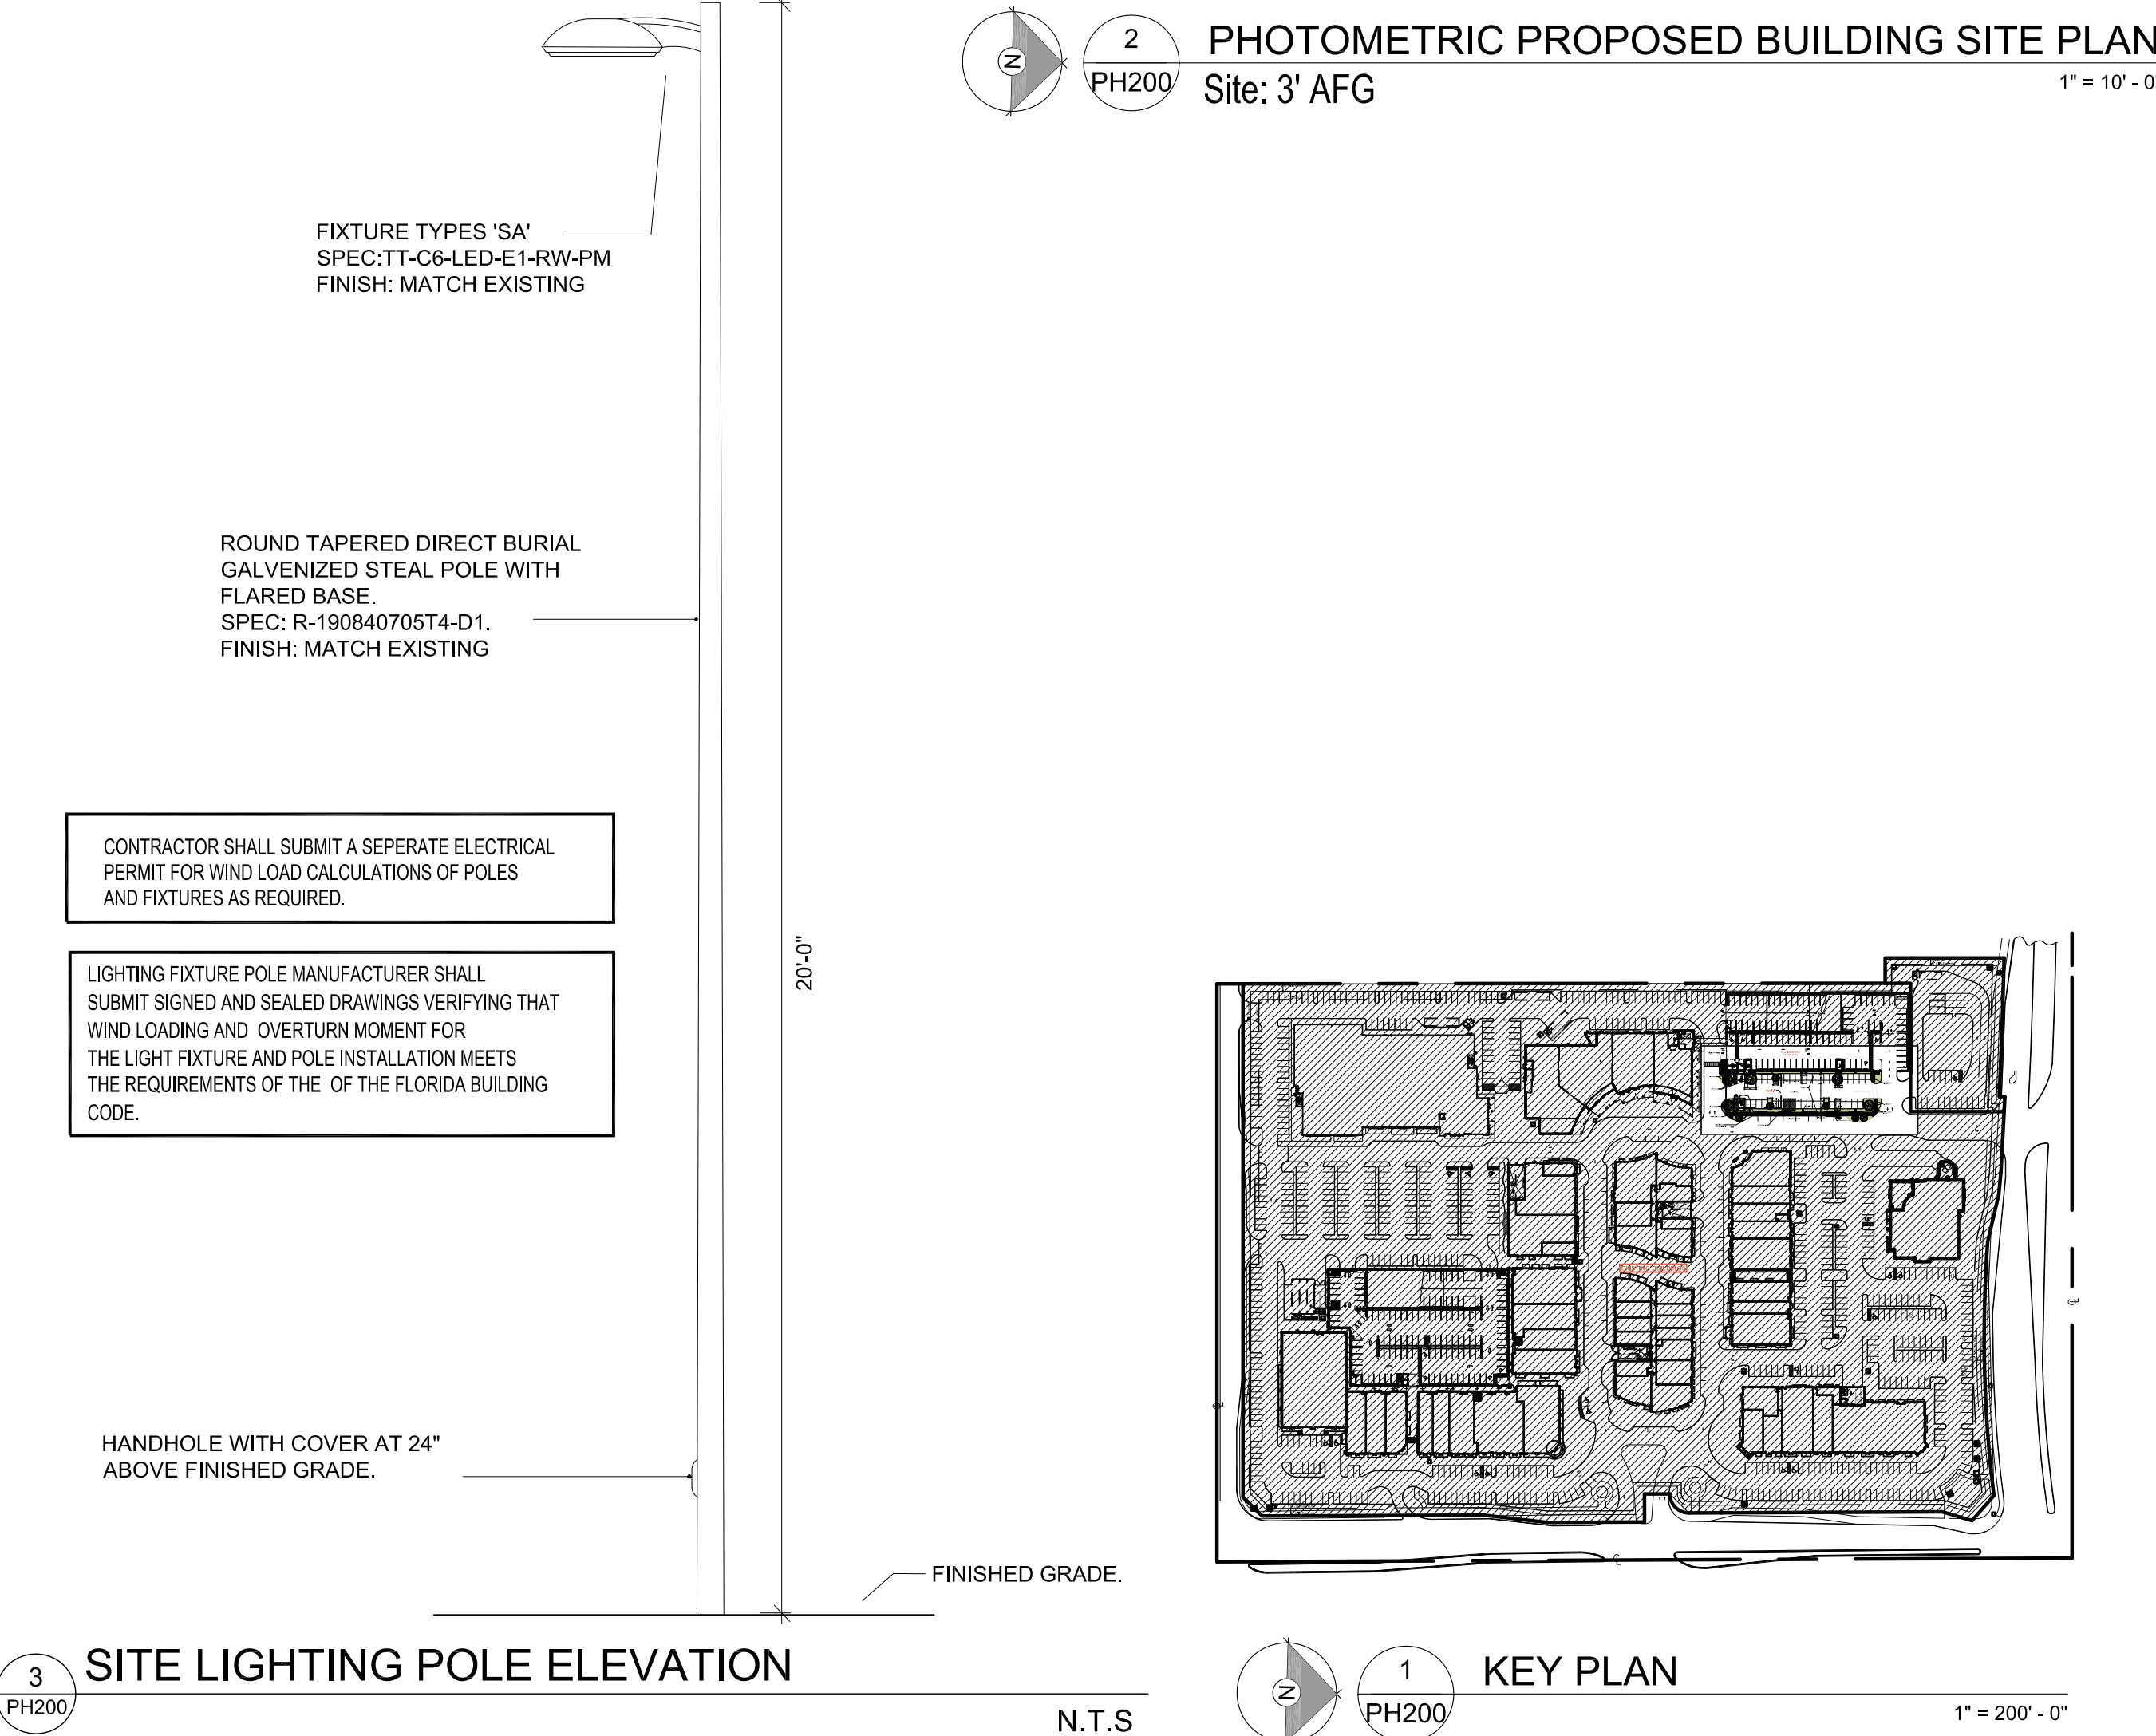

3 PH200 SITE LIGHTING POLE ELEVATION N.T.S. 1 PH200 KEY PLAN 1" = 200' - 0"

Victor K. Yue
AR 0013087

AA 26002045
Issue: SITE PLAN SUBMISSION
Date: 09-26-17
DRC COMMENTS 10-26-17

DORSKY + YUE INTERNATIONAL
ARCHITECTURE
CLEVELAND
P: 216.468.1833
F: 216.468.3510

FORT LAUDERDALE
P: 954.473.3333
F: 954.473.4854

PROMENADE AT COCONUT CREEK

COCONUT CREEK, FL
ALL RIGHTS RESERVED

PHOTOMETRIC SITE PLAN

Job No.: DY201627
Date: 9-26-2017
Checked:
Drawn:
N.T.S.

PH300