

AA 26002045
Issue: SITE PLAN SUBMISSION
Date: 09-26-17
DRC COMMENTS 10-26-17

DORSKY+YUE INTERNATIONAL
ARCHITECTURE

FORT LAUDERDALE
P: 954-703-7830
F: 954-524-8504


PROMENADE AT COCONUT CREEK

COCONUT CREEK, FL
ALL RIGHTS RESERVED


IRRIGATION PLAN

Job No.: DY201027
Date: 9-26-2017
Checked: MM.
Drawn: E.C.


L-302

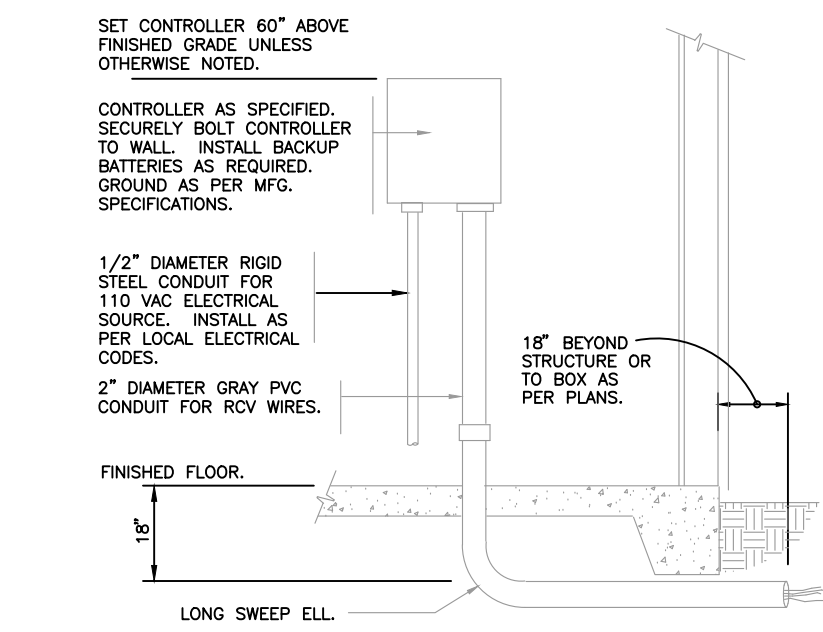


1 INTERIOR WALL MOUNT CONTROLLER
1" = 1'-0"
FX-IR-FX-CONT-14

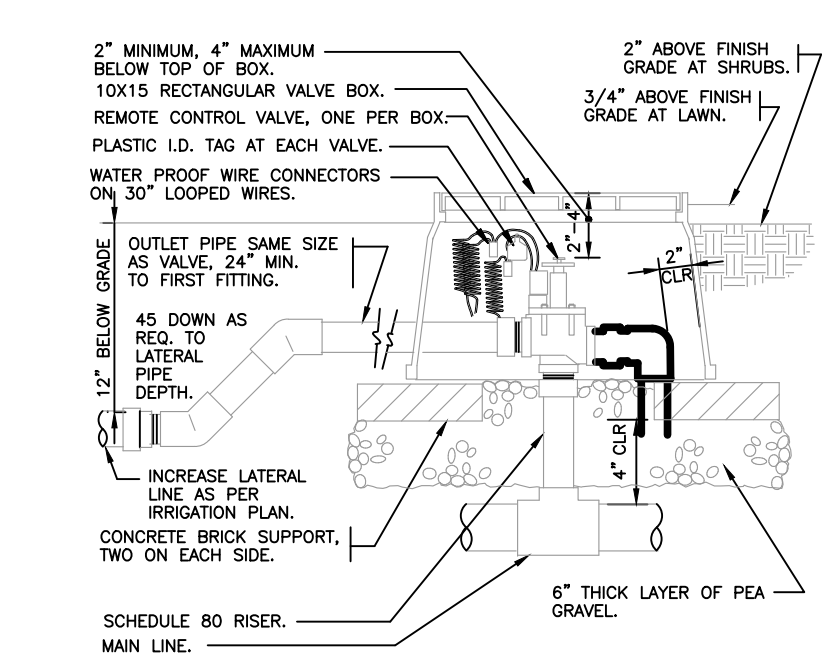


2 ELECTRIC REMOTE CONTROL VALVE
1 1/2" = 1'-0"
FX-IR-FX-BACK-03

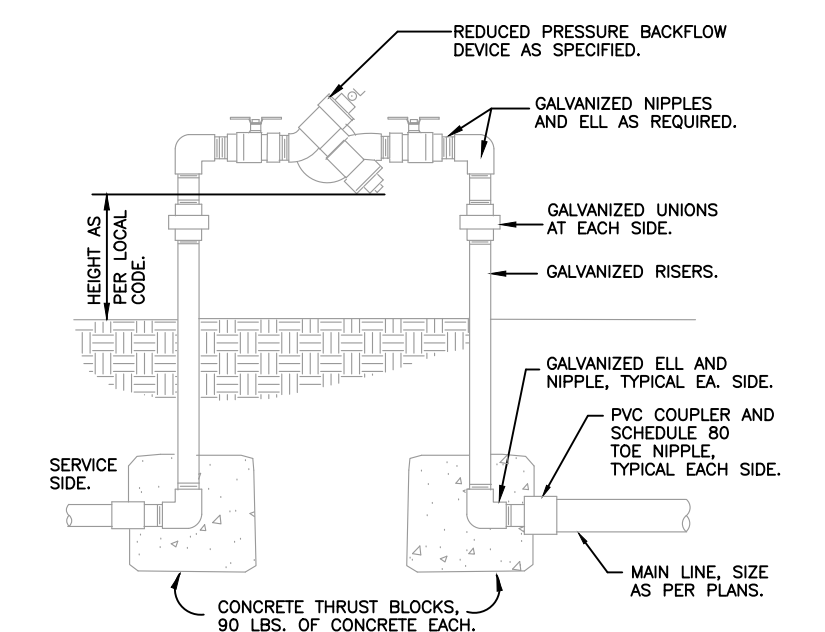


3 REDUCED PRESSURE BACKFLOW DEVICE
1" = 1'-0"
FX-IR-FX-BACK-03

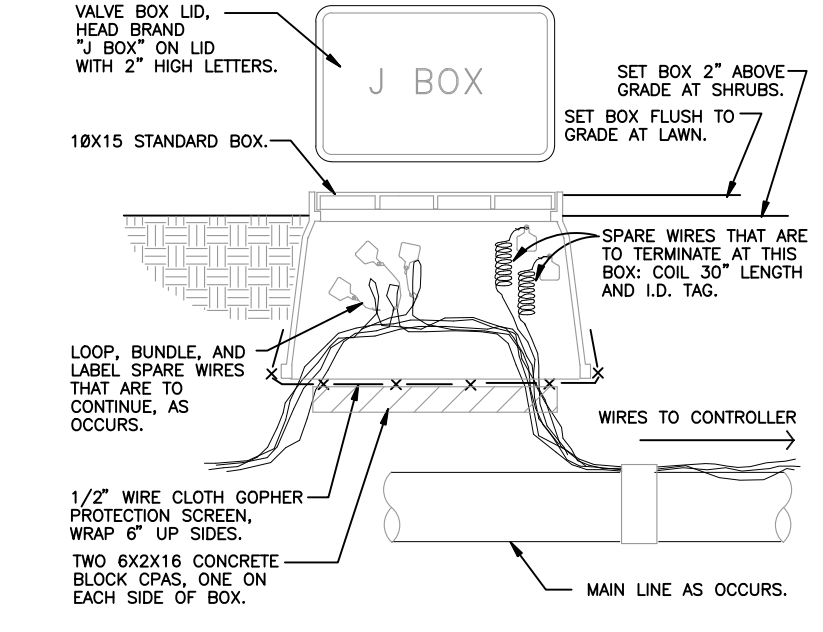


4 WIRE BUNDLE JUNCTION BOX
1 1/2" = 1'-0"
FX-IR-FX-BACK-03

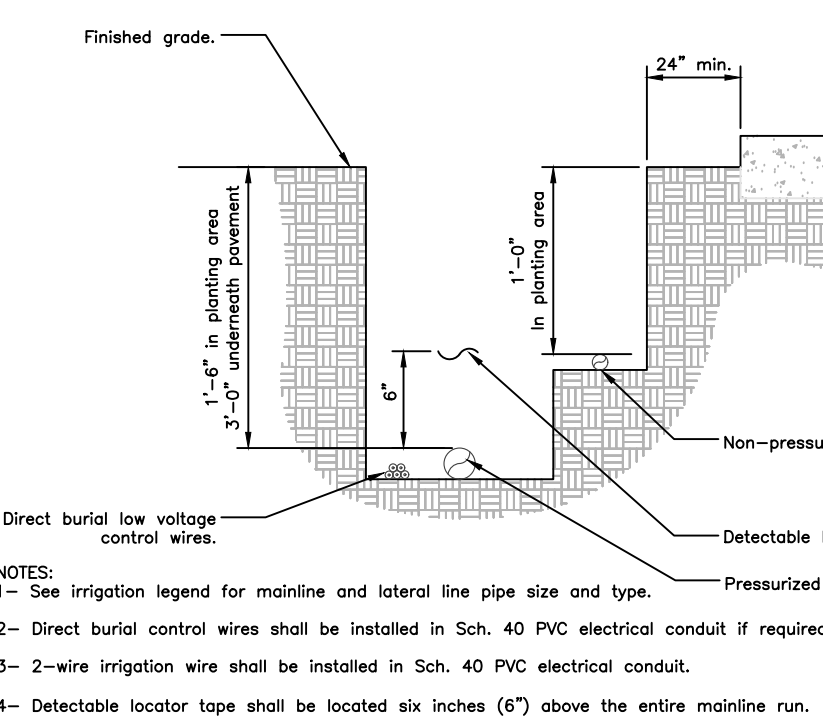


5 IRRIGATION TRENCHING
1 1/2" = 1'-0"
FX-IR-FX-BACK-03

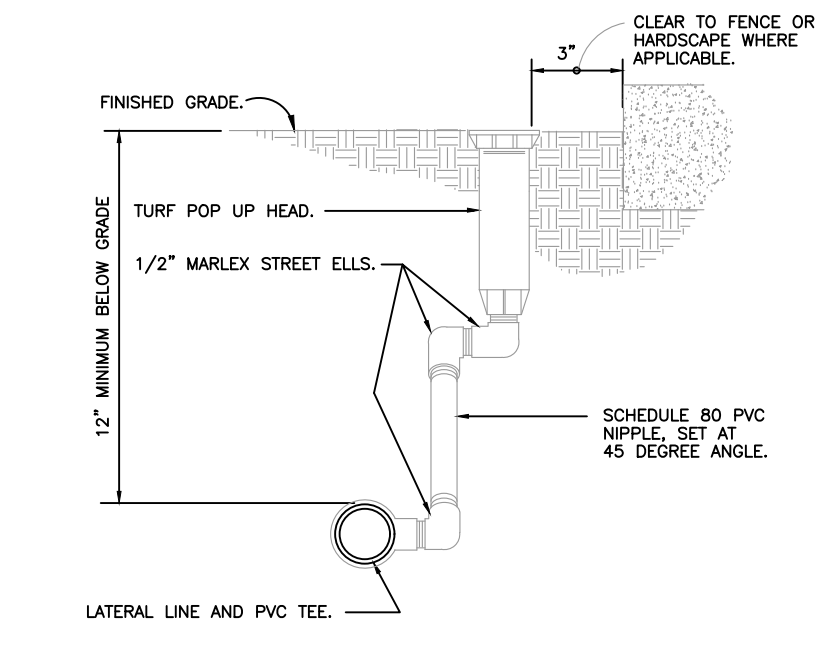


6 TURF SPRAY MARLEX ASSEMBLY
3" = 1'-0"
FX-IR-FX-BACK-03

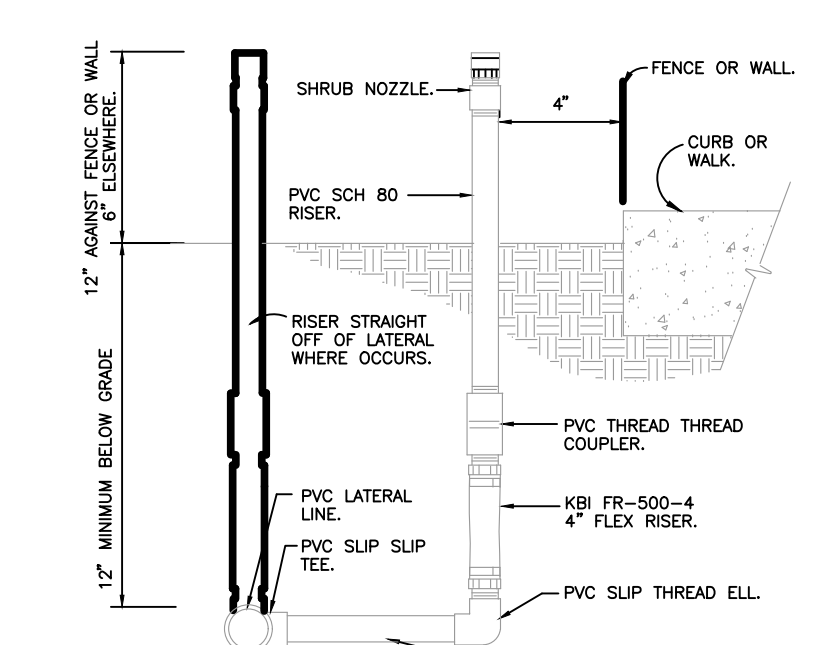

7 SHRUB SPRAY KBI FIXED RISER
3" = 1'-0"
FX-IR-FX-HEAD-07

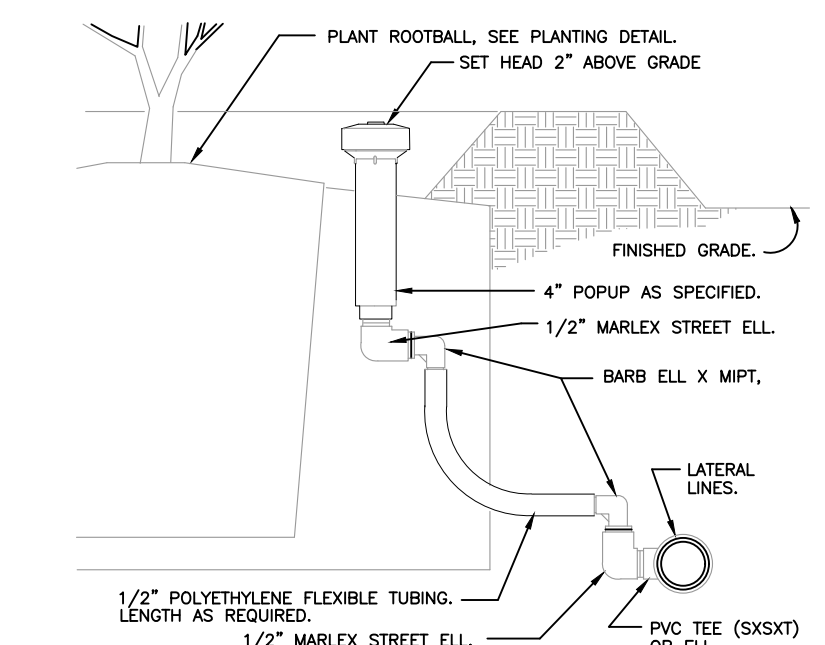

8 POPUP BUBBLER
3" = 1'-0"
FX-IR-FX-BACK-03

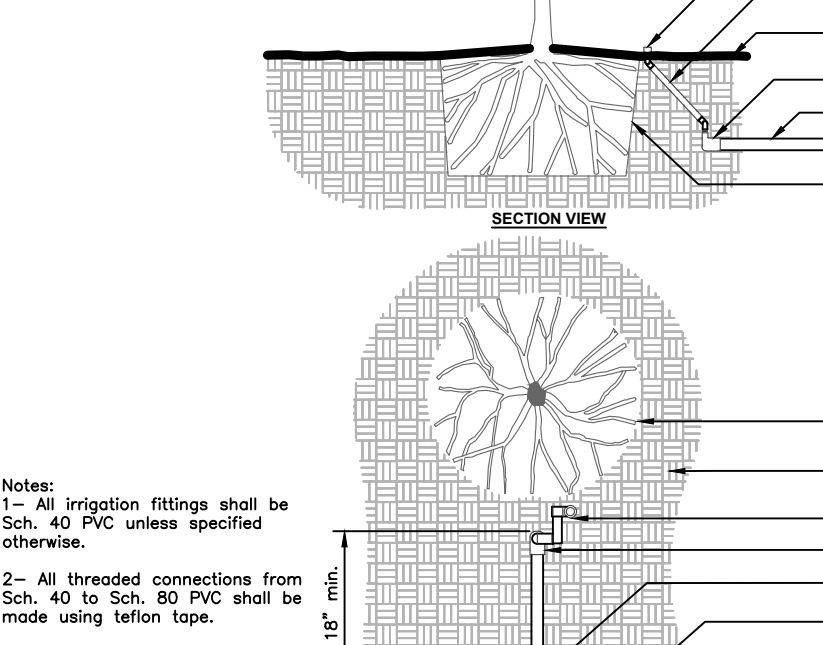

9 IRRIGATION BUBBLER W/ LAYOUT
3/4" = 1'-0"
FX-IR-FX-BACK-03

