



**DORSKY
 HODGSON
 FARRISH
 YUE**

AA 26001261

Architecture
 Planning
 Interiors

Cleveland
 Fort Lauderdale
 Washington DC


One Financial Plaza, Suite 2400
 Ft. Lauderdale, Florida 33394
 Phone (954) 524-8686
 Fax (954) 524-8604

COCONUT CREEK DEVELOPMENT LLC
 COCONUT CREEK, FLORIDA

SIXTH FLOOR PLAN

Job No.: 2005113
 Drawn: DHPY
 Checked: DHPY
 Date: March 27, 2006

A-104

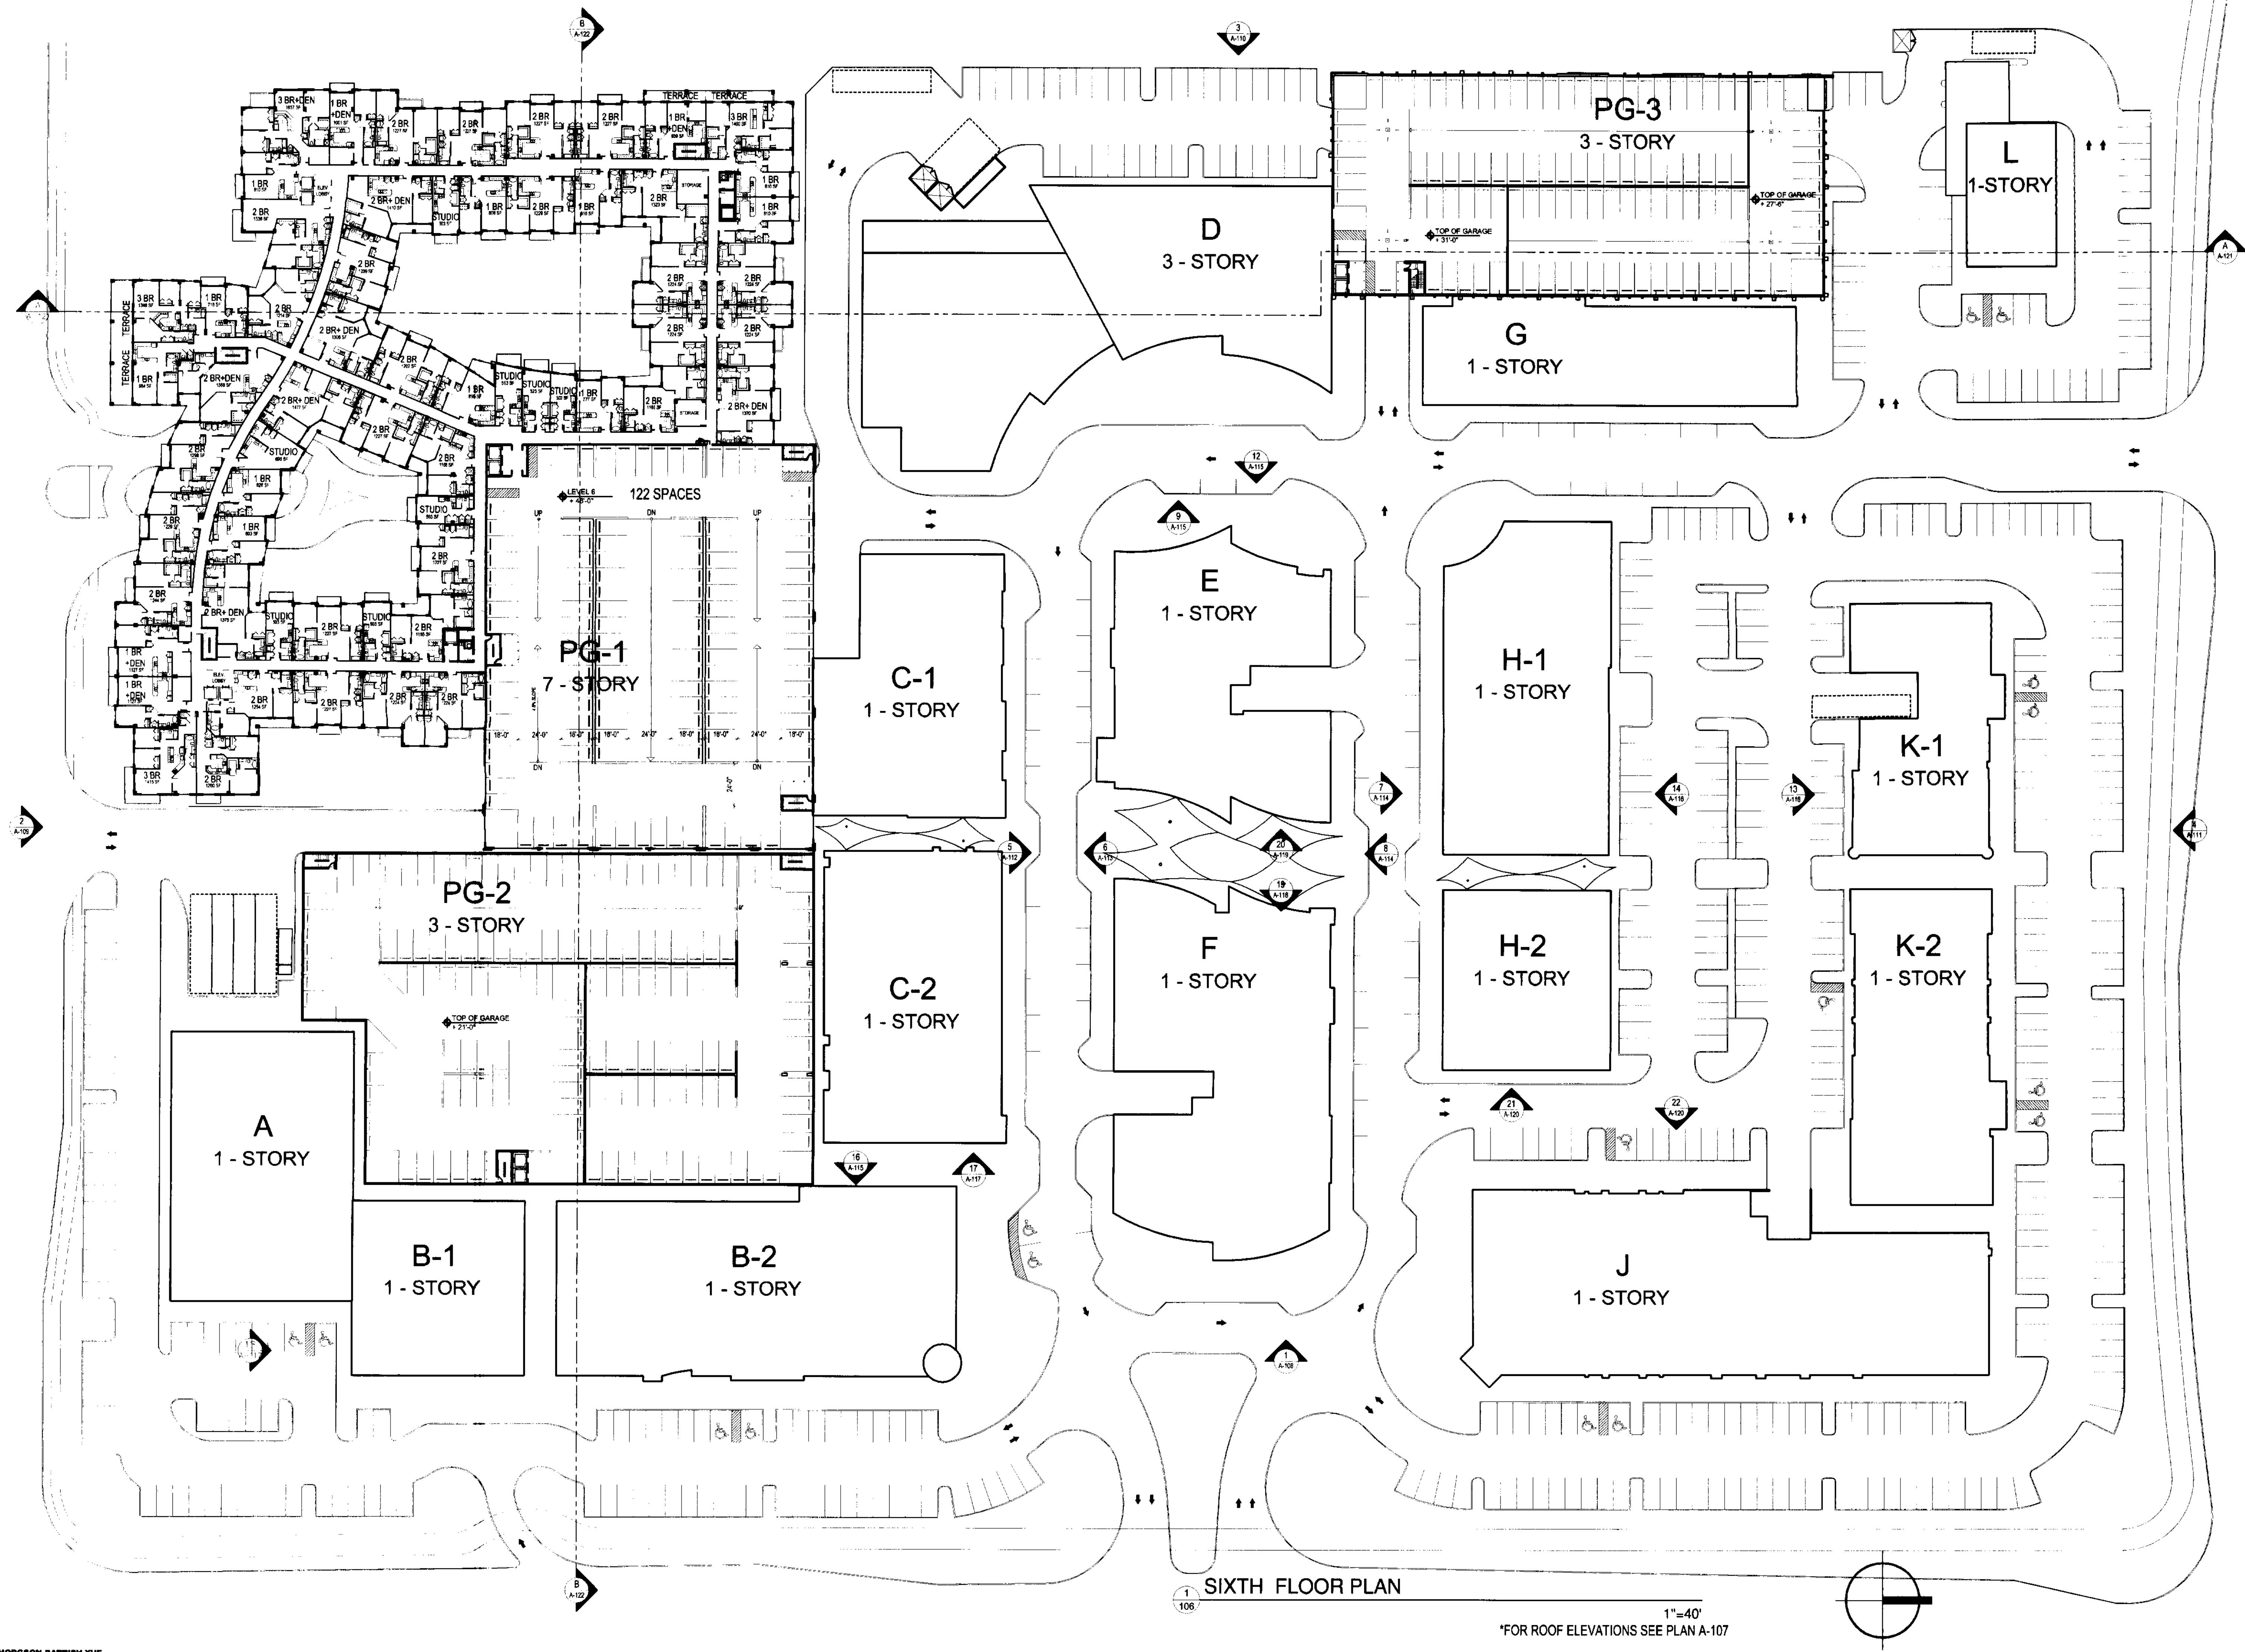

SIXTH FLOOR PLAN

1"=40'
 *FOR ROOF ELEVATIONS SEE PLAN A-107