



**DORSKY
HODGSON
PARRISH
YUE**

AA 26001261

Architecture
Planning
Interiors

Cleveland
Fort Lauderdale
Washington DC


One Financial Plaza, Suite 2400
Ft. Lauderdale, Florida 33394
Phone (954) 524-8686
Fax (954) 524-8604

COCONUT CREEK DEVELOPMENT LLC
COCONUT CREEK, FLORIDA

EIGHTH FLOOR PLAN

Job No.: 2005113
Drawn: DHPY
Checked: DHPY
Date: March 27, 2006

A-106

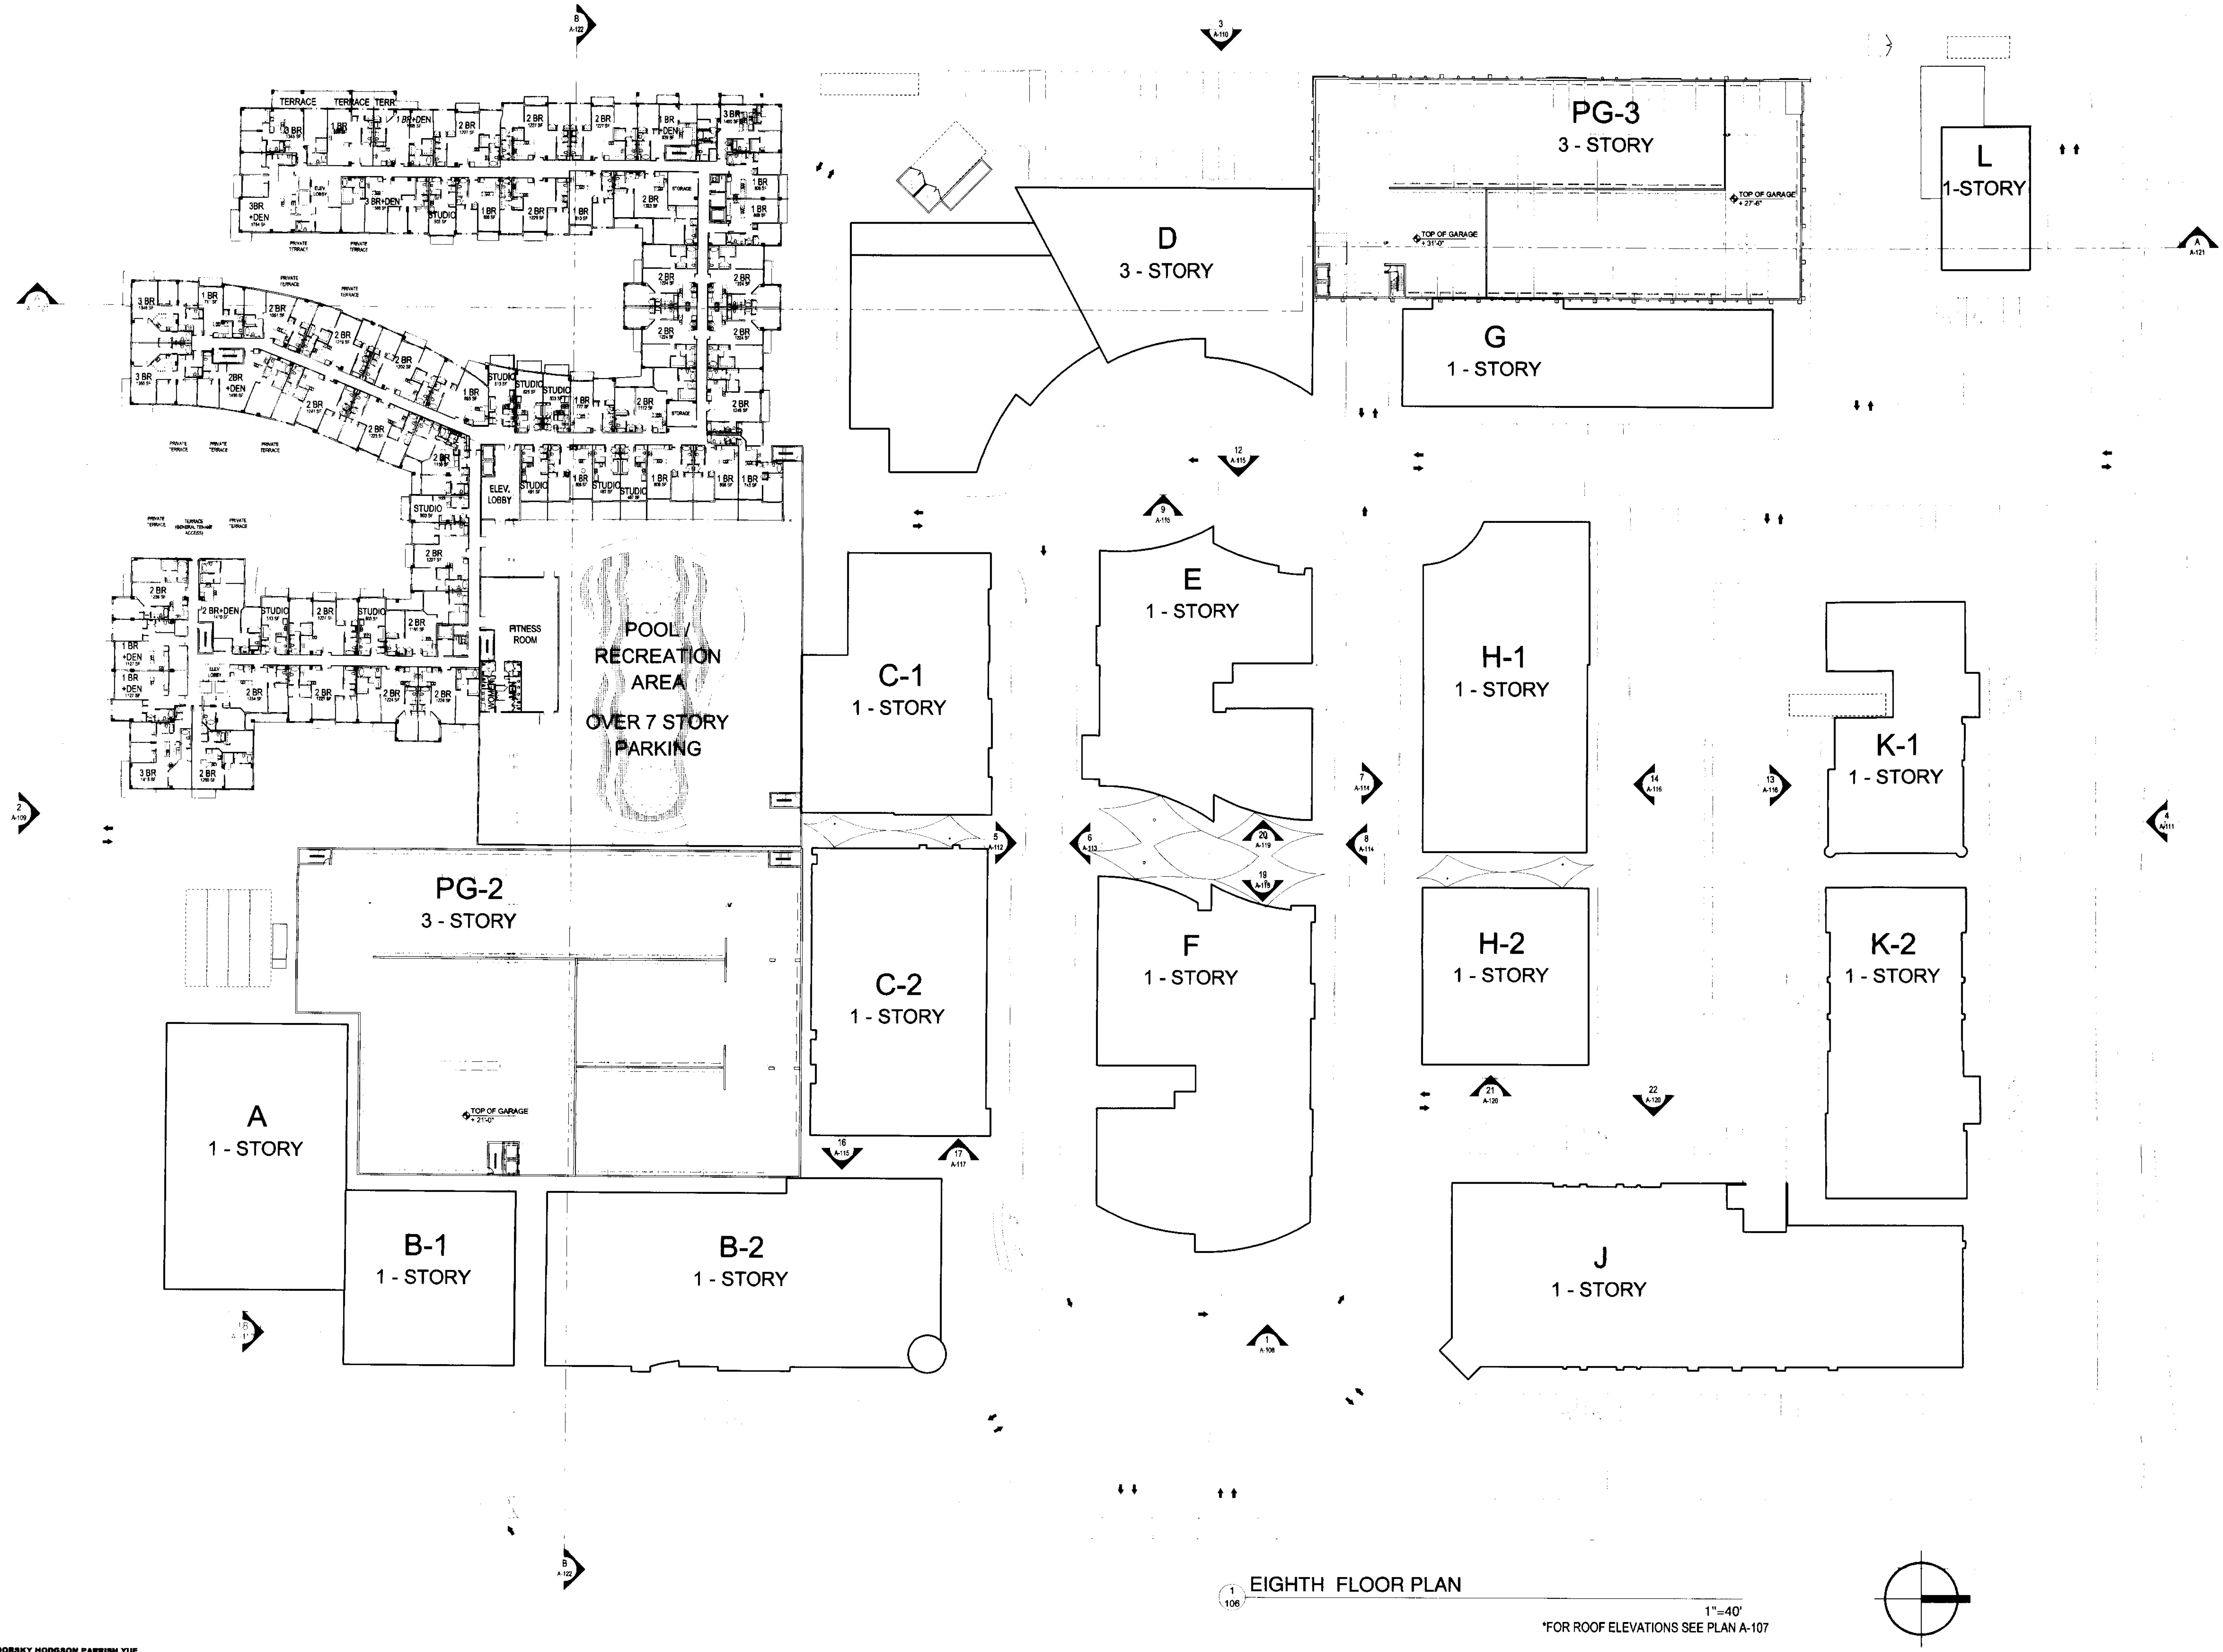

EIGHTH FLOOR PLAN

1"=40'

*FOR ROOF ELEVATIONS SEE PLAN A-107