

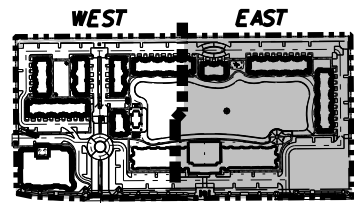


TYPE - SA & SB

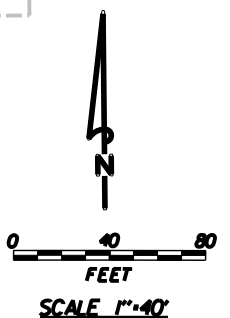

KEY MAP

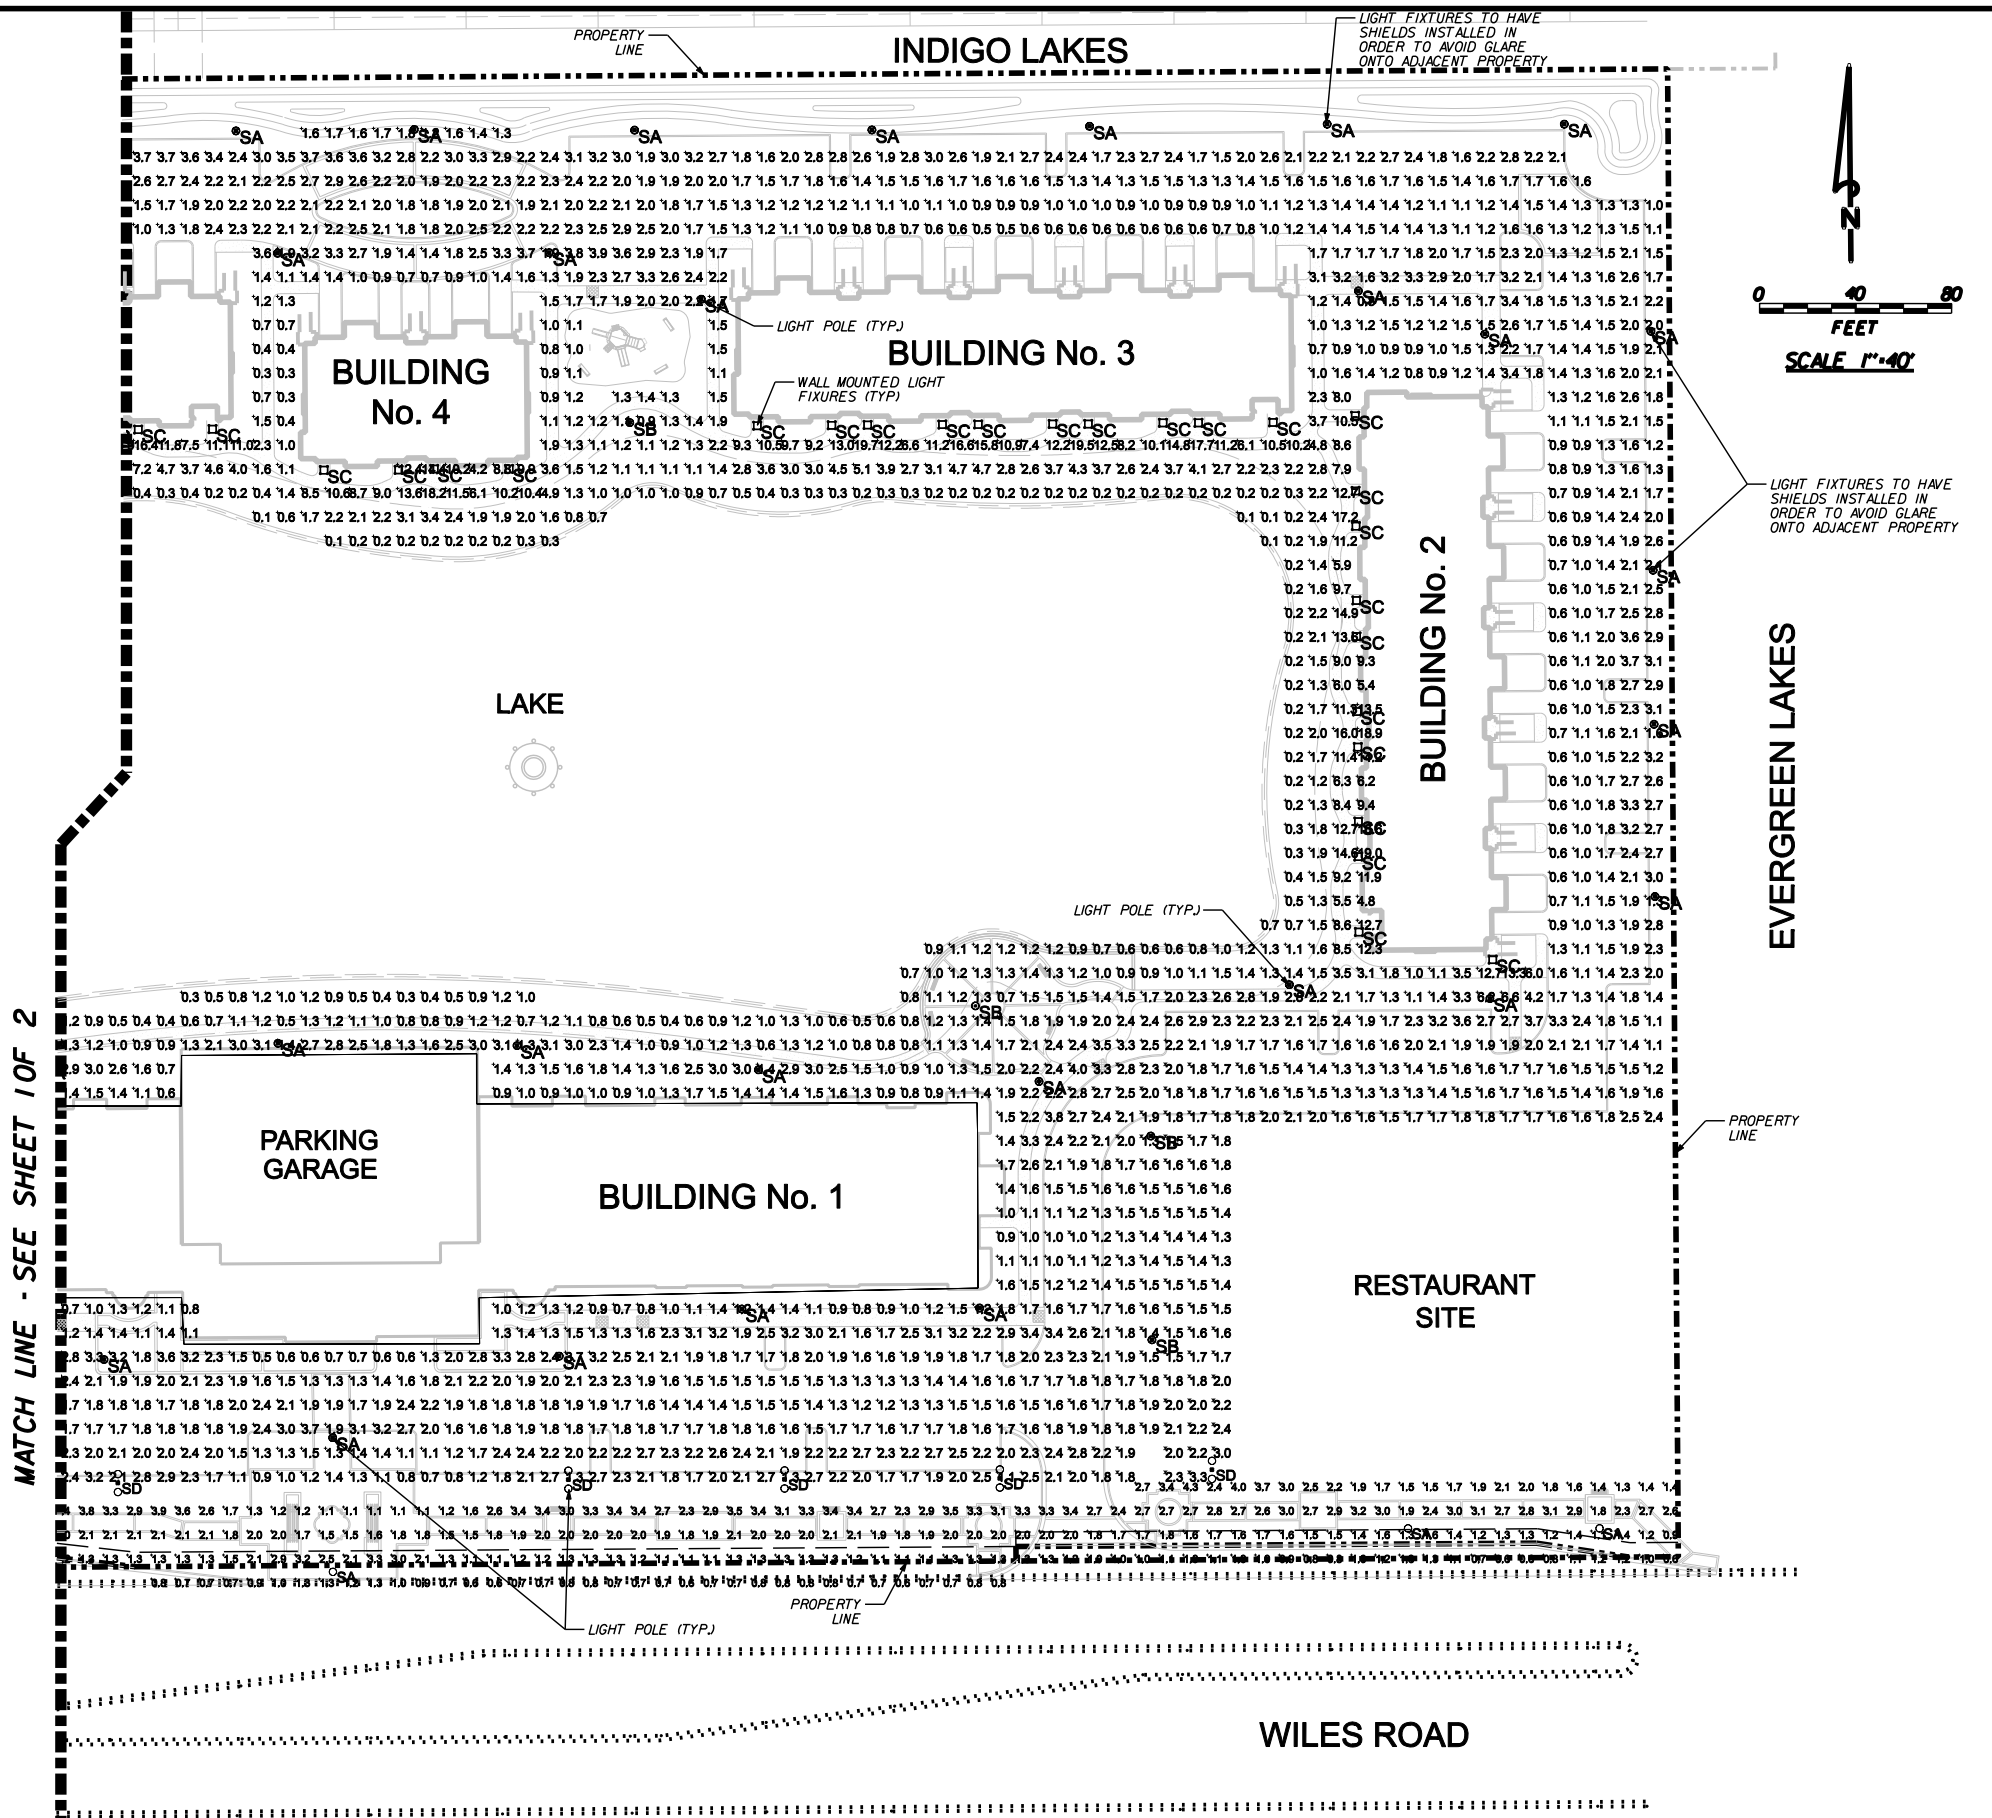

NO.	DATE	BY	REVISION
4	5/27/10	A.Q.	REVISED PER D.R.C. REVIEW COMMENTS
3	12/7/09	A.Q.	REVISED PER D.R.C. REVIEW COMMENTS
2	6/22/09	M.K.	UPDATED SITE PLAN & REVISED PER D.R.C. REVIEW COMMENTS
1	6/25/08	G.H.	REVISED PER D.R.C. REVIEW COMMENTS

Designed by:	A.Q.	Date:	4/08
Drawn by:	G.H.	Date:	4/08
Checked by:	N.S.	Date:	4/08

Approved by:	ANTONIO QUEVEDO	Date:	10/21/2010
Registered Engineer Number	59471	State of Florida	

**HSQ GROUP, INC.**  
 Consulting Engineers • Planners • Transportation  
 1489 West Palmetto Park Road, Suite 340  
 Boca Raton, Florida 33486 (561) 392-0221  
 Authorization Number 26258

<b>BEL LAGO</b>	PROJECT NUMBER	0906-14
<b>SITE PHOTOMETRIC PLAN - EAST</b>	SHEET NUMBER	2 of 2

PROJECT NUMBER	0906-14
SHEET NUMBER	2 of 2

10/21/2010  
 Z:\Projects\2009\0906-14 - Bel Lago Drawings\Lighting\090614-LIGHT001-East.dwg