
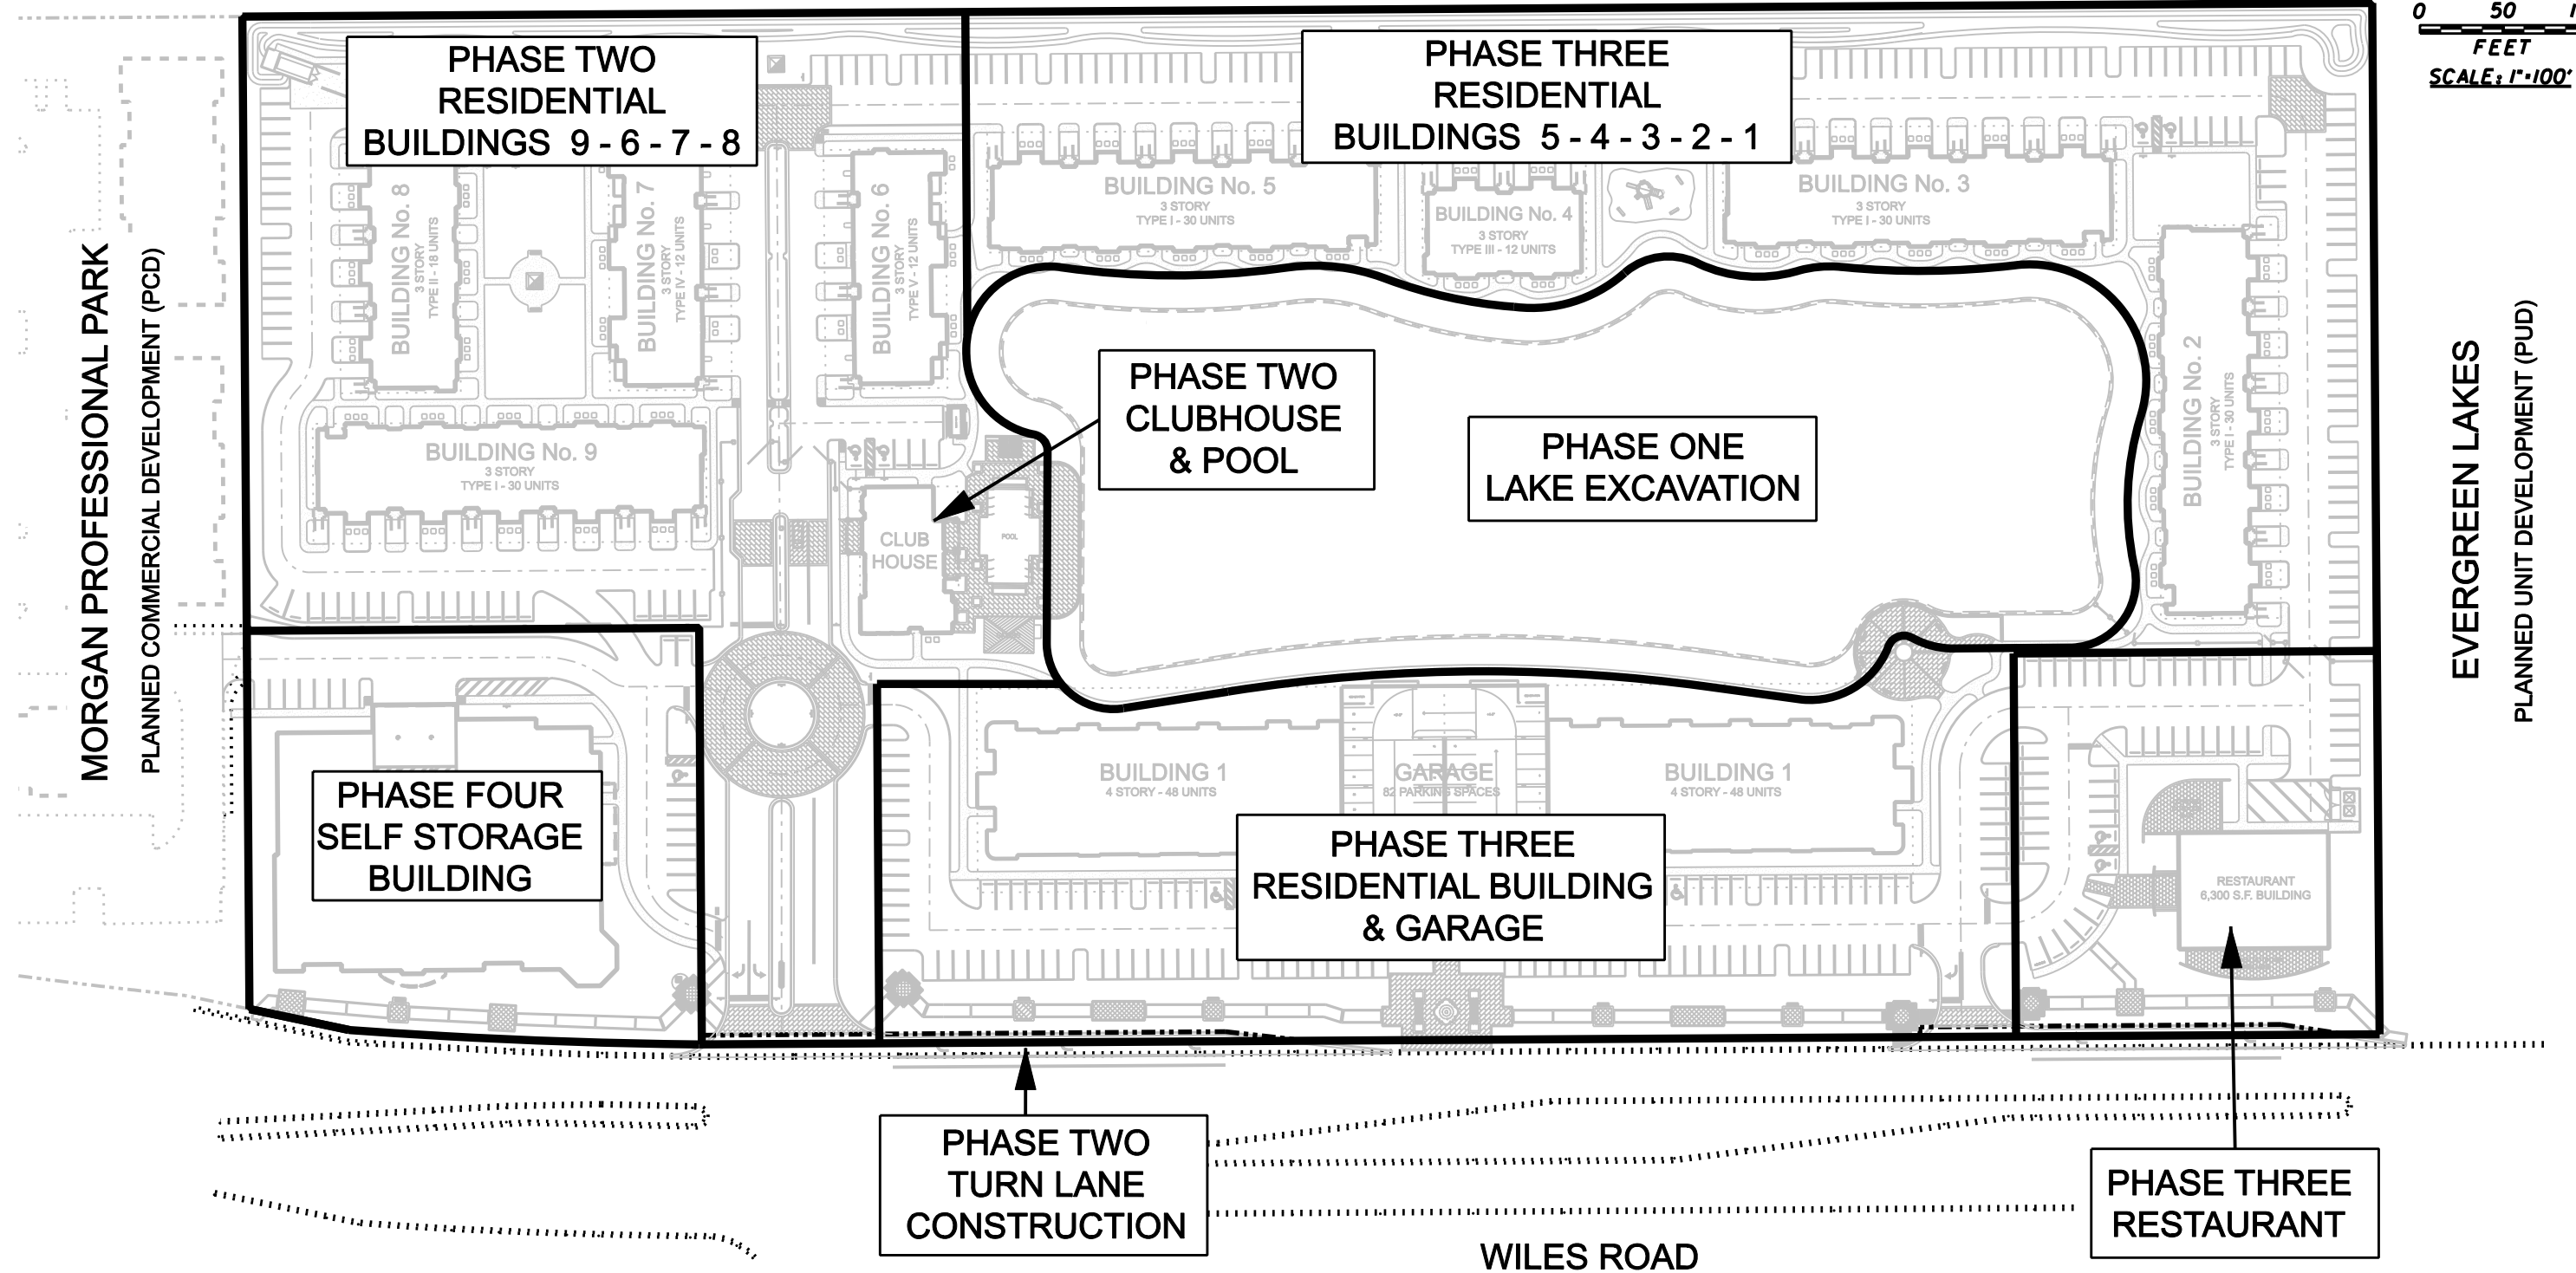


INDIGO LAKES
PLANNED UNIT DEVELOPMENT (PUD)

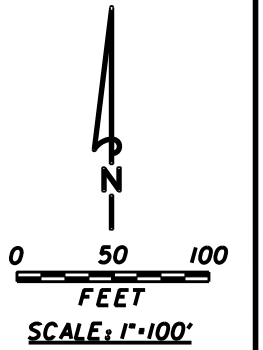

NO.	DATE	BY	REVISION
1.	6/22/09	M.K.	UPDATED SITE PLAN & REVISED PER D.R.C. REVIEW COMMENTS

Designed by: AQ. Date: 6/08
 Drawn by: G.H. Date: 6/08
 Checked by: N.S. Date: 6/08

Approved by: ANTONIO QUEVEDO
 Registered Engineer Number 59471 State of Florida
 Date: *DATE*

HSQ GROUP, INC.
 Consulting Engineers • Planners • Transportation
 1489 West Palmetto Park Road, Suite 340
 Boca Raton, Florida 33486 (561) 392-0221
 Authorization number 26258

**BEL LAGO
PHASING PLAN**

PROJECT NUMBER
0906-14
 SHEET NUMBER
1 of 1