


abbreviations :

&	AND	JAN	JANITOR
∠	ANGLE	JT	JOINT
○	CENTER LINE	K	THOUSAND (1,000)
⊘	DIAMETER OR ROUND	KIT	KITCHEN
⊥	PERPENDICULAR	LAM	LAMINATED
#	POUND OR NUMBER	LAV	LAVATORY
(E)	EXISTING	LP	LOW POINT
ABV	ABOVE	LVR	LOUVER
ACOUS	ACOUSTICAL	MACH	MACHINE
A/C	AIR CONDITIONING	MATL	MATERIAL
AD	AREA DRAIN	MAX	MAXIMUM
ADJ	ADJACENT / ADJUSTABLE	MDF	MEDIUM DENSITY FIBERBOARD
AFF	ABOVE FINISHED FLOOR	MECH	MECHANICAL
A.H.U.	AIR HANDLER UNIT	MEMB	MEMBRANE
ALUM	ALUMINUM	MEZZ	MEZZANINE
ANOD	ANODIZED	MFR	MANUFACTURE
APPROX	APPROXIMATE (LY)	MH	MAN HOLE
		MIN	MINIMUM
BD	BOARD	MIR	MIRROR
BITUM	BITUMINOUS	MISC	MISCELLANEOUS
BLDG	BUILDING	MO	MASONRY OPENING
BLK	BLOCK	MTD	MOUNTED
BLKG	BLOCKING	MTL	METAL
BM	BEAM	MUL	MULLION
BOT	BOTTOM		
BRZ	BRONZE		
		N	NORTH
C	CHANNEL	NIC	NOT IN CONTRACT
CAB	CABINET	NO OR #	NUMBER
CB	CATCH BASIN	NOM	NOMINAL
CER	CERAMIC	NTS	NOT TO SCALE
CJ	CONTROL JOINT		
CLG	CEILING	OA	OVERALL
CL	CLOSET	OC	ON CENTER
CLR	CLEAR	OD	OUTSIDE DIAMETER
CLR OPG	CLEAR OPENING	OFF	OFFICE
CMU	CONCRETE MASONRY UNIT	OPG	OPENING
CNTR	COUNTER	OPH	OPPOSITE HAND
CO	CLEAN OUT		
COL	COLUMN	PARTN	PARTITION
CONC	CONCRETE	PED.	PEDESTAL
CONSTR.	CONSTRUCTION	PH	PENTHOUSE
CONT	CONTINUOUS	PI	PROPERTY LINE
CONTR	CONTRACTOR	PLAM	PLASTIC LAMINATE
COORD	COORDINATE	PLAS	PLASTER
CPT	CARPET	PLBG	PLUMBING
CT	CERAMIC TILE	PLYWD	PLYWOOD
CTR	CENTER	PNL	PANEL
		PNT	PAINT
D	DRYER	PR	PAIR
DBL	DOUBLE	PREFAB	PREFABRICATED
DEPT	DEPARTMENT	PREFIN	PRE-FINISHED
DET	DETAIL	PS	PULL STATION
DF	DRINKING FOUNTAIN	PSF	POUNDS PER SQUARE FOOT
DD	DECK DRAIN	PSI	POUNDS PER SQUARE INCH
DIAM	DIAMETER	PT	PRESSURE TREATED
DIM	DIMENSION	PRE-CAST	PREFABRICATED
DISP	DISPENSER	PVMT	PAVEMENT
DN	DOWN	PVC	POLYVINYL CHLORIDE
DR	DOOR		
DS	DOWNSPOUT	QT	QUARRY TILE
DTL	DETAIL	QTY	QUANTITY
DW	DISHWASHER		
DWG	DRAWING		
		R	RISER OR RADIUS
E	EAST	R&S	ROD AND SHELF
EA	EACH	RA	RETURN AIR
EJ	EXPANSION JOINT	RAD	RADIUS
EL	ELEVATION	RD	ROOF DRAIN
ELECT	ELECTRICAL	REF	REFRIGERATOR
ELEV	ELEVATOR	REIN	REINFORCED
EMER	EMERGENCY	REQ'D	REQUIRED
ENCL	ENCLOSE/ENCLOSURE	REV	REVISION
EQ	EQUAL	RM	ROOM
EQUIP	EQUIPMENT	RO	ROUGH OPENING
EW	ELECTRIC WATER COOLER	RTU	ROOF TOP UNIT
EXIST	EXISTING	RWL	RAIN WATER LEADER
EXP	EXPANSION		
EXT	EXTERIOR	S	SOUTH
		SC	SOLID CORE
FA	FIRE ALARM	SCHED	SCHEDULE
FD	FLOOR DRAIN	SEC	SECTION
FDN	FOUNDATION	SHT	SHEET
FE	FIRE EXTINGUISHER	SHWR	SHOWER
FEC	FIRE EXTINGUISHER CABINET	SM	SIMILAR
FF/FIN.FLR.	FINISH FLOOR	SPEC	SPECIFICATION
FHC	FIRE HOSE CABINET	SQ	SQUARE
FHR	FIRE HOSE RACK	SS	STAINLESS STEEL
FIXT	FIXTURE	SSK	SERVICE SINK
FLR	FLOOR	STA	STATION
FLUOR	FLUORESCENT	STD	STANDARD
FND	FOUNDATION	STL	STEEL
FP	FIRE PROOF	STOR	STORAGE
FRT	FIRE RETARDANT TREATED	STRUCT	STRUCTURAL/STRUCTURE
FS	FULL SIZE	SUSP	SUSPENDED
FT	FOOT	SYM	SYMMETRICAL
FTG	FOOTINGS		
FURN	FURNITURE	T	TREAD OR TOILET
FURR	FURRING	TELE	TELEPHONE
		TEMP	TEMPERED
G	GALVE	T&G	TONGUE AND GROOVE
GALV	GALVANIZED	THK	THICK (NESS)
GC	GENERAL CONTRACTOR	TOP	TOP OF
GL	GLASS	TYP	TYPICAL
GL BLK	GLASS BLOCK		
GND	GROUND	UC	UNDERCUT
GRND	GROUND	UNF	UNFINISHED
GYP	GYPSPUM	UNON	UNLESS OTHERWISE NOTED
GYP BD	GYPSPUM BOARD	UR	URINAL
		VCT	VINYL COMPOSITION TILE
HB	HOSE BIBB	VF	VERIFY IN FIELD
HO	HANDICAPPED		
HDWR	HARDWARE	W	WASHER
HM	HOLLOW METAL	W/O	WITHOUT
HP	HIGH POINT	WC	WATER CLOSET
HR	HOUR (S)	WD	WOOD
HT	HEIGHT	WR	WATER RESISTANT
HVAC	HEATING/VENTILATING	WSC	WANSOAT
		WT	WEIGHT
		WWF	WELDED WIRE FABRIC

symbols :

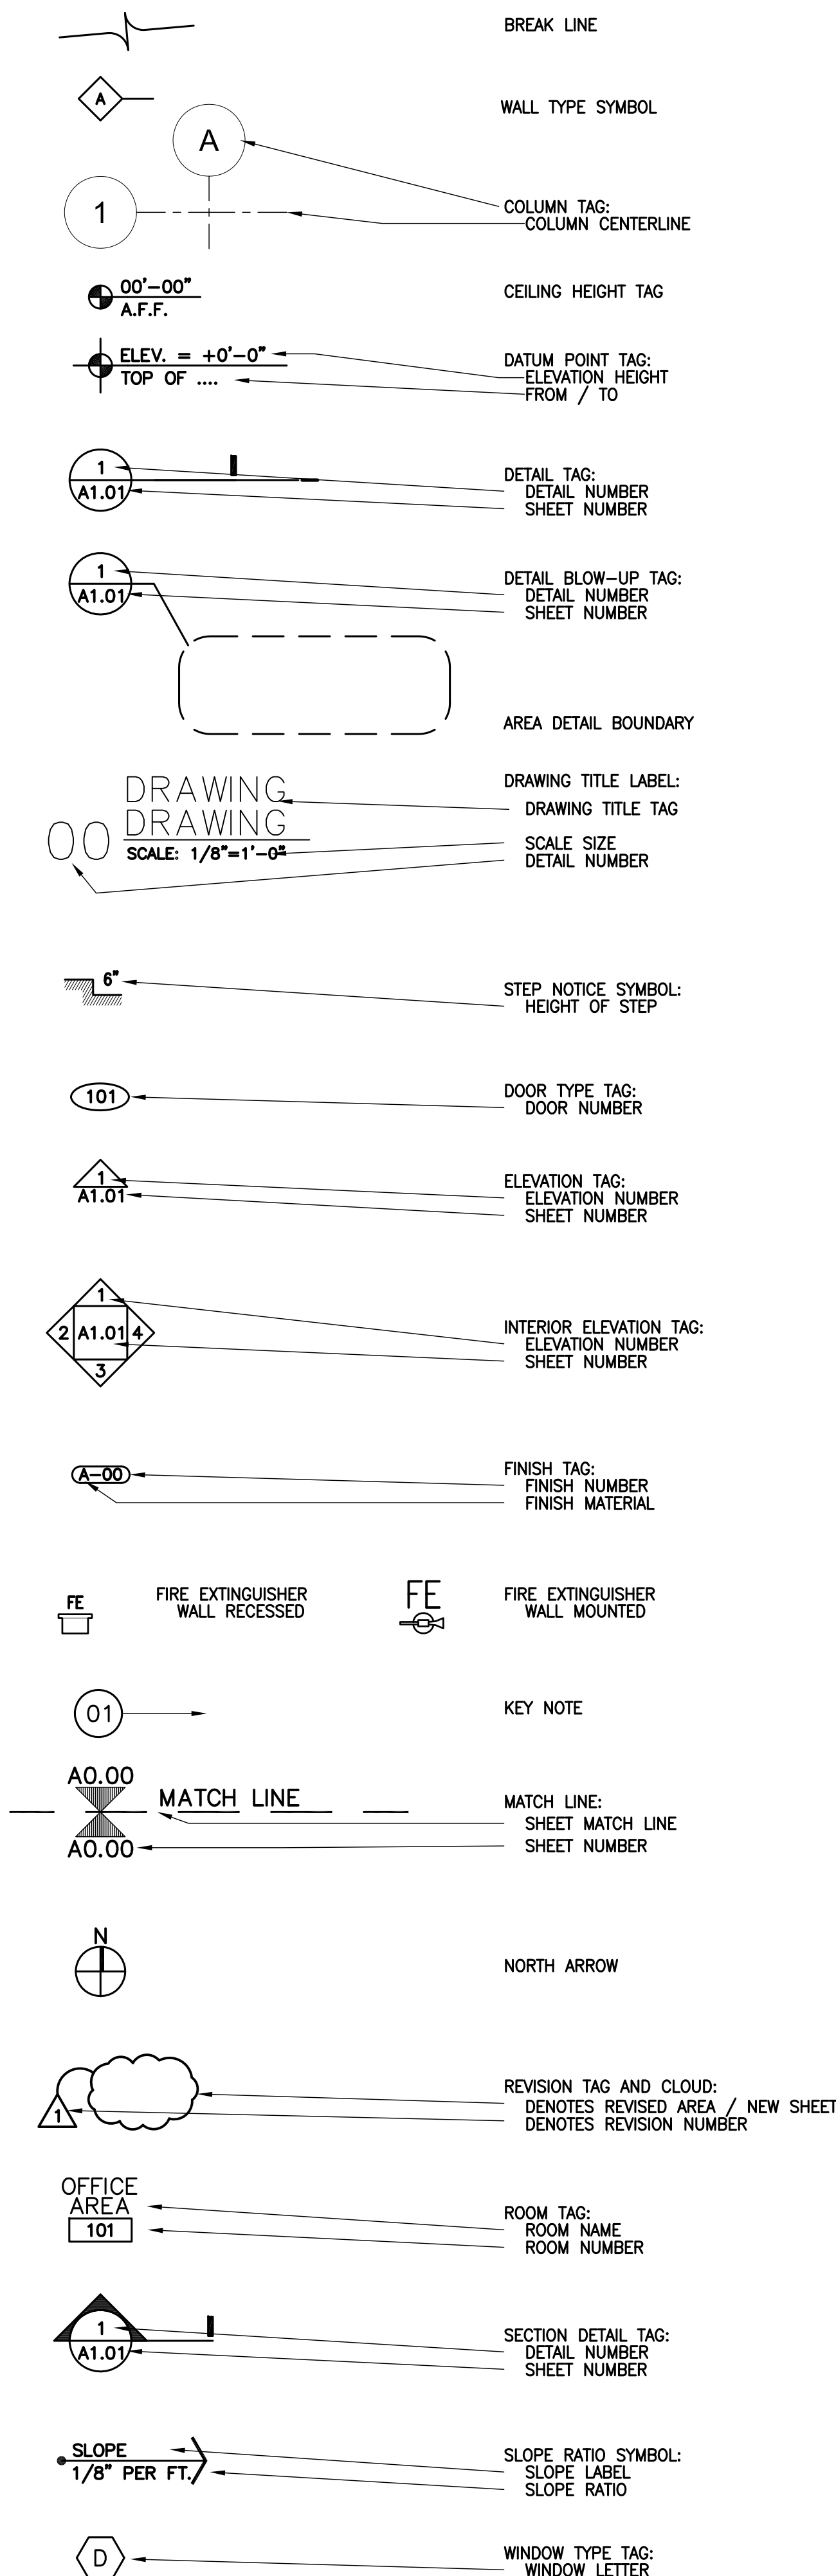

index of drawings :

NUMB.	SHEET	DESCRIPTION:	11/18/2019 (ADMIN. SITE APPROVAL)	03/03/2020 (AREV 1)	06/05/2020 (AREV 2)
001	CS.00	COVER SHEET			
002	CS.01	ABBREVIATIONS, SYMBOLS & INDEX OF DRAWINGS			
003	CS.01	ARCHITECTURAL SITE PHASING PLAN			
070	SUV1.0	SURVEY			
071	SUV2.0	SURVEY			
072	SUV3.0	BASEMENT LETTER (SENT ON BEISOM 1)			
073	SUV4.0	SURVEY - EXISTING RAMP DETAILS (NEW)			
ARCHITECTURAL					
090	A2.01	DEMOLITION & PROPOSED ELEVATIONS (W/ COLOR FINISHES)			
091	A2.02	DEMOLITION & PROPOSED ELEVATIONS (W/ COLOR FINISHES)			
092	A2.03	DEMOLITION & PROPOSED ELEVATIONS (W/ COLOR FINISHES)			
093	A2.04	PROPOSED 3D "CONCEPTUAL" RENDERINGS & FINISHES			
TREE DISPOSITION PLAN :					
170	TD.1	TREE SURVEY & DISPOSITION PLAN			
LANDSCAPING PLAN :					
190	LP.1	LANDSCAPING - PLANTING PLAN			
191	LP.2	LANDSCAPING - PLANTING DETAILS & PLANT LIST			
192	LP.3	LANDSCAPING - COCONUT CREEK STAND LANDSCAPING NOTES			
193	LH.1	LANDSCAPING - HARDSCAPE PLAN (NEW)			
194	LH.2	LANDSCAPING - HARDSCAPE DETAILS (NEW)			
195	LL	LANDSCAPING - LIGHTING PLAN (NEW)			
PHOTOMETRIC PLAN :					
190	PH.1.0	PHOTOMETRIC PLAN - STANDARD			

MODIS architects
 4955 SW 75th Avenue
 Miami, Florida 33155
 Florida Corp. #A#26001777
 t. 786.879.8882
 f. 786.350.1515
 e. MODIS@MODISArchitects.com

project info :

TOWNSHIP PLAZA
Facade Renovation
 4400 W. SAMPLE RD.
 COCONUT CREEK, FL 33073

client : **S2**
 S2 DEVELOPMENT
 18851 NE 29th Ave, Suite 1011
 Aventura, FL 33180
 www.s2development.com

seal :

ROBERT K. MORISSETTE, AIA, NCARB, LEED AP BD+C, COP
 FLORIDA REGISTERED ARCHITECT # AR 93259

THIS DRAWING IS THE PROPERTY OF MODIS ARCHITECTS, LLC AND IS NOT TO BE REPRODUCED OR COPIED IN WHOLE OR IN PART WITHOUT THE PRIOR WRITTEN CONSENT OF MODIS ARCHITECTS, LLC. THIS DRAWING IS ONLY TO BE USED FOR THE PROJECT AND SITE SPECIFICALLY IDENTIFIED HEREIN AND IS NOT TO BE USED FOR ANY OTHER PROJECT. SCALE AND AREA AS STATED. THE CONTRACTOR SHALL CAREFULLY REVIEW ALL DIMENSIONS AND CONDITIONS SHOWN HEREON AND AT ONCE NOTIFY THE ARCHITECT AS TO ANY ERRORS, OMISSIONS, AND/OR INCONSISTENCIES HEREIN MAY DISCOVER. COPYRIGHT © 2017 MODIS ARCHITECTS, LLC

revisions :

2	06/08/2020	DRC COMMENTS
1	03/03/2020	DRC COMMENTS

drawing data :

ABBREVIATIONS, SYMBOLS & INDEX OF DRAWINGS

project number : #19077

drawn by : RC proj. manager : YP

drawing scale : As Shown drawing date : 03/11/2020

phase : CONST. DOCUMENTS

sheet number : **CS.01**

Copyright © 2011 | MODIS ARCHITECTS, LLC | 4400 W. SAMPLE RD., COCONUT CREEK, FL 33073 | TEL: 786.879.8882 | FAX: 786.350.1515 | WWW.MODISARCHITECTS.COM