


TOWN CENTER PLAZA
4400 West Sample Road, Coconut Creek, Florida 33066
LIGHTING PLAN

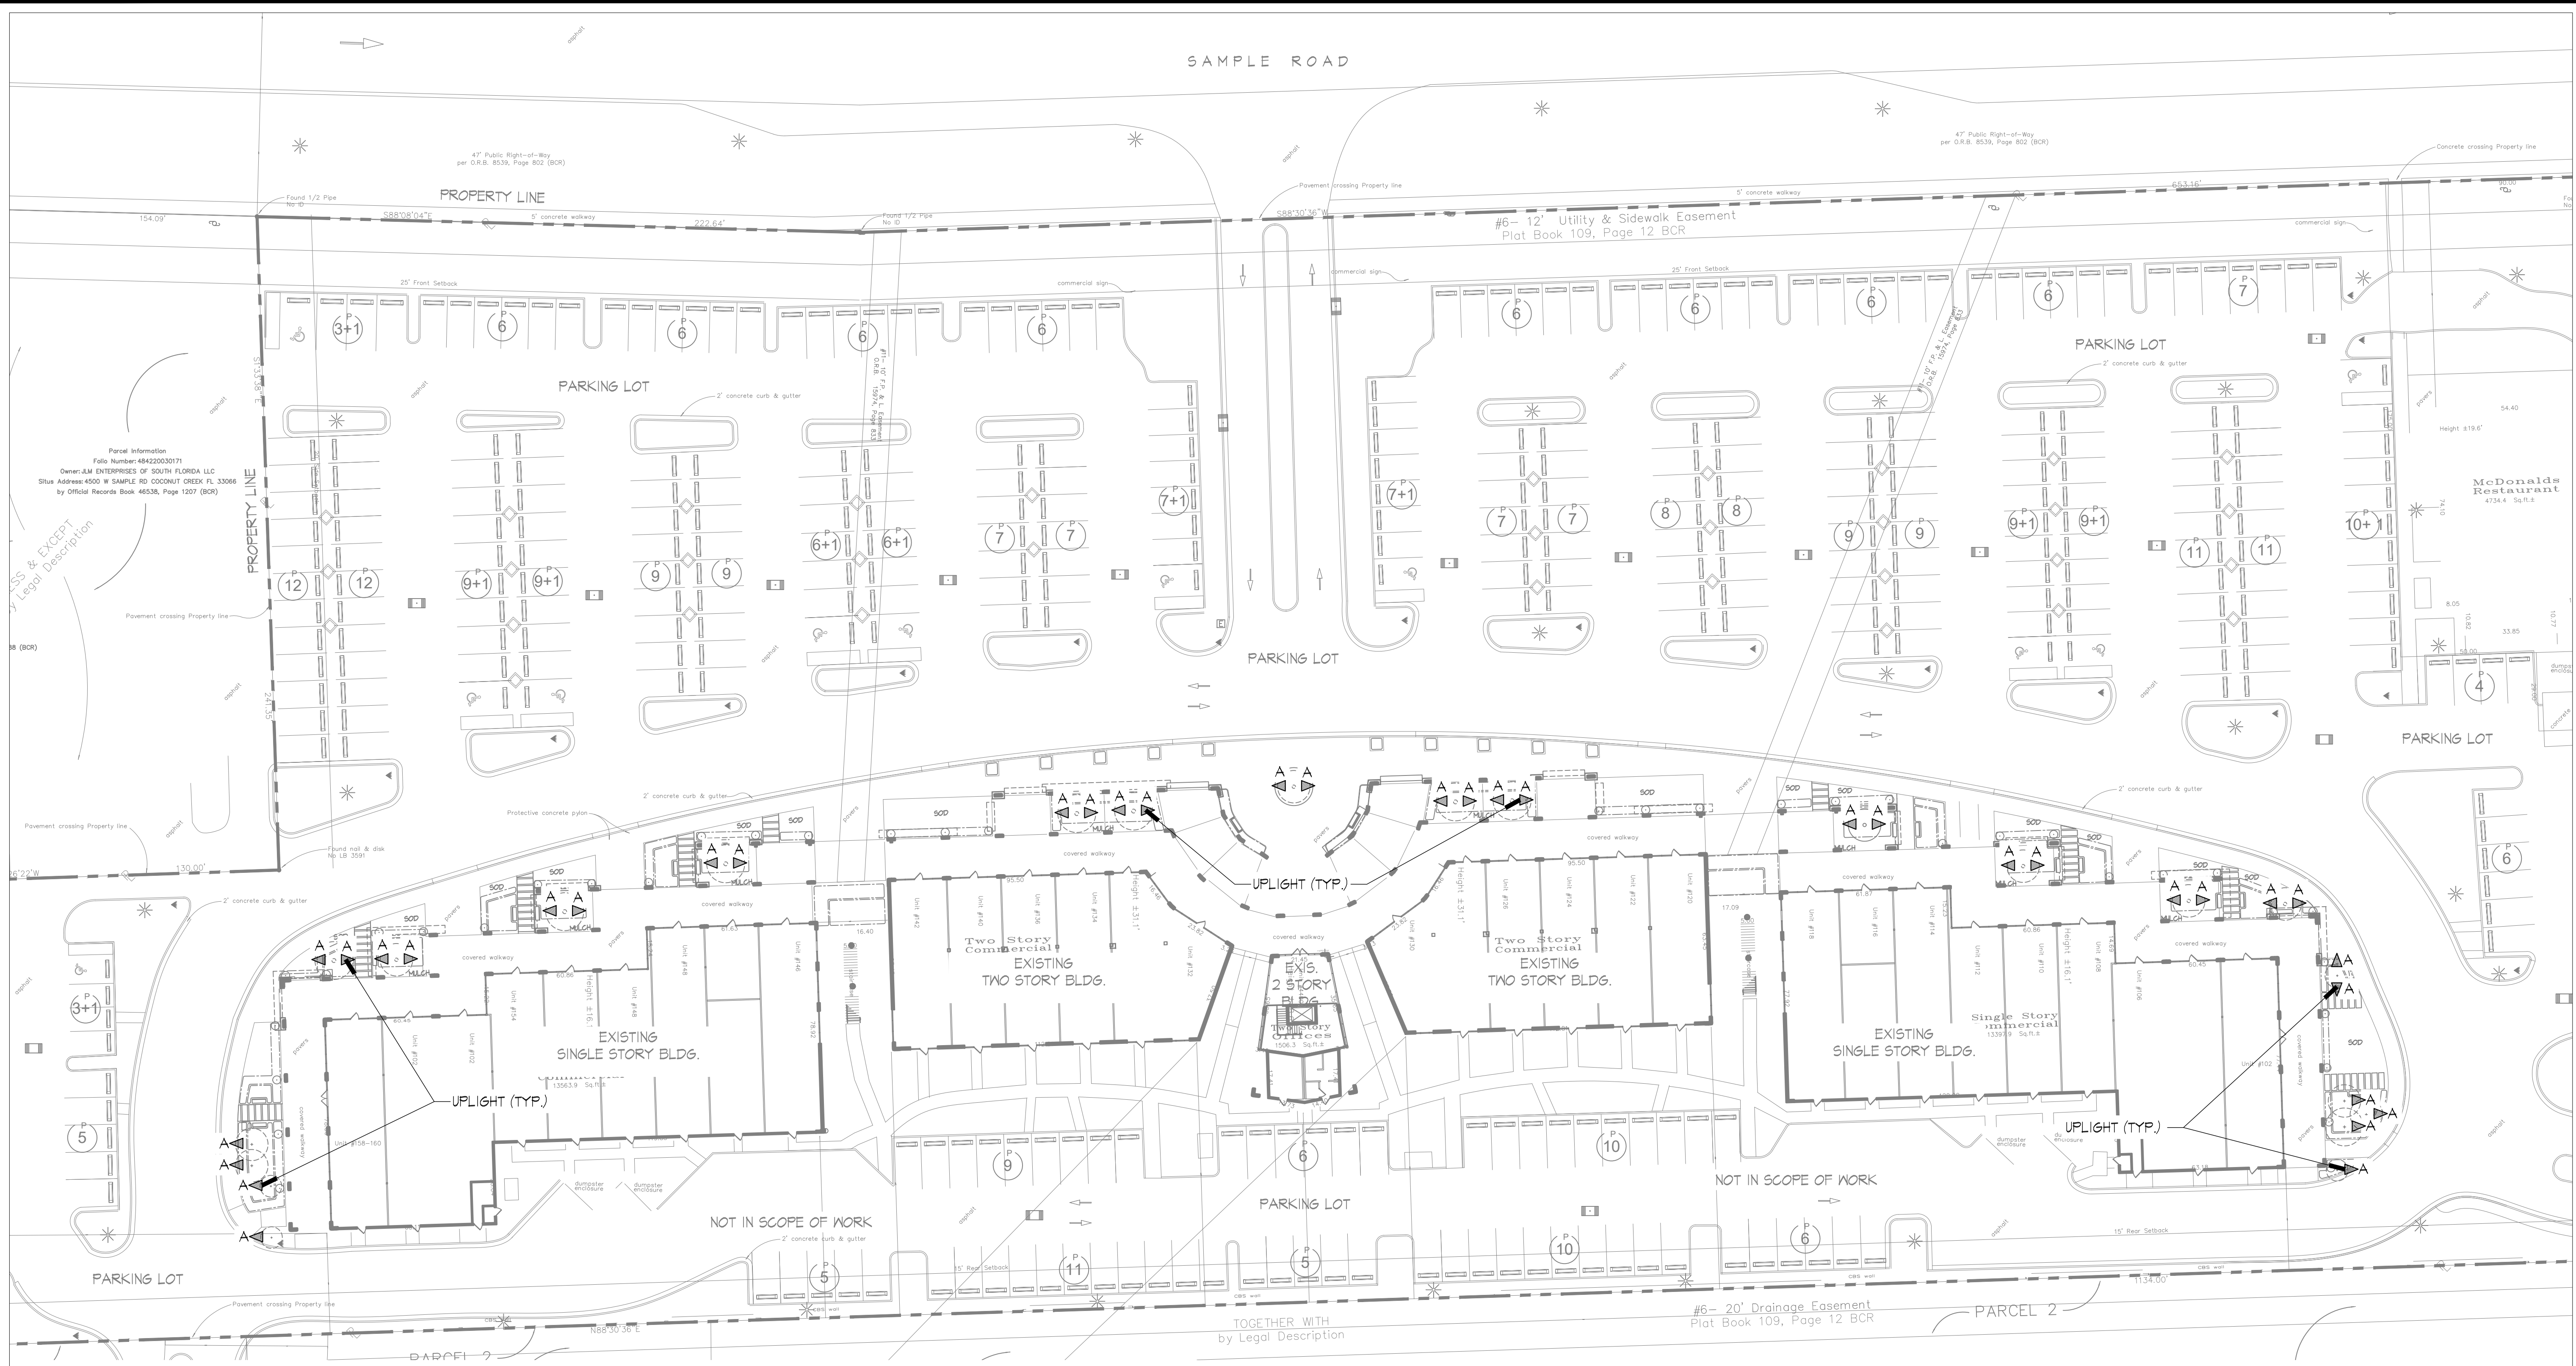

LANDSCAPE LIGHTING SCHEDULE

	SYMBOL	QTY TOTAL	FIXTURE DESCRIPTION	TYPE OF MOUNT	MOUNTING HEIGHT	REMARKS
A	▲	34	ALUM-DS-8W LED/3K-SP-A9-BLW-A	STAKE	18" HT.	UPLIGHT

REVISIONS:

06-05-2020	DRC COMMENTS

November 18, 2019
DATE
S.O.Q.
DRAWN BY:
M.J.
APPROVED BY:

This drawing is the property of Design Studio Boca, and is an instrument of service not to be reproduced in whole or in part without the express written permission of same.

