
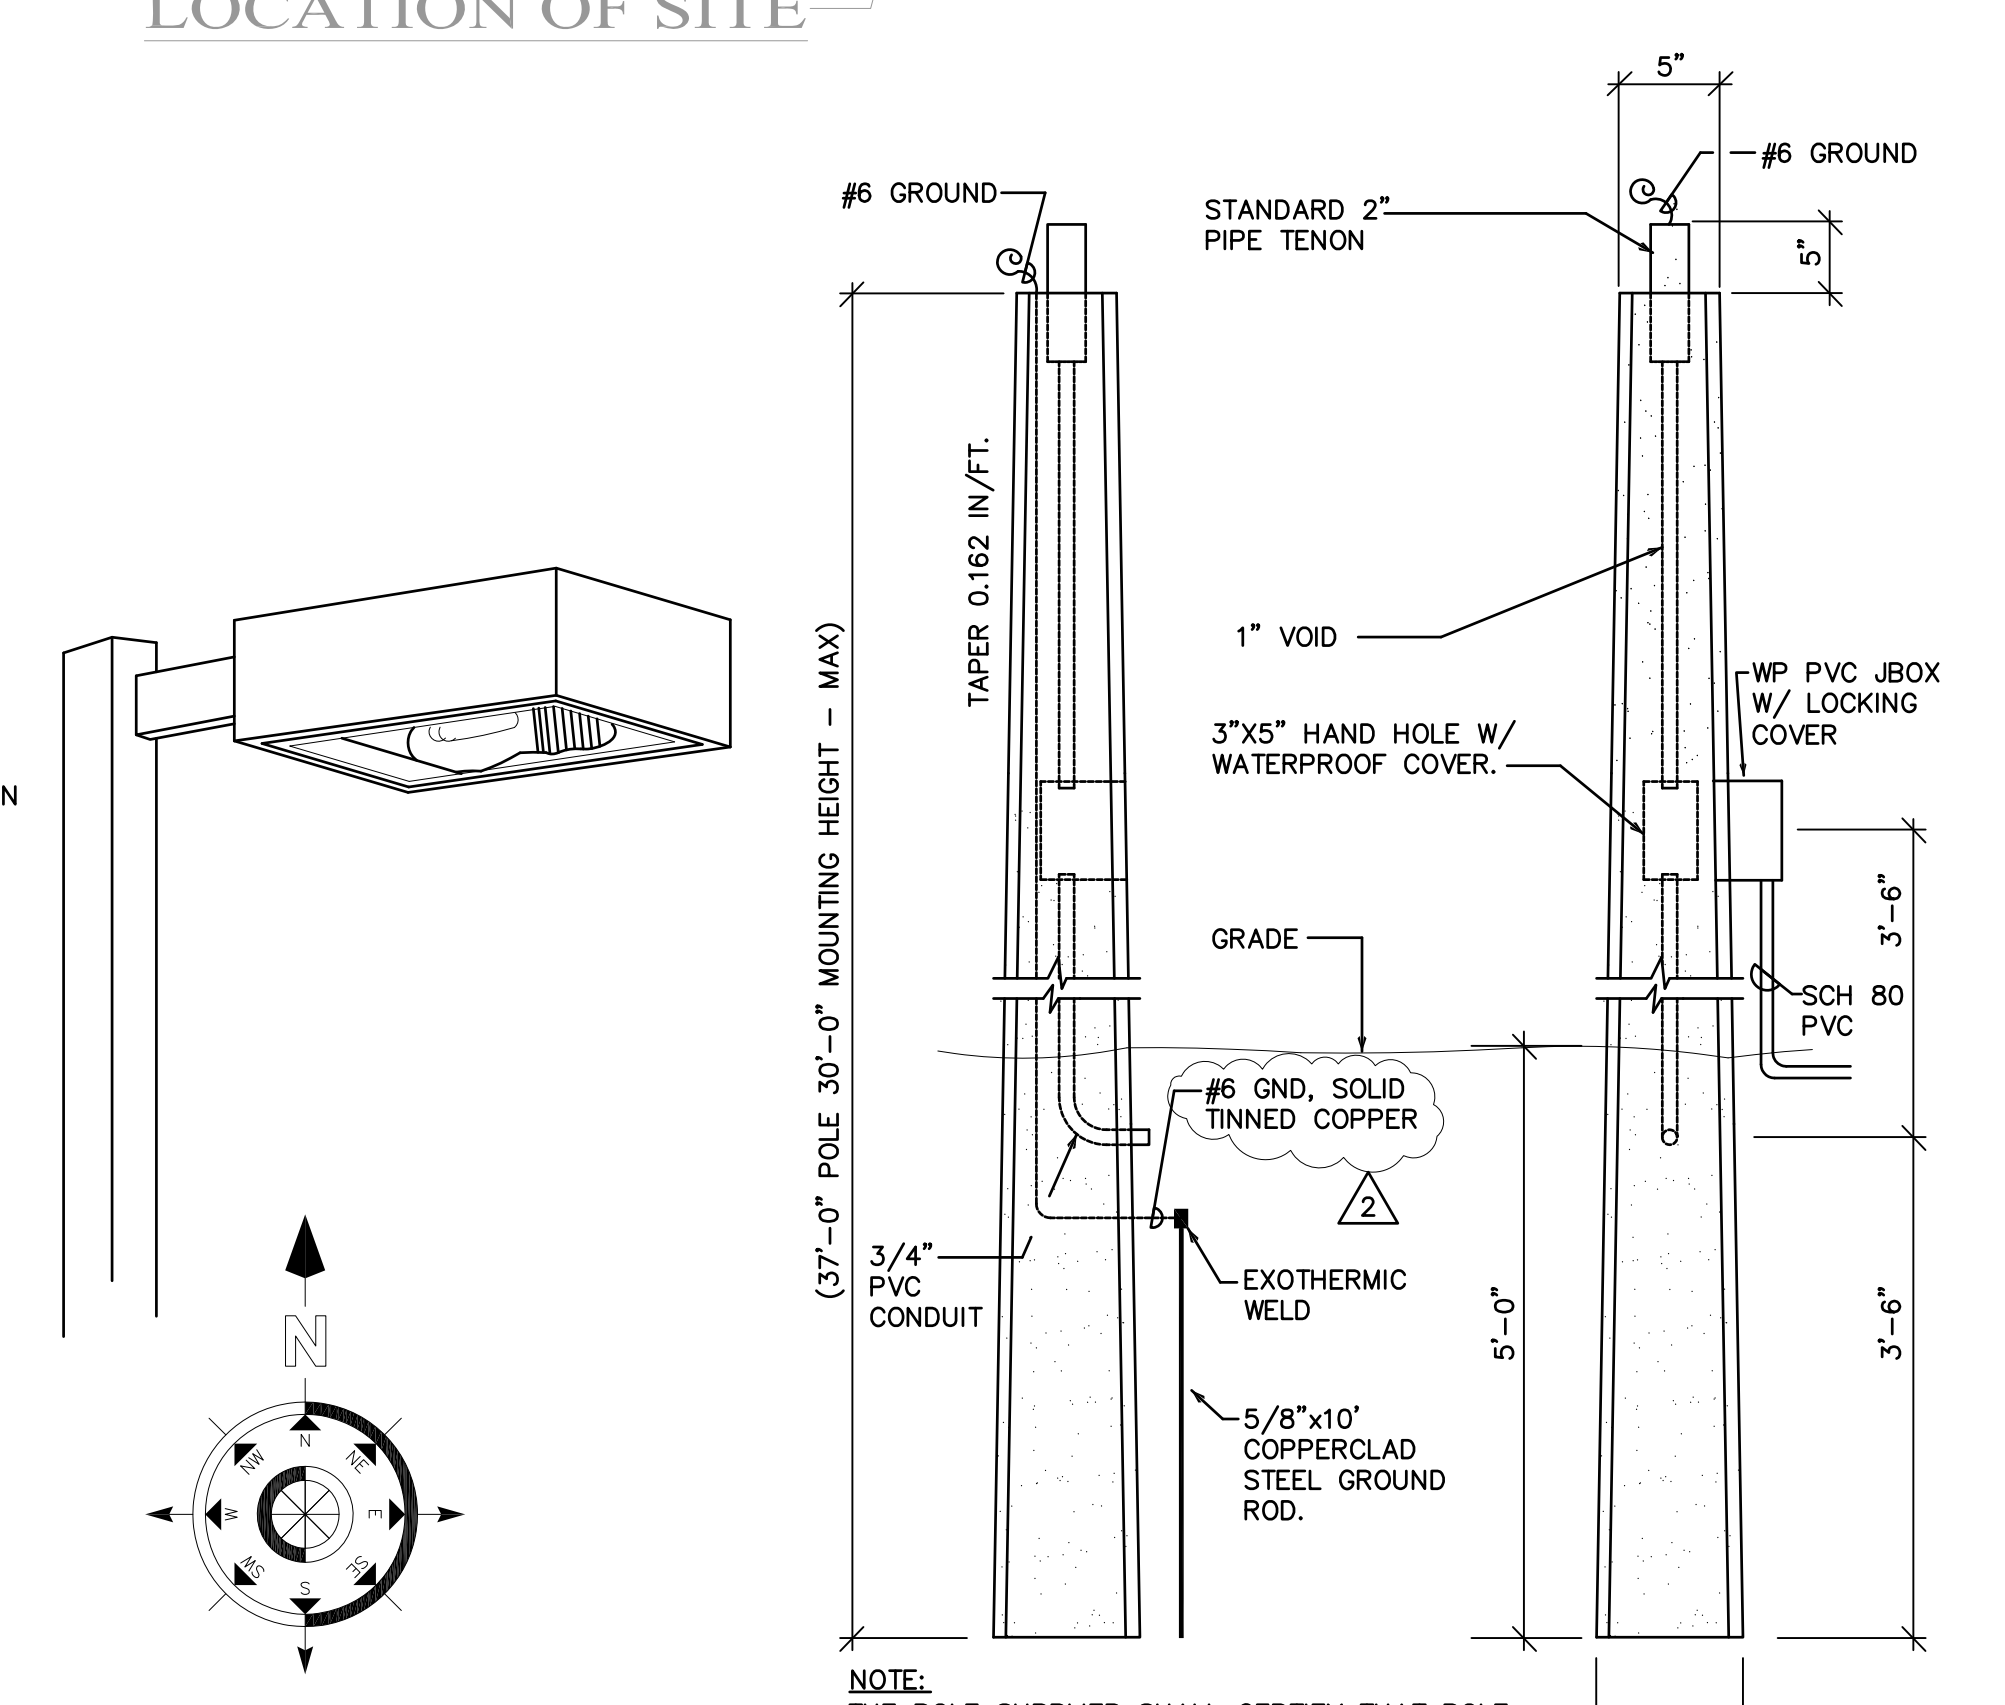
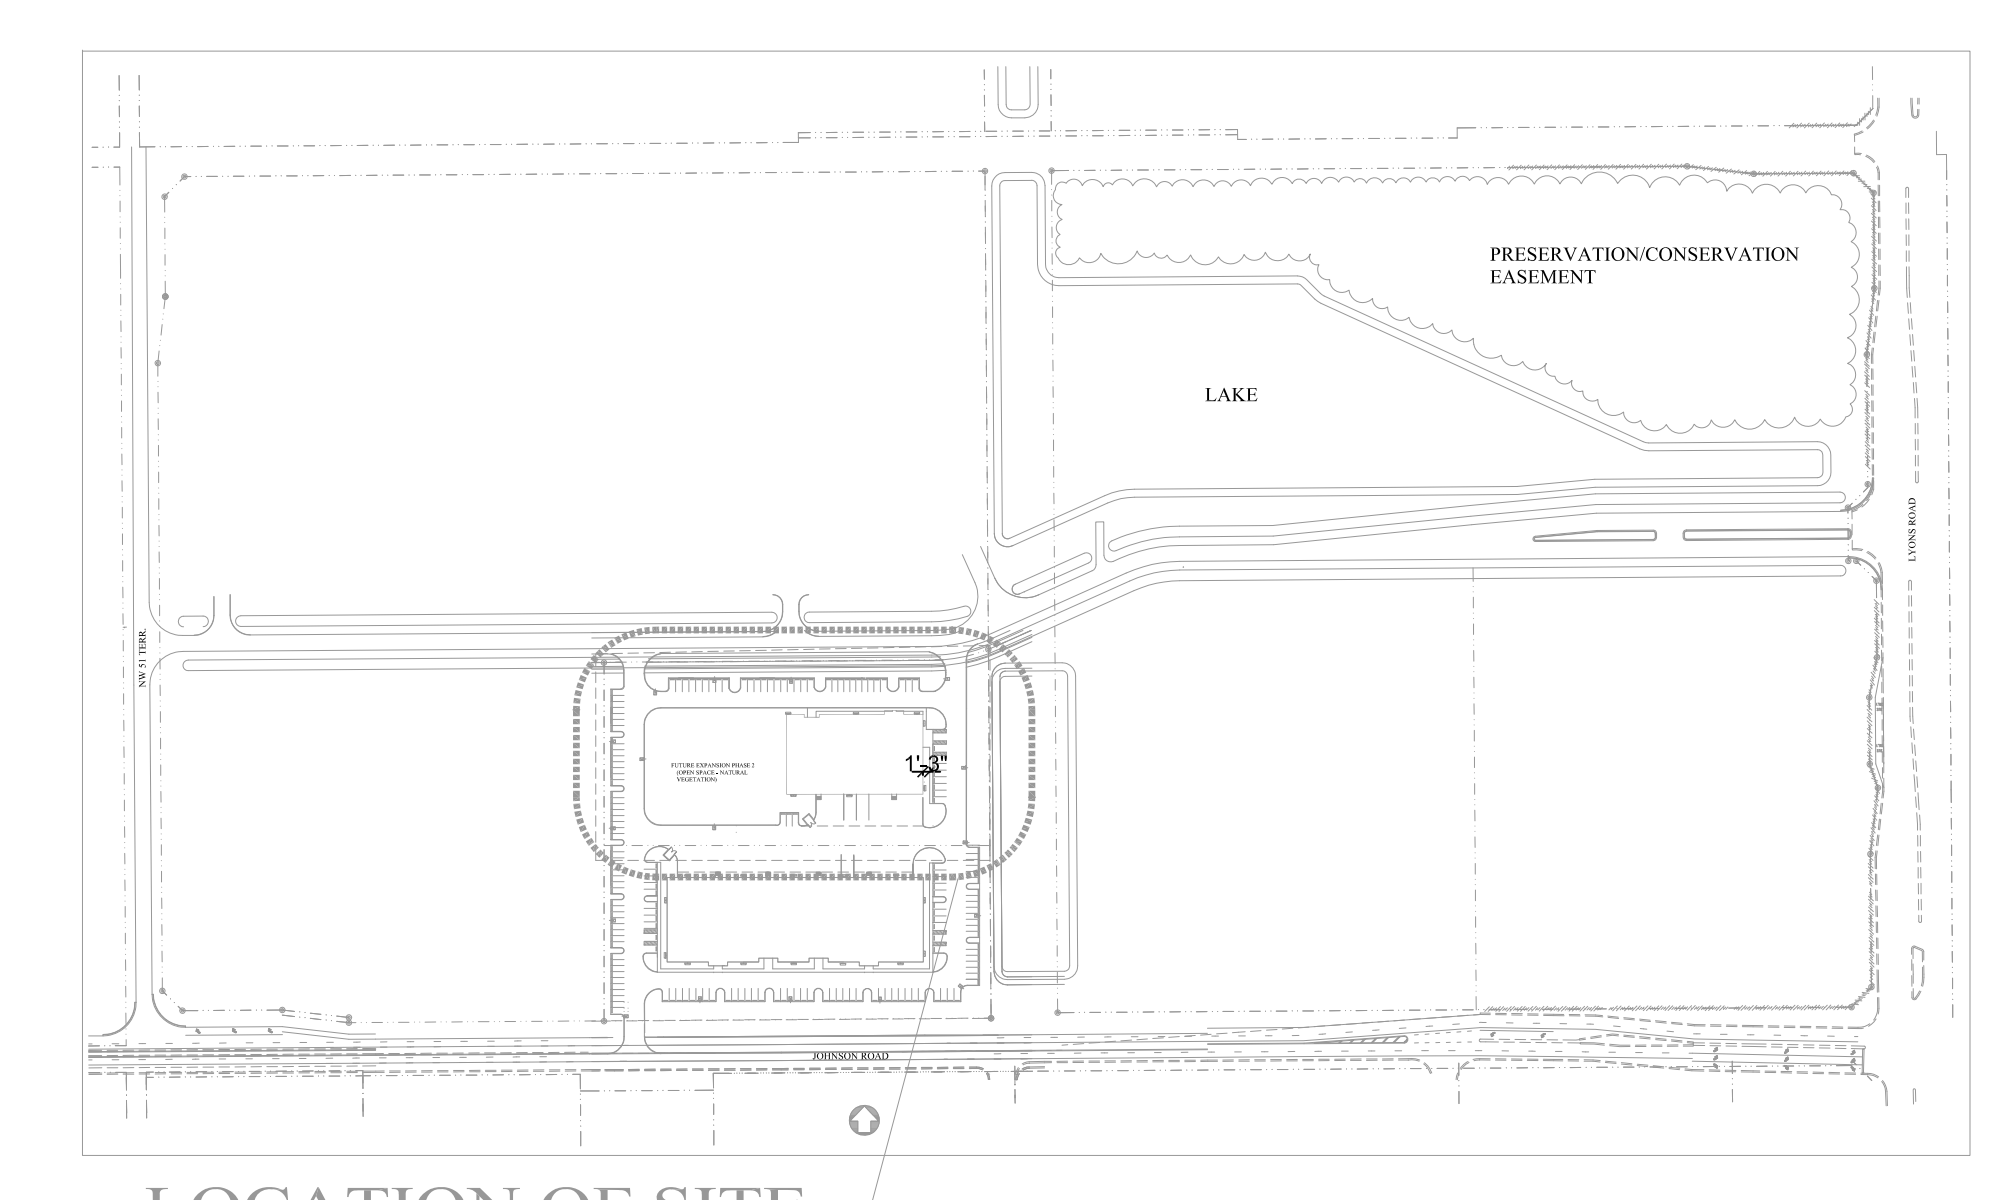


In accepting and utilizing any form of media generated and provided by T&T Design and Development Inc. the Recipient covenants and agrees that all such drawings and data are instruments of service of T&T Design and Development Inc. who shall be deemed the author of the drawings and data, and shall retain all common law and other rights, including copyrights. The Recipient agrees to waive all claims against T&T Design and Development Inc. resulting in any way from any unauthorized changes or reuse of the drawings and data for any other project or purpose. The Recipient further agrees not to use the documents in whole or in part for any purpose or project other than the project which is the subject of this Agreement. The Recipient agrees to indemnify and hold T&T Design and Development Inc. harmless from any damage, liability or cost, including reasonable attorney's fees and costs of defense, arising from any changes made by anyone other than T&T Design and Development Inc. or from any reuse of the drawings and data without the prior written consent of T&T Design and Development Inc. Under no circumstances shall transfer of the drawings and other instruments of service on electronic media for use by the Recipient be deemed a sale by merchantability and fitness for any particular purpose.

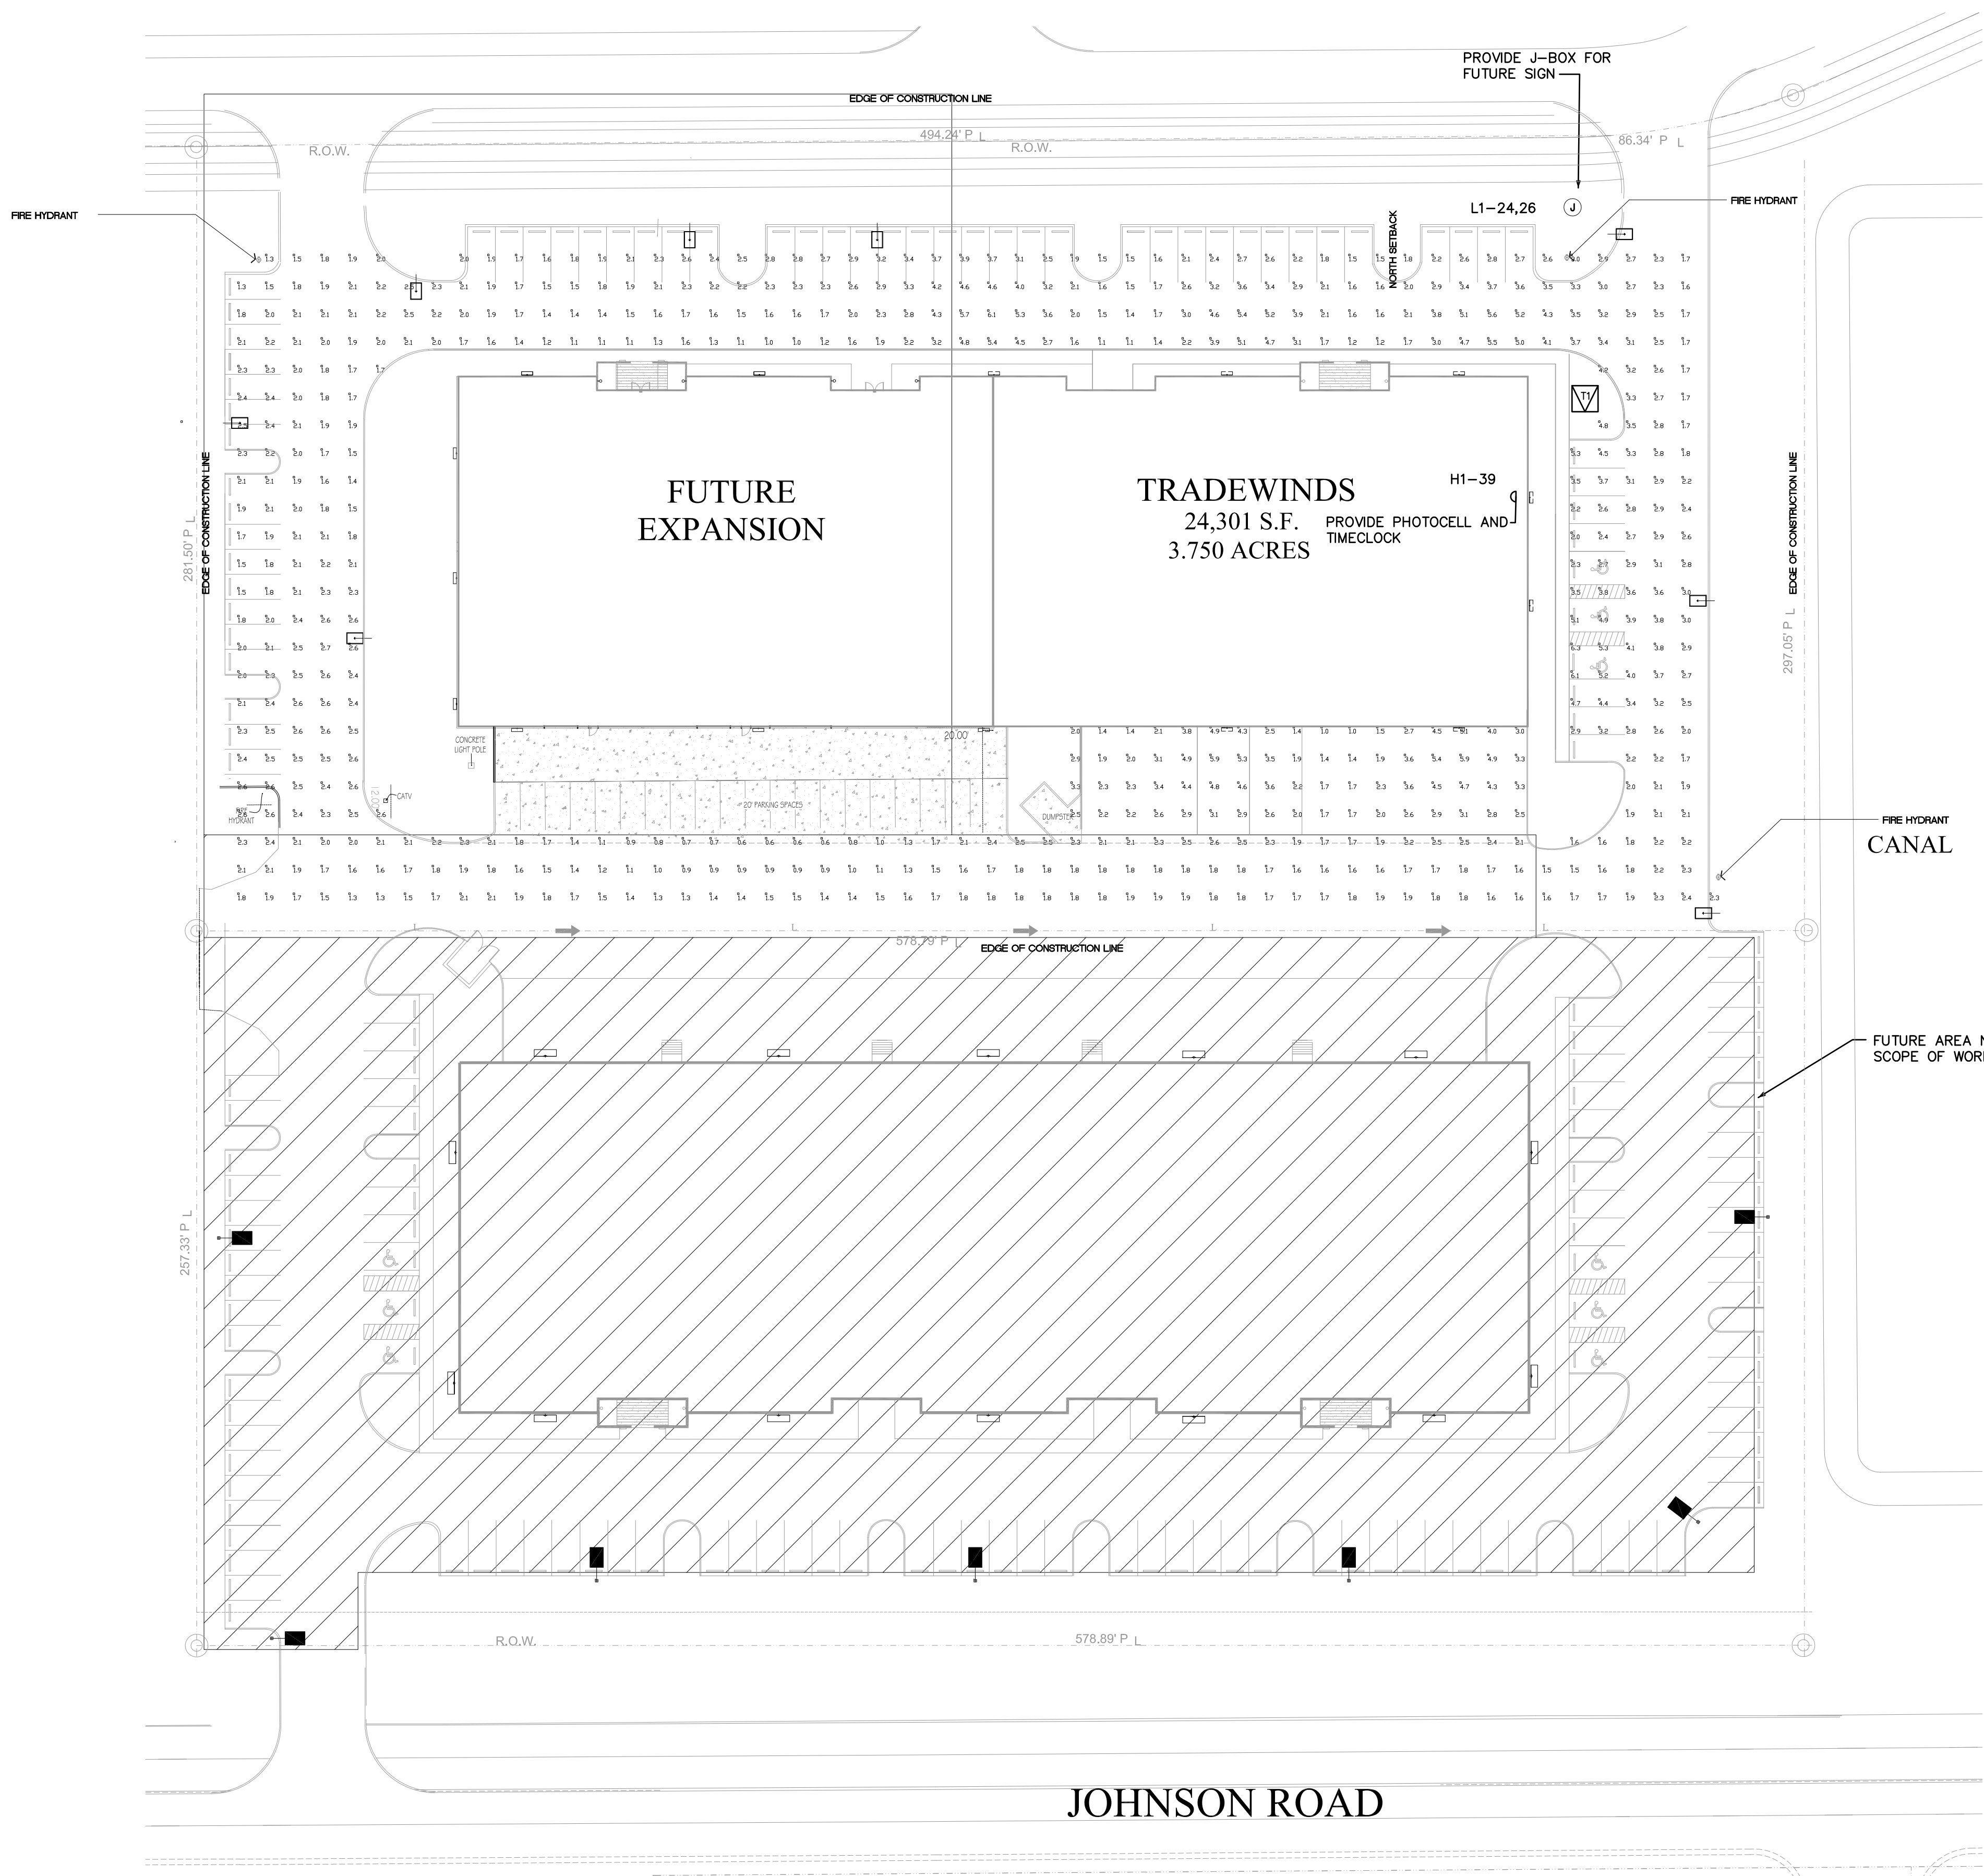

TO CONFIRM THAT THE SPECIFIED PHOTOMETRIC CRITERIA HAS BEEN MET, A COMPUTER DISK CONTAINING THE IES PHOTOMETRIC FILE FOR THE PROPOSED ALTERNATE/SUBSTITUTION MUST BE SUBMITTED TO T&T DESIGN AND DEVELOPMENT INC FOR EVALUATION NO LESS THAN 10 DAYS PRIOR TO BID. ANY ACCEPTABLE ALTERNATE/SUBSTITUTE MUST BE APPROVED IN WRITING PRIOR TO BID DATE.

(EXISTING) Luminaire Schedule					
Project: Lyons Corporate Park					
Symbol	Qty	Label	Description	Lumens	LLF
SA	22	SA	McPhilben 141-FT-400MH 27'6\"/>		
SB	17	SB	Emco ECA181-3V-400MH 30' MTG HEIGHT	36000	0.75

Numeric Summary					
Project: Lyons Corporate Park					
Label	Avg	Max	Min	Avg/Min	Max/Min
parking_Planar	2.63	6.7	0.6	4.38	11.17

Luminaire Schedule									
Symbol	Label	[MANUFAC]	Description	Qty	Arrangement	Total Lamp Lumens	LLF	Lum. Watts	Total Watts
W1	Lithonia Lighting	DSXW2 LED 30C 1000 30K T3M MVOLT	13	SINGLE	N.A.	1,000	109	1417	
W2	Lithonia Lighting	DSXW2 LED 30C 1000 30K TFTM MVOLT	8	SINGLE	N.A.	0.840	109	872	

T&T Design and Development Inc.
6810 Lyons Technology Circle
Suite 140, Coconut Creek, FL
Ph: (954) 725-0909
ttdesigninc.com
info@ttdesigninc.com
www.ttdesigninc.com

WILLIS LEASE EXPANSION

4700 LYONS TECHNOLOGY PARKWAY, COCONUT CREEK, FL 33073
Butter Construction & Development
8820 Lyons Technology Circle, Suite 100 Coconut Creek, FL 33073 Ph: 954-570-8111 - Fax: 954-570-8844

SHEET TITLE:

SITE PHOTOMETRIC

REV. DATE: 03-27-2018

ISSUE FOR: DPC SUBMITTAL

DRAWING NO.:

PH101