


PLUMBING FIXTURES & TOILET ACCESSORIES LEGEND			
MARK	MANFR.	MODEL	DESCRIPTION
1	BOBRICK	B-290/B-293	MIRRORS - ALL LOCATIONS
2	BOBRICK	B-6806 x 36"	GRAB BAR: 36" L x 1 1/2" DIA.
3	BOBRICK	B-6806-36	GRAB BAR: 42" L x 1 1/2" DIA.
4	BOBRICK	B-2111	WALL MOUNTED SOAP DISPENSER
5	BOBRICK	B-750	ELECTRIC HAND DRYER, RECESSED MOUNTED 20 AMPS (HEAVY DUTY)
6	BOBRICK	B-4388	TOILET TISSUE DISPENSER, SURFACE MOUNTED, 7" - 9" FROM FRONT OF TOILET TO CENTER OF DISPENSER
7	BOBRICK	B-270	SURFACE MOUNTED SANITARY NAPKIN DISPOSAL
8	KOHLER	K-1991-1	"BRENHAM" ADA WALL-HUNG LAVATORY
9	KOHLER	K-4991-1-ET	"BARDON" WALL-HUNG URINAL W/ AUTOMATIC FLUSH VALVE
10	KOHLER	K-4352	"ANGLESEY" FLR. MTD. TOILET W/ AUTOMATIC FLUSH VALVE
11	HINEY HIDERS	HAMMERED	"BRONZE" SOLID PHENOLIC TOILET PARTITION
12	KOALA KARE	KB 110-SSRE	SURFACE MOUNTED BABY CHANGING STATION
13			ADA ACCESSIBLE RESTROOM SIGNAGE (MEN AND WOMEN)


- NOTES:**
- FOR MOUNTING HEIGHTS ON ALL EQUIPMENT PLEASE REFER TO TOILET ACCESSORIES MOUNTING HEIGHTS THIS SHEET.
 - FOR MOUNTING HEIGHTS ON ALL PLUMBING FIXTURES SEE MOUNTING HEIGHT REFERENCES THIS SHEET. SEE PLUMBING DWGS. FOR SPECIFICATIONS.
 - ALL ACCESSORIES TO BE A.D.A. ACCESSIBLE.
 - ALL ACCESSORIES TO COMPLY WITH MANUFACTURER'S INSTALLATION INSTRUCTIONS.
 - FIXTURES SHALL BE WHITE VITREOUS CHINA UNLESS OTHERWISE INDICATED. WHERE ENAMELED IRON FIXTURES ARE SPECIFIED, THEY SHALL BE FURNISHED WITH ACID RESISTING ENAMEL.
 - PLUMBING FIXTURES SHALL BE "FIRST QUALITY" AS DEFINED AND SET FORTH IN COMMERCIAL STANDARD CS77-28. FIXTURE FITTINGS SHALL COMPLY WITH ANSI/ASTM A112.18.1M-1989. PLUMBING TRIM FOR WATER CLOSET BOWLS, TANKS AND URINALS SHALL COMPLY WITH ANSI/ASTM A112.19.5-1990.

2 RESTROOM 101 ELEVATION
SCALE : 3/8" = 1'-0"

3 TOILET ACCESSORIES LEGEND

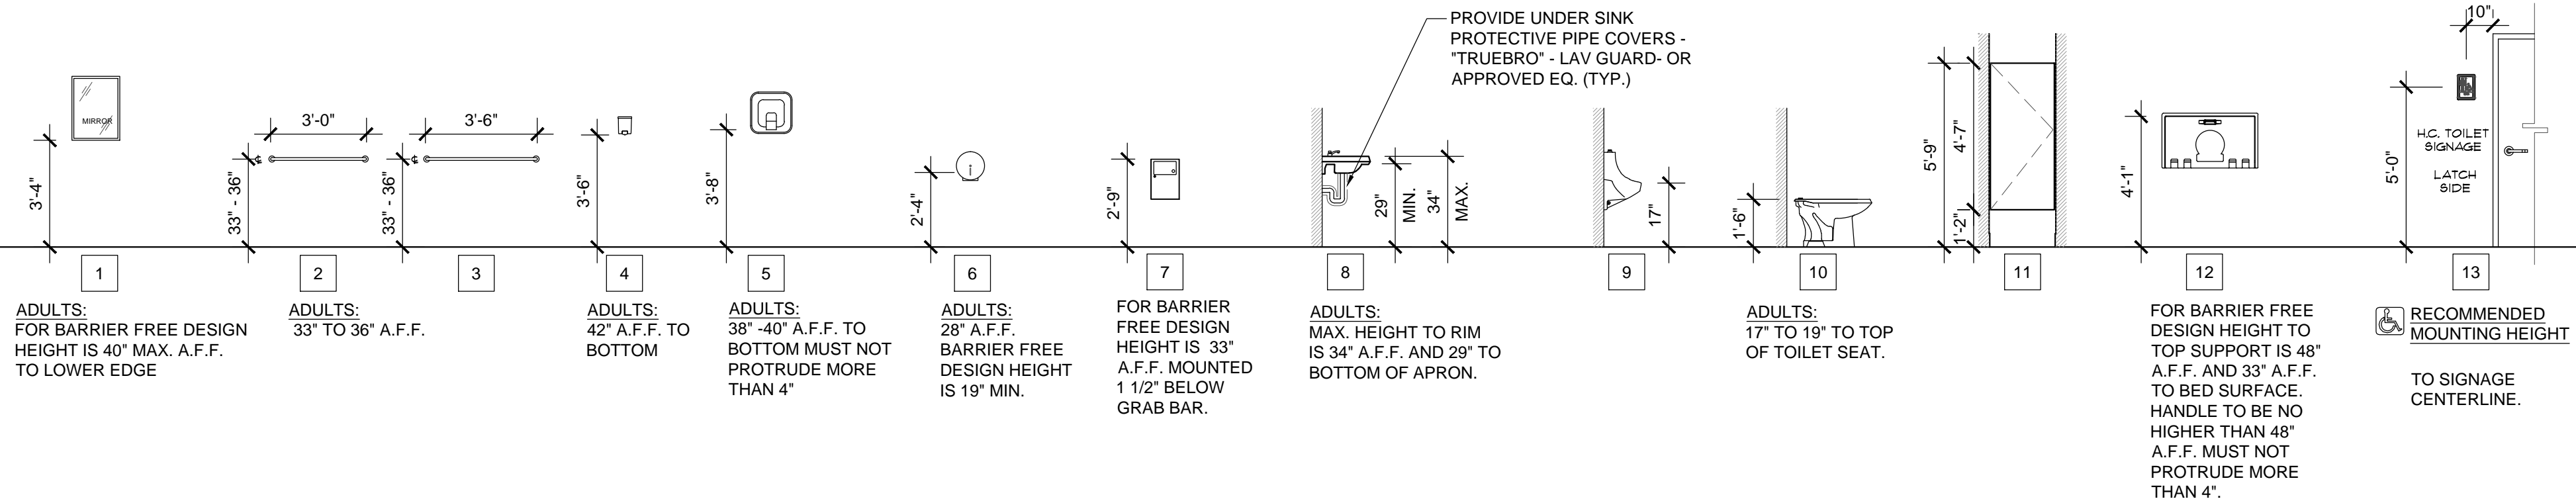

4 TOILET ACCESSORY MOUNTING HEIGHTS
SCALE : 1/4" = 1'-0"

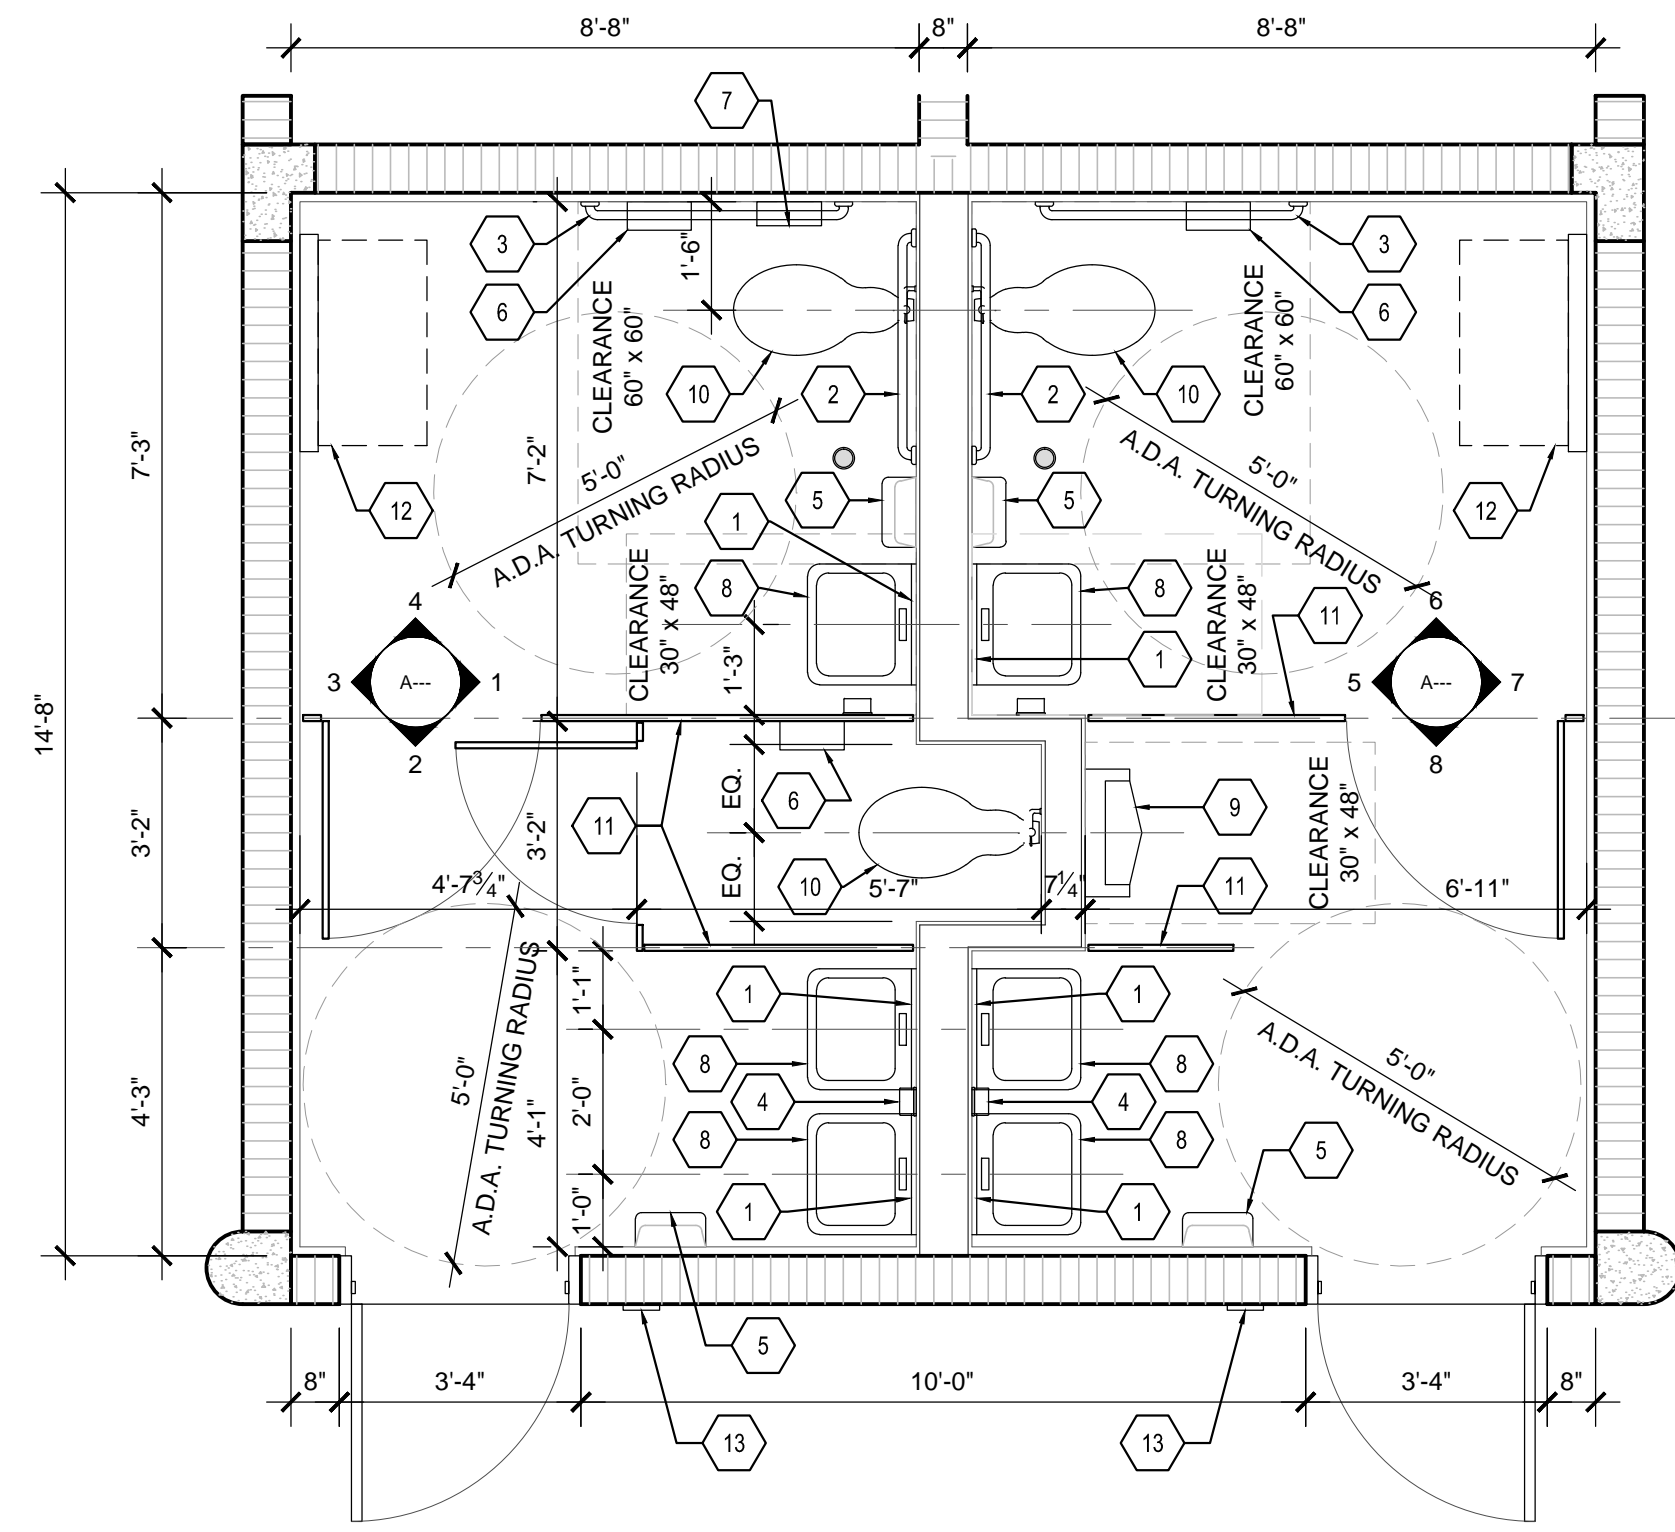

5

1 ENLARGED RESTROOM PLAN
SCALE : 3/8" = 1'-0"

WINDMILL PARK

700 LYONS ROAD
COCONUT CREEK, FL 33063

CLIENT: CITY OF COCONUT CREEK

REV	DATE	DESCRIPTION
1	12/14/15	DRG REVIEW COMMENTS

DESIGN DELIVERABLE: PERMIT SET
ISSUE DATE: 01/26/16

PROJECT NUMBER: 1252-140622

DRAWN BY: KW

CHECKED BY: MS

Copyright (c) by SYNALOVSKI ROMANIK SAYE
All Rights Reserved.

**DOG PAVILLION
RESTROOM ENLARGED
PLAN & ELEVATIONS**

SHEET NUMBER:

A2-2.1