


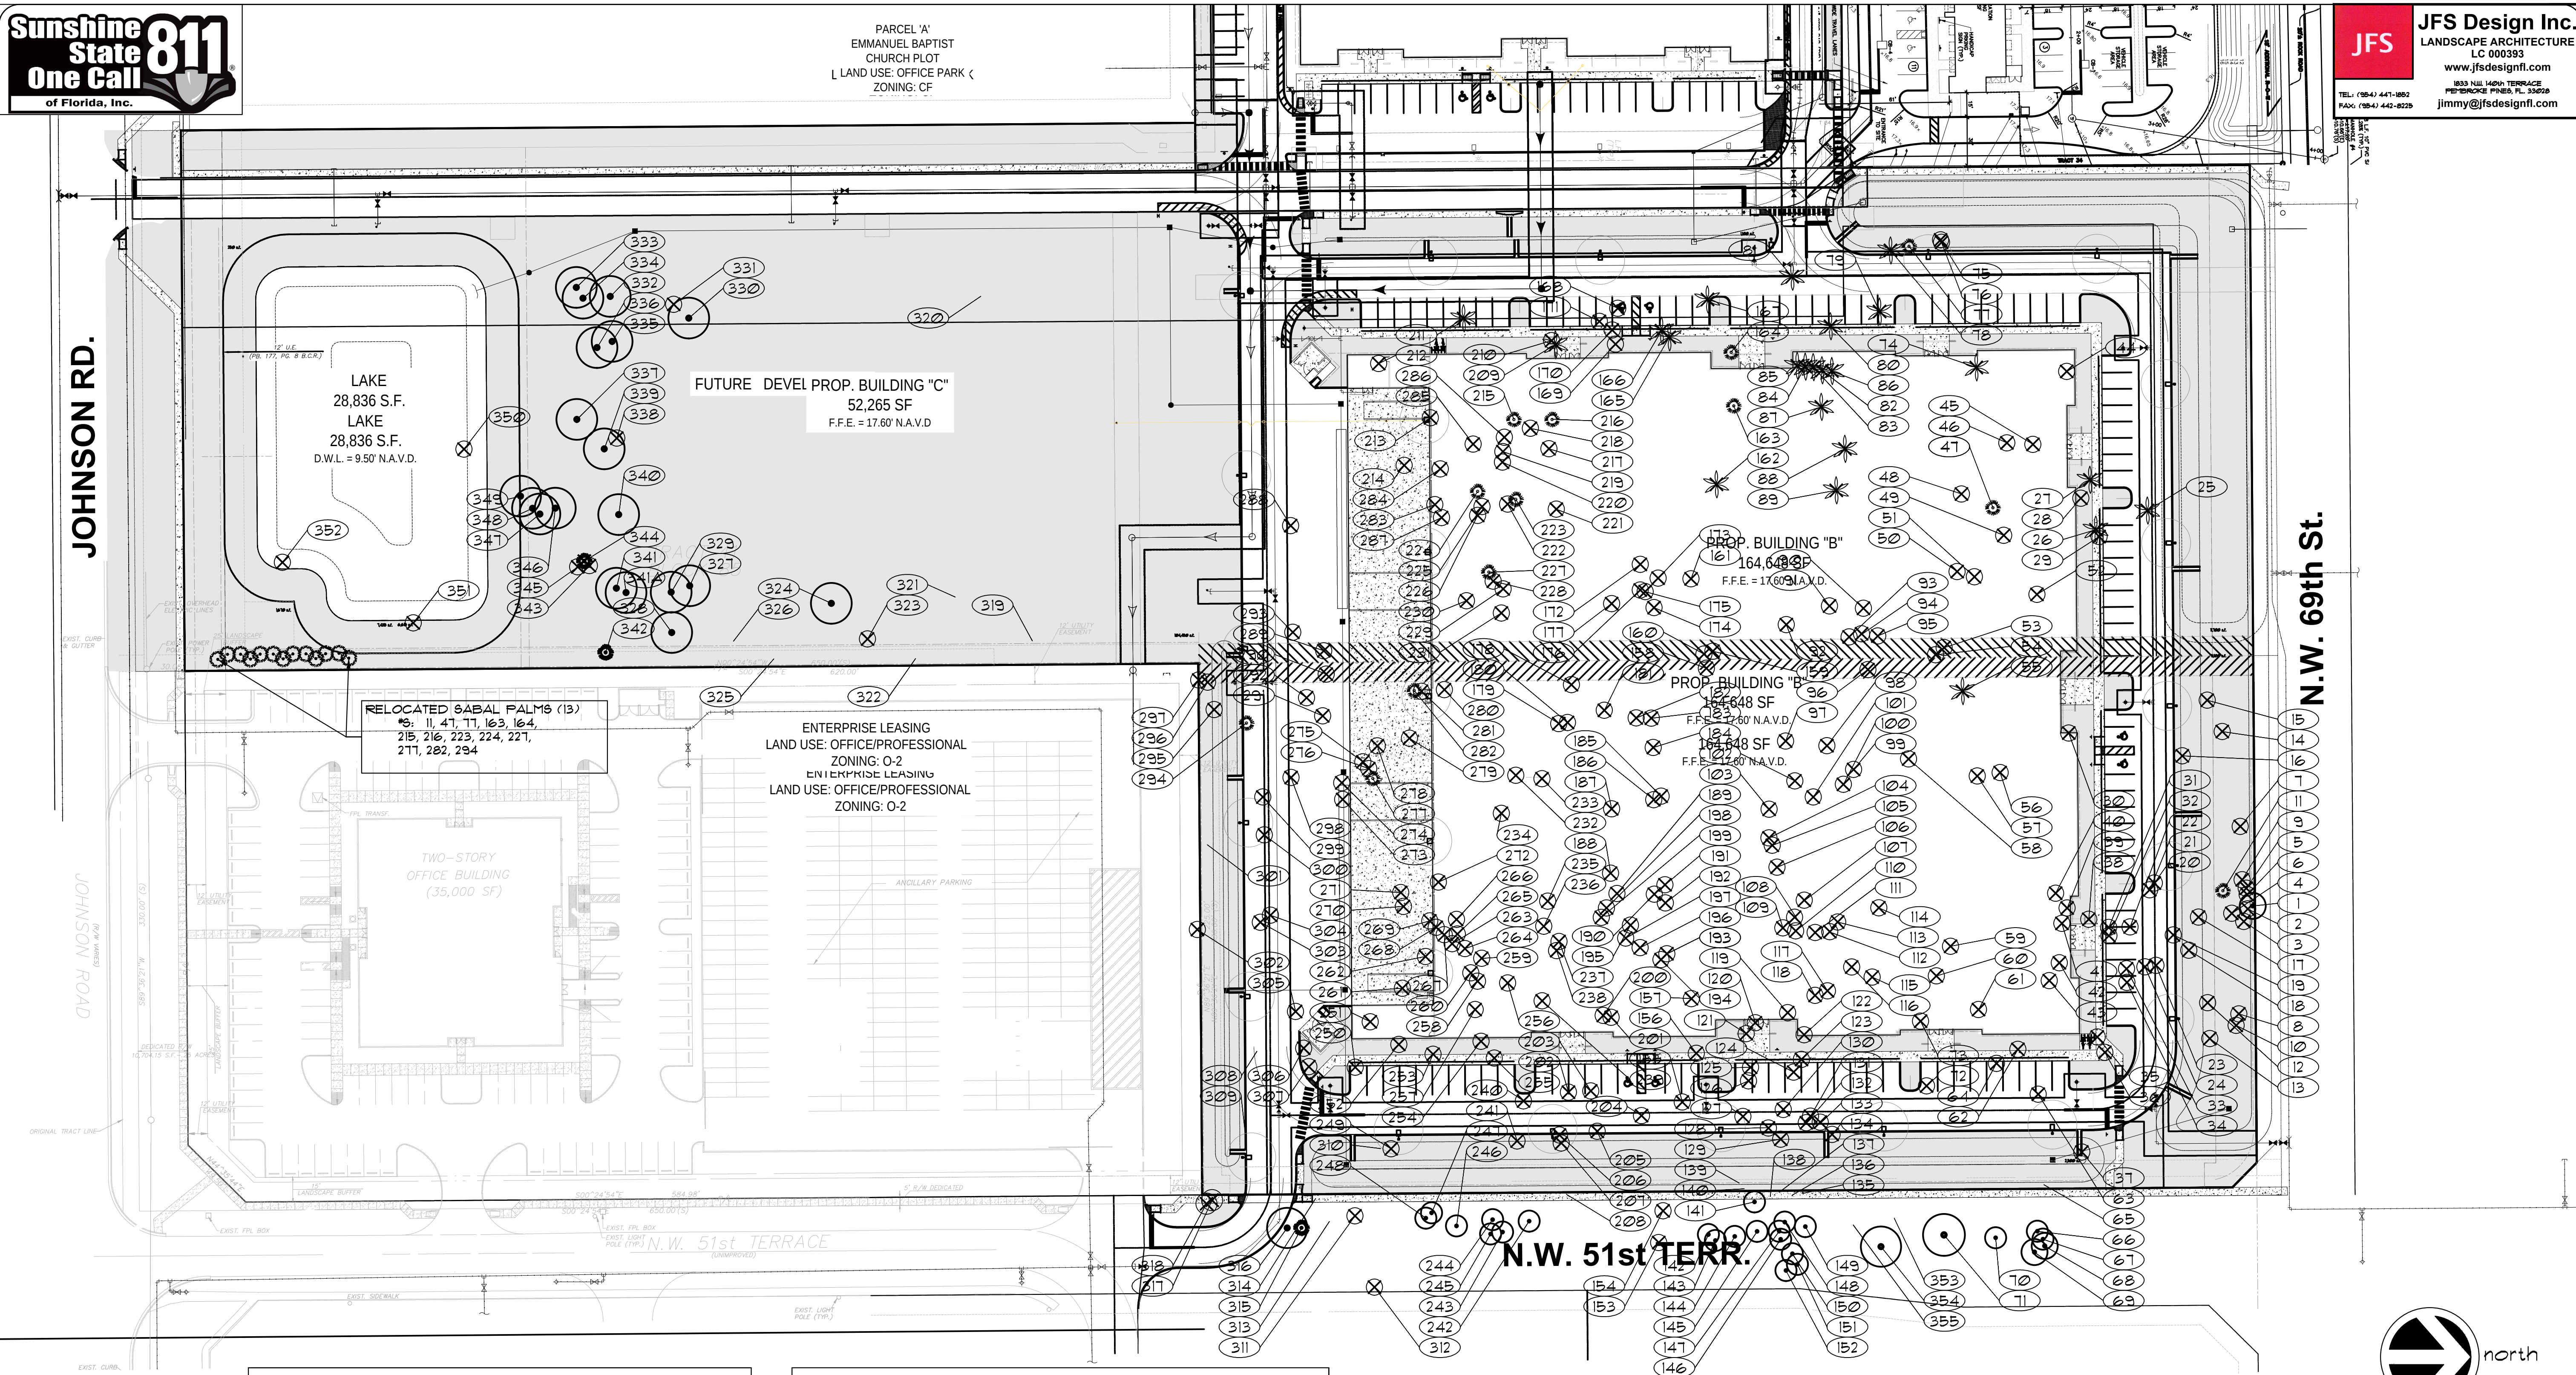

TREE TRANSPLANTING
PROCEDURAL SPECIFICATION

PURPOSE: TO MAXIMIZE THE SUCCESS OF TREE TRANSPLANTING OPERATIONS.

ALL STANDARDS SHALL MEET OR EXCEED THE ANSI A300 (PART 6)-2006 (TRANSPLANTING) STANDARD PRACTICES AND ANY APPLICABLE LOCAL CODES.

CONTRACTOR SHALL EMPLOY AN ISA CERTIFIED ARBORIST WITH VERIFIABLE TREE TRANSPLANT EXPERIENCE AS THE 'EXPERT ARBORIST OF RECORD' TO CARRY OUT THE FOLLOWING DUTIES:

SHALL PROVIDE A TREE RELOCATION PLAN FOR APPROVAL BY THE OWNER'S AGENT BEFORE ANY WORK CAN COMMENCE.


SHALL MAKE SITE VISITS PRIOR TO ANY RELOCATION WORK TO INSURE THAT PROPER PREPARATION WORK IS PERFORMED TO THE TREE RELOCATION GUIDELINES.

SHALL MAKE SITE VISITS DURING RELOCATION WORK TO INSURE WORK IS BEING PERFORMED TO THE TREE RELOCATION GUIDELINES.

SHALL DOCUMENT ALL INSPECTIONS AND PROVIDE REPORT TO THE OWNER'S AGENT WITHIN 5 BUSINESS DAYS OF SITE VISIT.

SHALL SUBMIT PRIOR TO FINAL ACCEPTANCE BY OWNER'S AGENT, A POST-TRANSPLANT CARE GUIDE FOR UP TO THREE YEARS THAT INCLUDES WATERING, FERTILIZATION, PRUNING, PEST CONTROL, STAKING, ETC., FOR APPROVAL.

POST TRANSPLANT WATERING TO PROVIDE MOISTURE AND REDUCE ANY EXCESSIVE STRESS DUE TO DESSICATION. WATERING TO BE ADJUSTED ACCORDING TO CONDITIONS AND AT THE SUPERVISION AND DIRECTION OF THE ISA CERTIFIED ARBORIST.

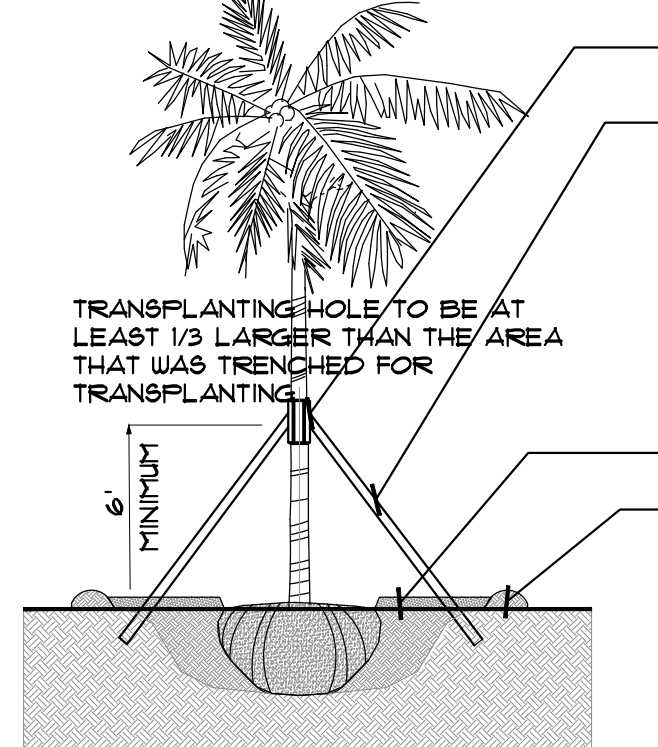

PALM TRANSPLANT DETAIL

REF: 'THE LANDSCAPE MANUAL' DADE CO.
DEPT. OF PLANNING & ZONING, 2001

TRANSPLANT OPERATIONS TO BE SUPERVISED BY AN ISA CERTIFIED ARBORIST.

WOOD BATTENS FOR SUPPORT BRACES DO NOT NAIL TO PALM

WOOD BRACES PROVIDED - A MINIMUM OF THREE - TO BRACE AND SUPPORT PALM. THE CONTRACTOR SHALL BE RESPONSIBLE TO ADD BRACING NECESSARY TO PROVIDE FULL SUPPORT AND CHECK REGULARLY AND RE-BRACE AS NEEDED. 4" X 4" AS NEEDED FOR ROYAL PALMS.


SET THE TREE NO DEEPER THAN ITS ORIGINAL CONDITION

RECYCLED MULCH - 3" DEPTH

SAUCE ALL AROUND FOR WATER RETENTION

BACKFILL WITH A MIXTURE OF 50% NATIVE SOIL AND 50% OF 50:50 TOPSOIL:SAND MIXTURE

WATER TO ELIMINATE AIR POCKETS WITH WATER HOSE APPLICATION OF FLOOD WATERING.

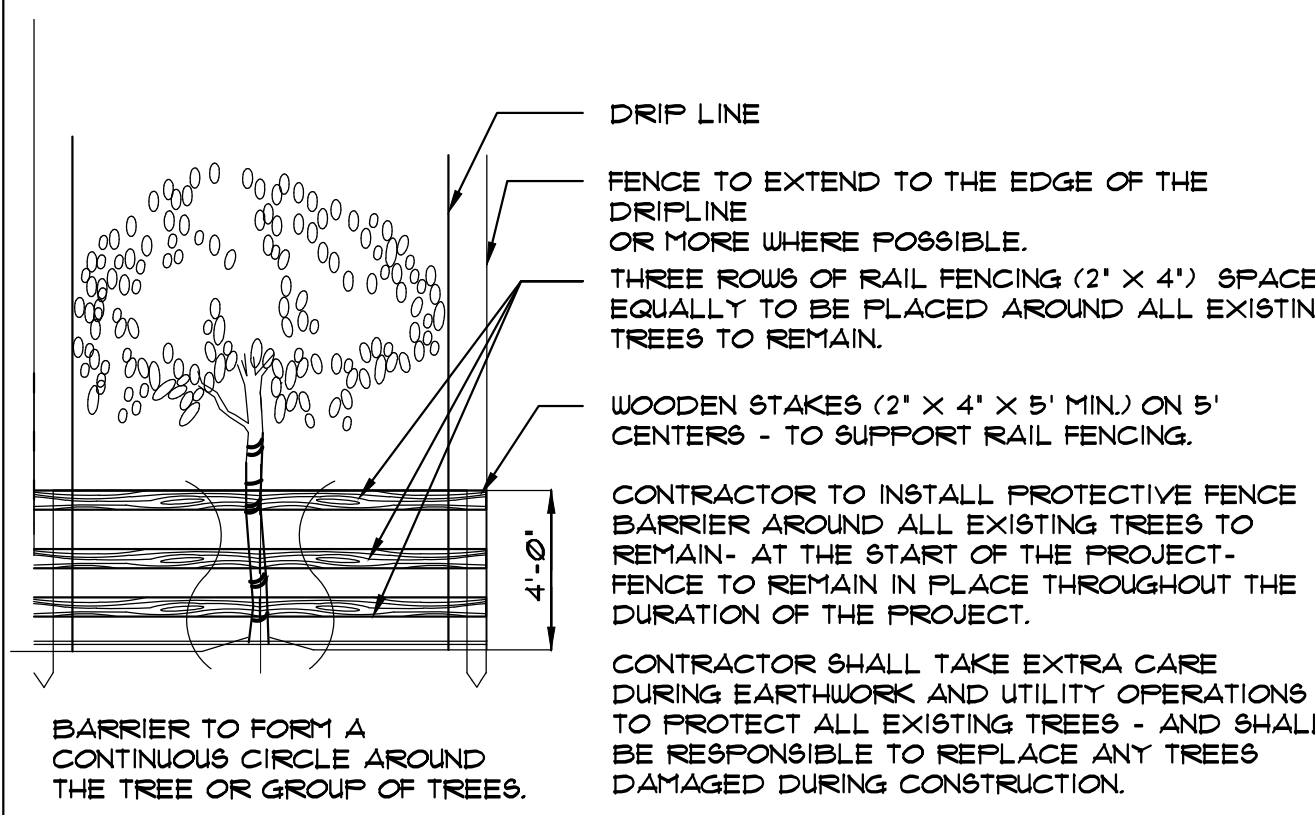

TREE PROTECTION DETAIL


N.T.S.

TREE
DISPOSITION PLAN

A WRITTEN TREE REMOVAL PERMIT IS REQUIRED FROM THE CITY OF COCONUT CREEK PRIOR TO REMOVAL OF ANY TREES FROM THIS SITE.

SEE SHEET TD-2 FOR TREE INVENTORY, NOTES, ETC.

SEE LANDSCAPE PLANS FOR PROPOSED LANDSCAPE PLANTINGS, LANDSCAPE LEGEND, SPECIFICATIONS, NOTES, DETAILS, ETC.

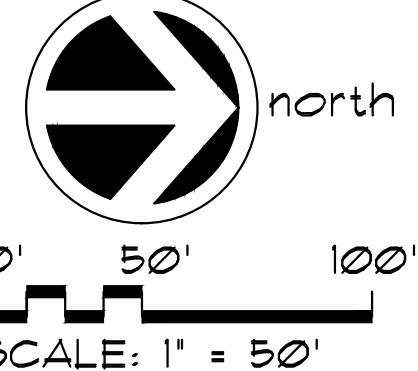

NO.	DATE	DESCRIPTION
1	02/09/15	FOR DDC COMMENTS
2	04/11/16	FOR DDC COMMENTS

JOHNSON TECHNOLOGY PARK II
CITY OF COCONUT CREEK
FLORIDA

DATE: Apr. 2016
SCALE: 1"=50'
DESIGNED BY: M.G.
DRAWN BY: M.A.S.
JOB NUMBER 13-3581
SHEET No. TD-1
SEAL JAMES P. SOGASH R.L.A. # 000192