




**Architects
Engineers
Planners**
901 Ponce de Leon Blvd., Suite 900
Coral Gables, Florida 33134
Voice: 305.445.2900 Fax: 305.445.3361
AAC002142 EB00005022

New Construction of:
Lyons - Sawgrass Shopping Center
FOR: LYONS TRADE CENTER, LLC
Coconut Creek, Florida

JOB NUMBER
00343-001
FILE No. : 0034301A1.0
DRAWN : MM/KC
REVIEWED: DGH/JFS
CHECKED : JFS

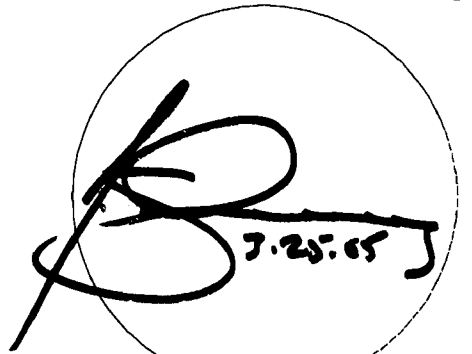

Javier F. Salzman, AIA
Reg. No.: AR0014410
These drawings and the designs here
illustrated are the sole property of
Corzo Castilla Carballo Thompson Salzman, P.A.
and may not be reproduced in whole
or in part without express permission.

DATE : 03/25/05

ISSUE


--	--

REVISIONS

SHEET TITLE

FLOOR PLAN
SHEET NUMBER

A1.0

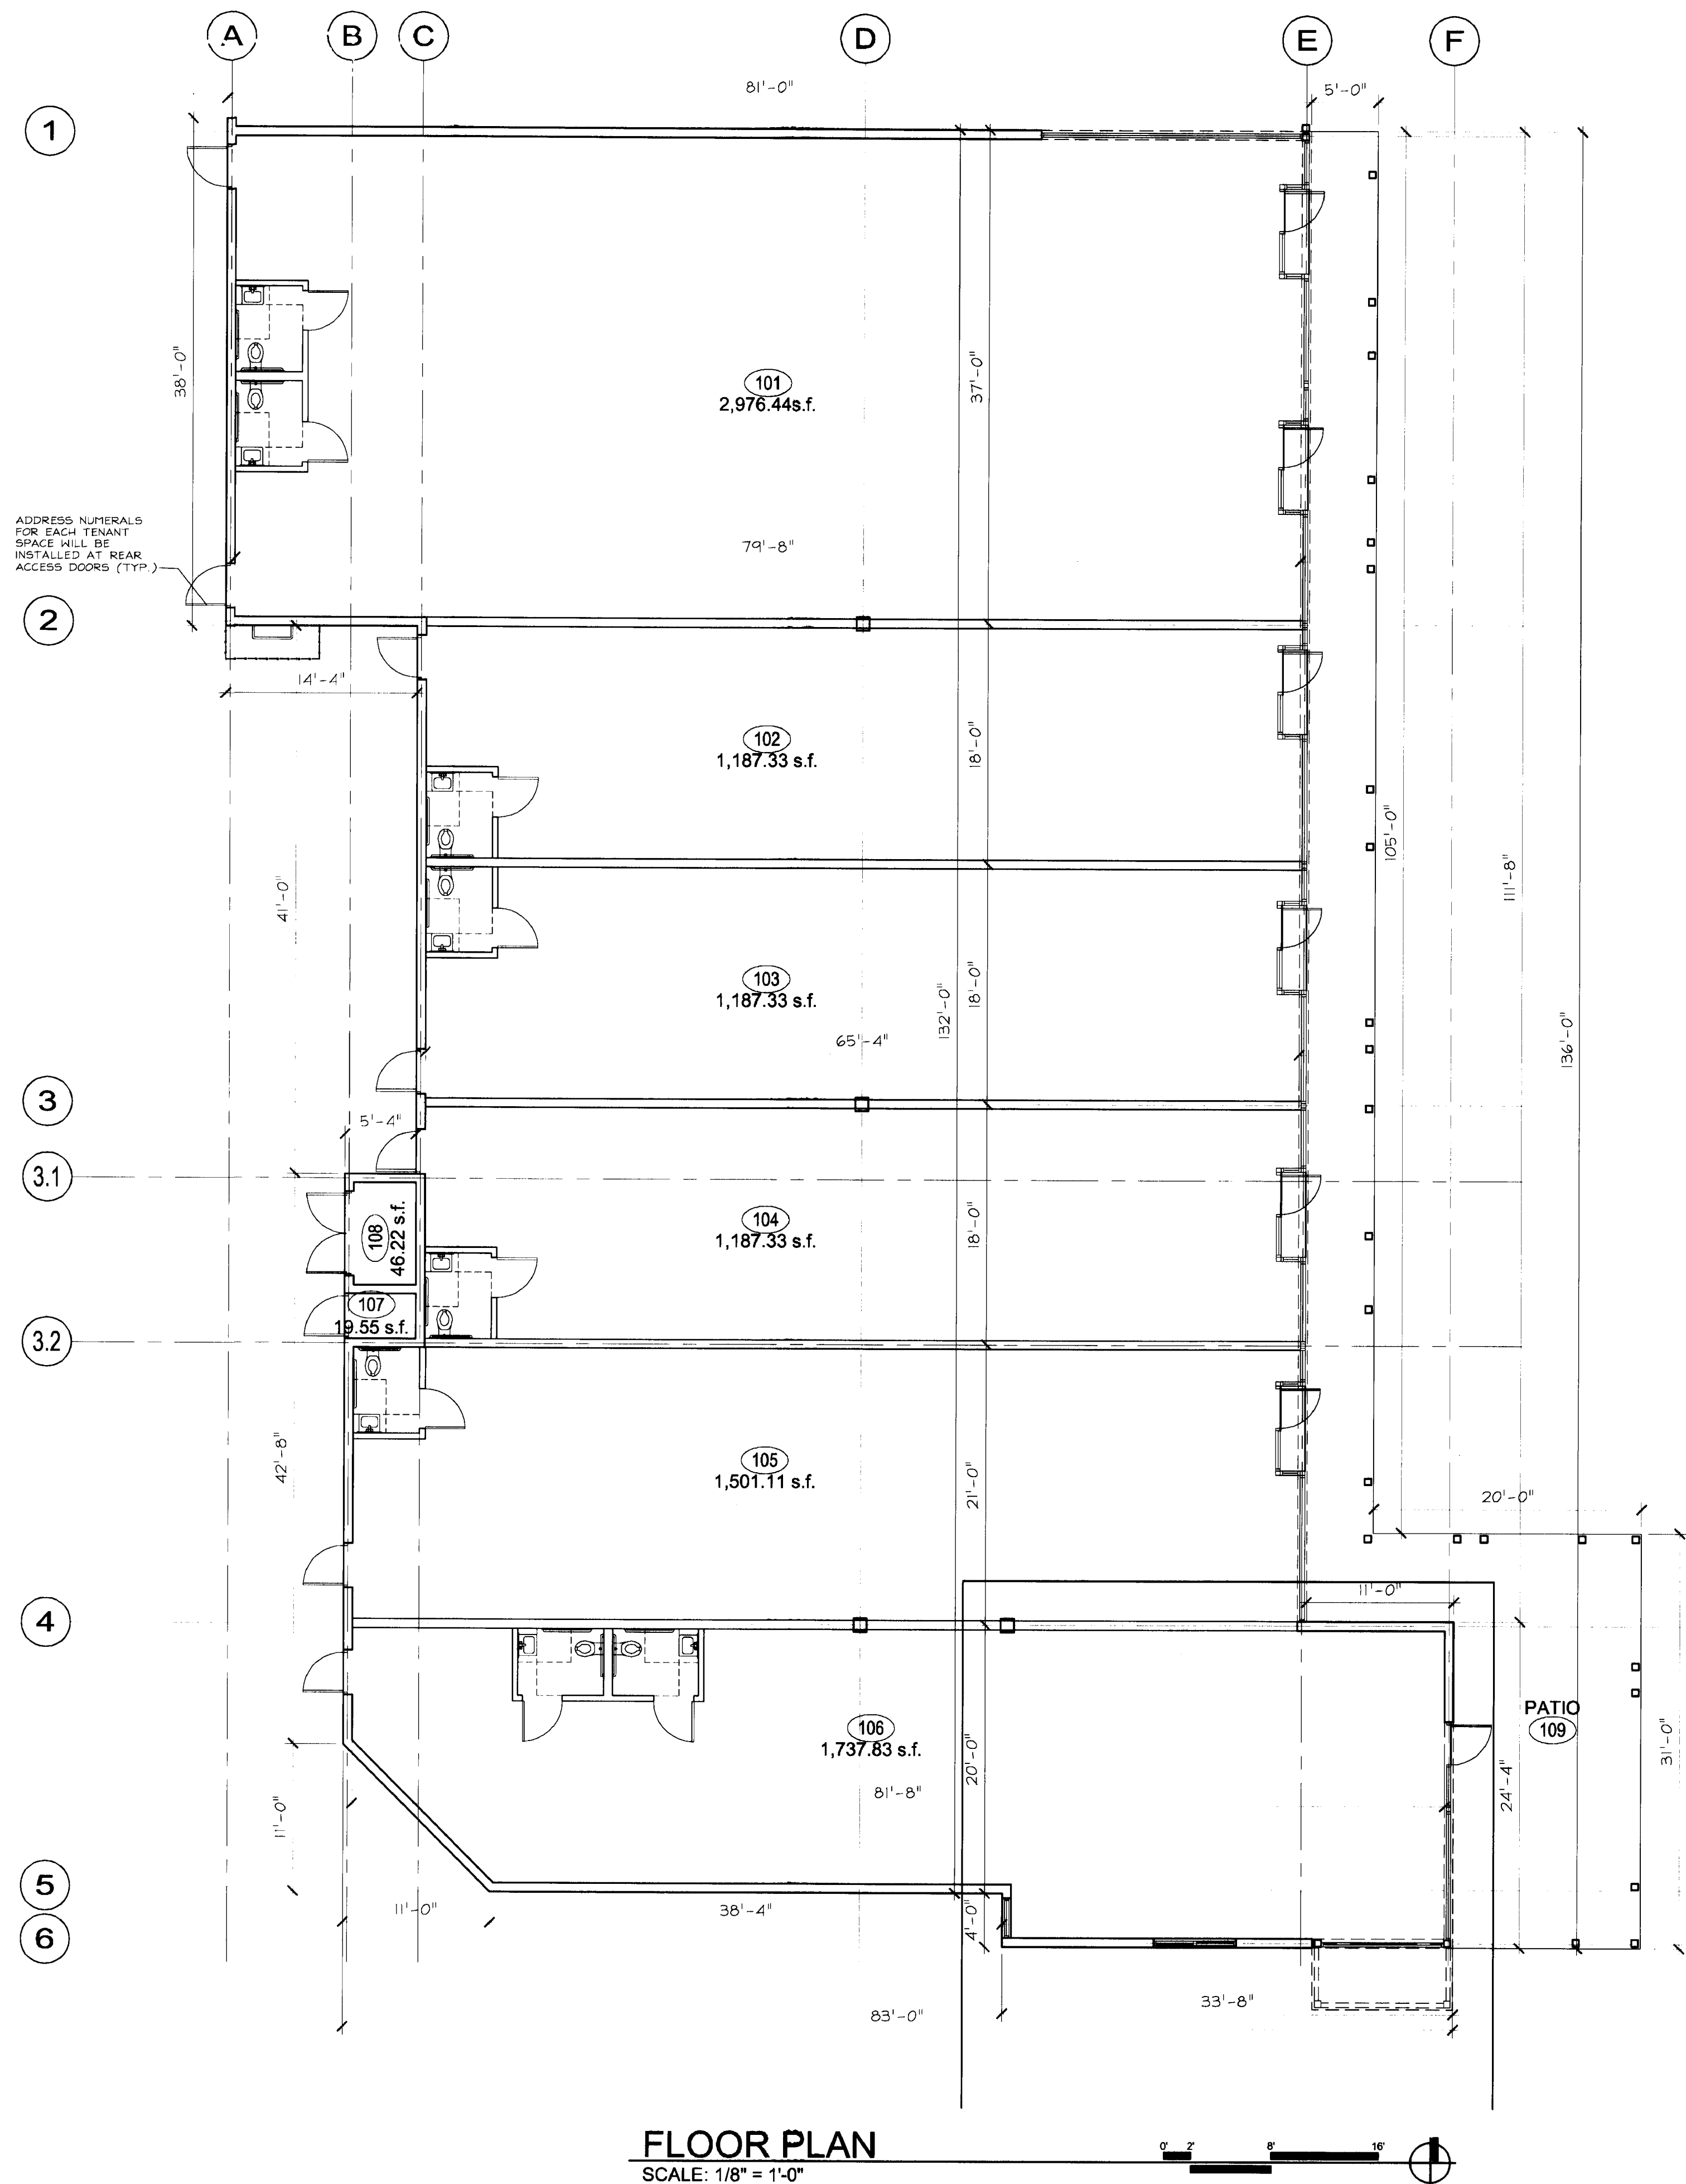

FLOOR PLAN
SCALE: 1/8" = 1'-0"