




**DORSKY  
 HODGSON  
 PARRISH  
 YUE**


AA 26001261  
 Architecture  
 Planning  
 Interiors  
 Environmental  
 Graphics  
 Cleveland  
 Fort Lauderdale  
 Washington DC

Fl. Lauderdale, Florida 33394  
 Phone (954) 524-8686  
 Fax (954) 524-8604

THIRD FLOOR PHOTOMETRIC FLOOR PLAN - BUILDING PG-3  
 APPLICANT: COCONUT CREEK DEVELOPMENT LLC  
 SOUTH WEST CORNER OF LYONS ROAD AND WILES ROAD, COCONUT CREEK, FLORIDA  
 ALL RIGHTS RESERVED  
 Job No.: 2005113  
 Drawn: [Name] Checked: [Name] Date: 03-28-06

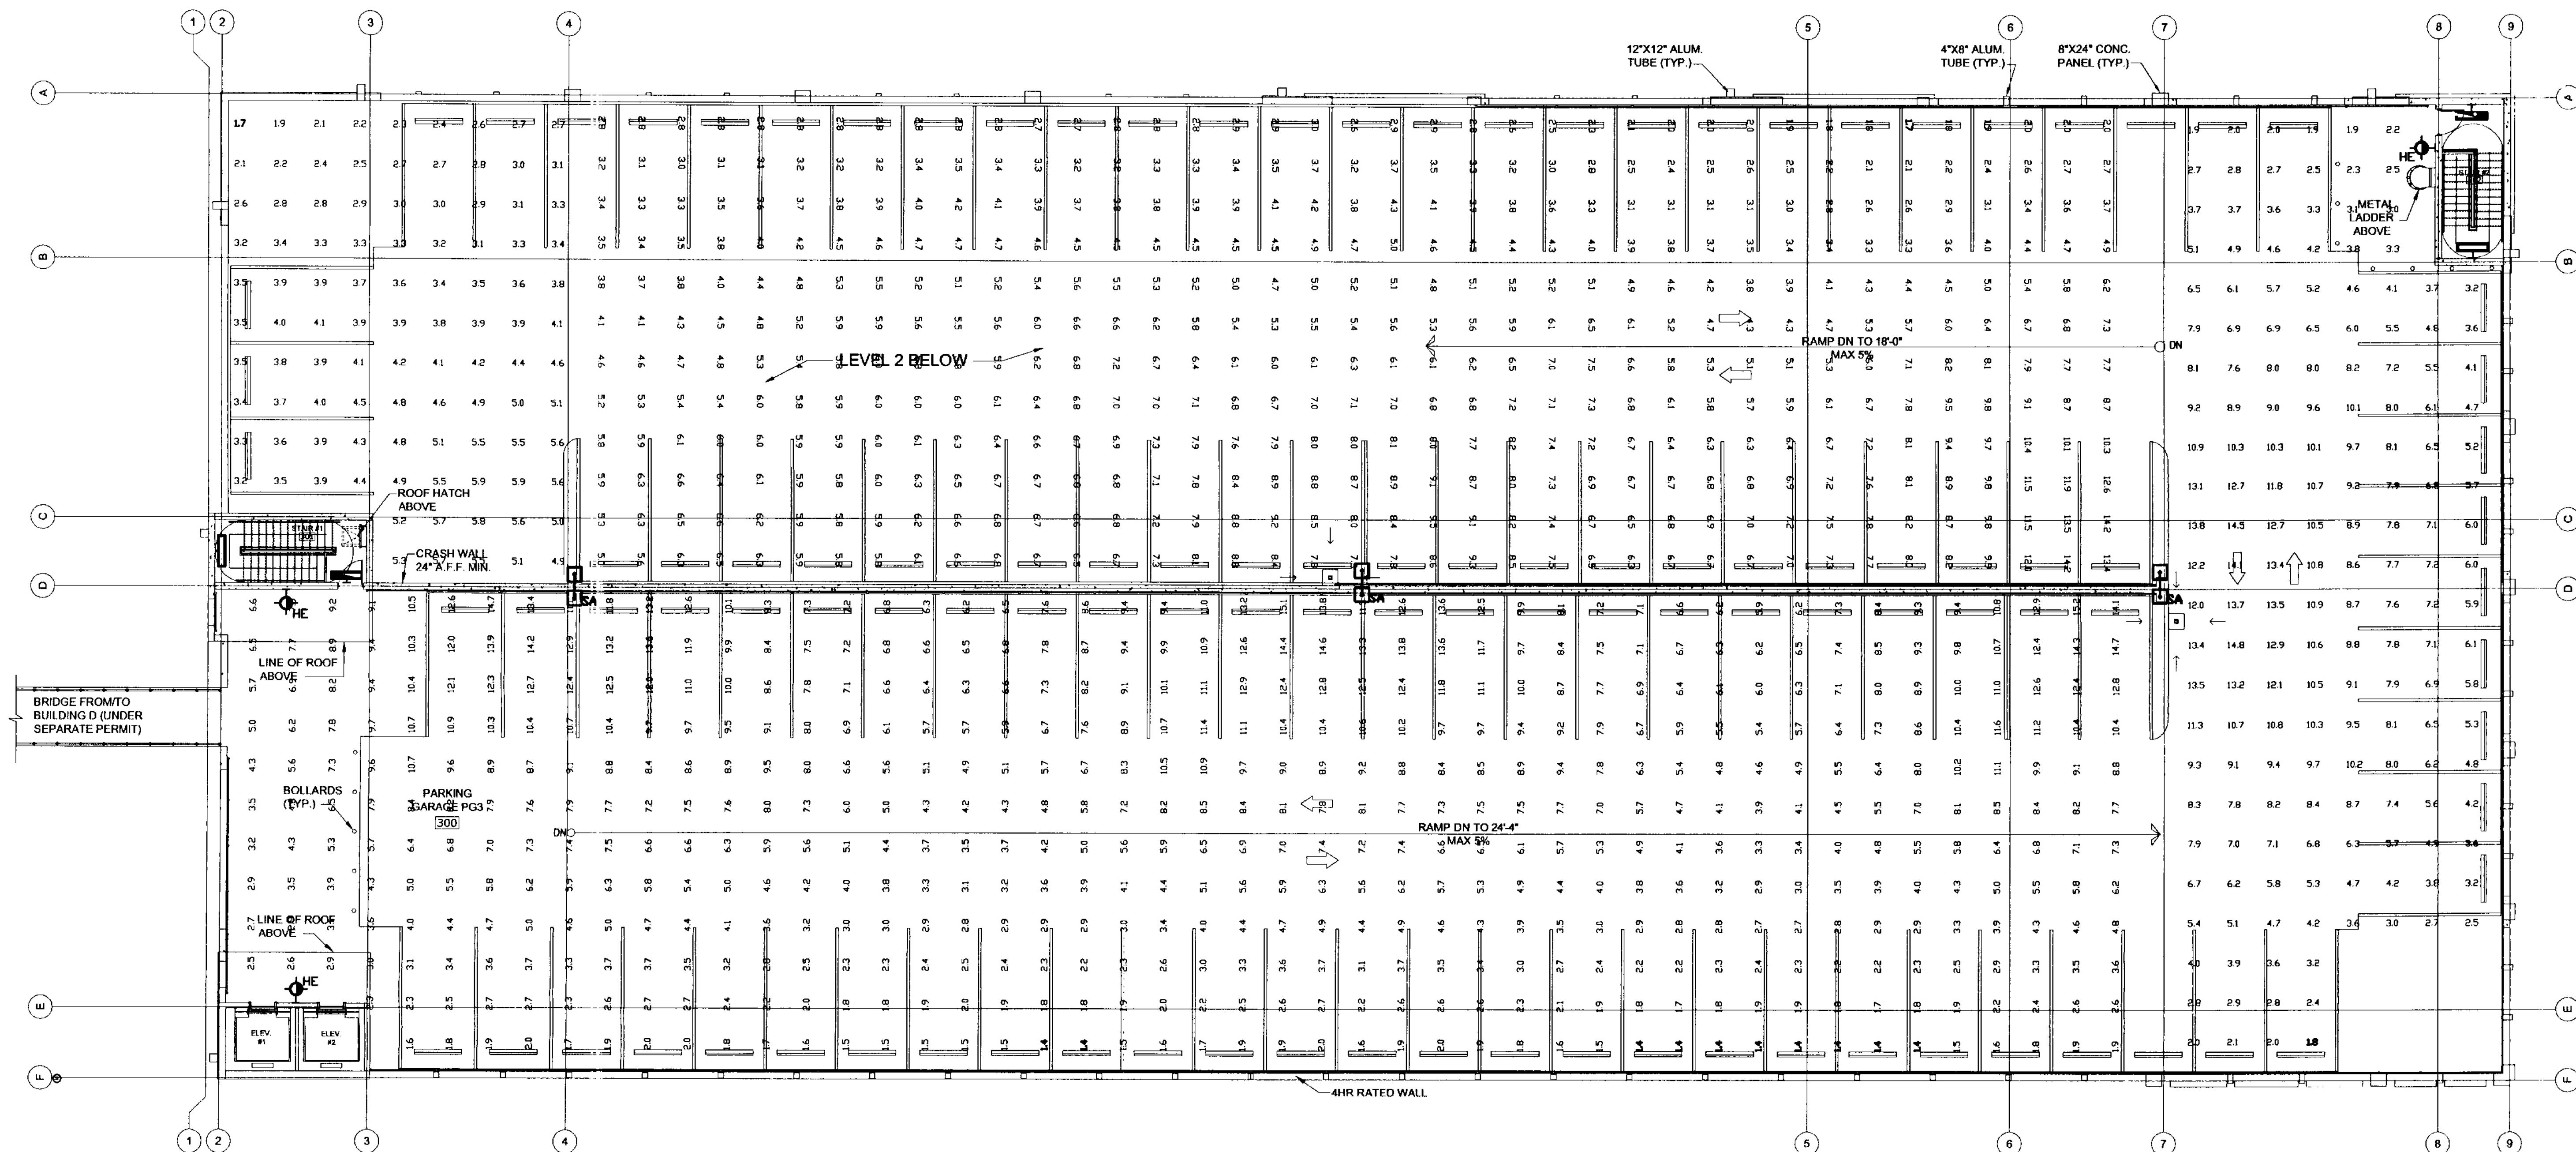

**THIRD FLOOR PHOTOMETRIC FLOOR PLAN - BUILDING PG-3**  
 3/32" = 1'-0"

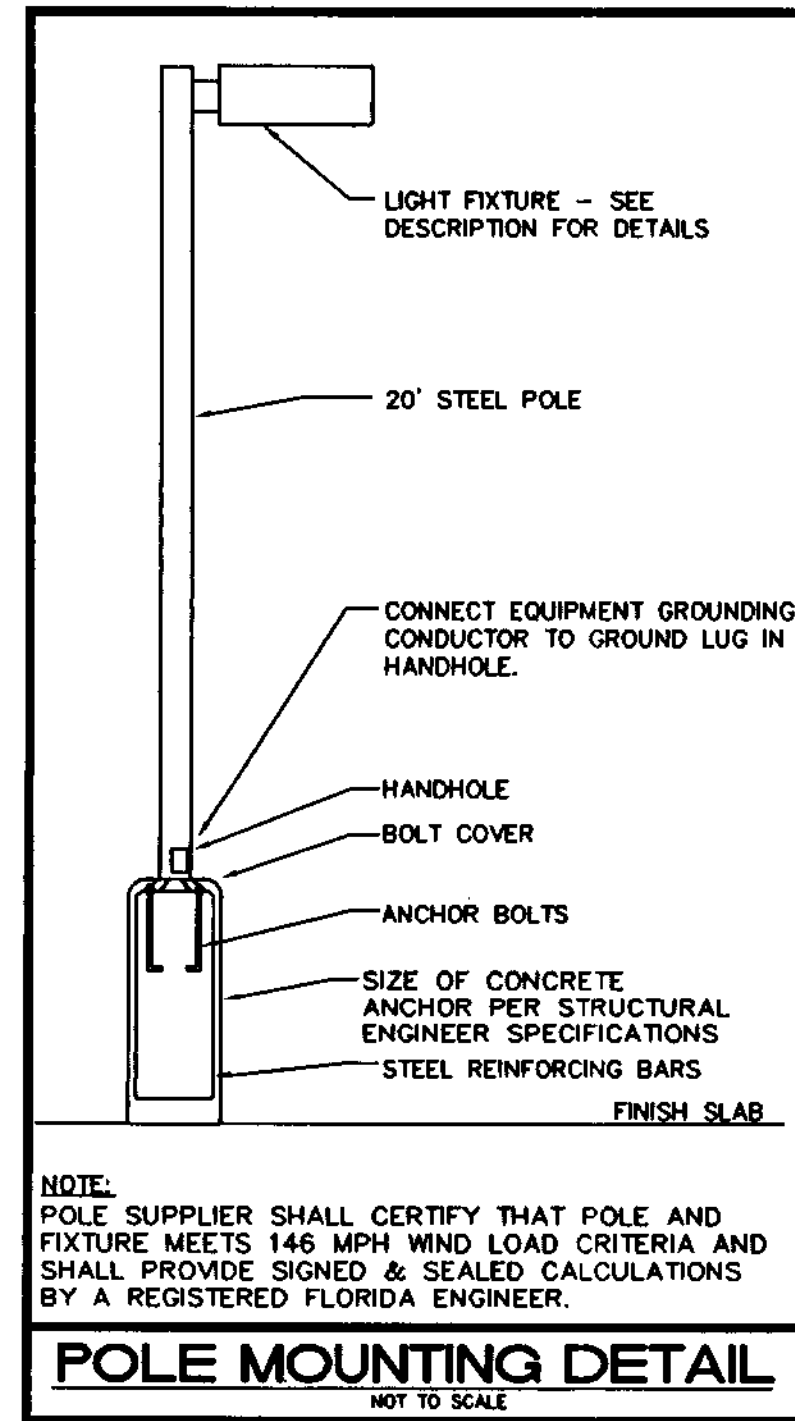

Luminaire Schedule: PROMENADE CCTC 3Rd LEVEL REV4

Symbol	Qty	Label	Lumens	Description	LLF	NOTE
+	3	HE	3200	LUMINAIRE: LPL58-IPLC42-EM	0.750	WALL MNT @ 9' AFG
⊠	3	SA	100000	EMCD: ECA 2310VRNC_875PSMH	0.750	POLE MNT @ 20' AFG

Statistical Area Summary: PROMENADE CCTC 3Rd LEVEL REV4

Label	Avg	Max	Min	Avg/Min	Max/Min
SITE	5.88	15.2	1.4	4.20	10.86

