


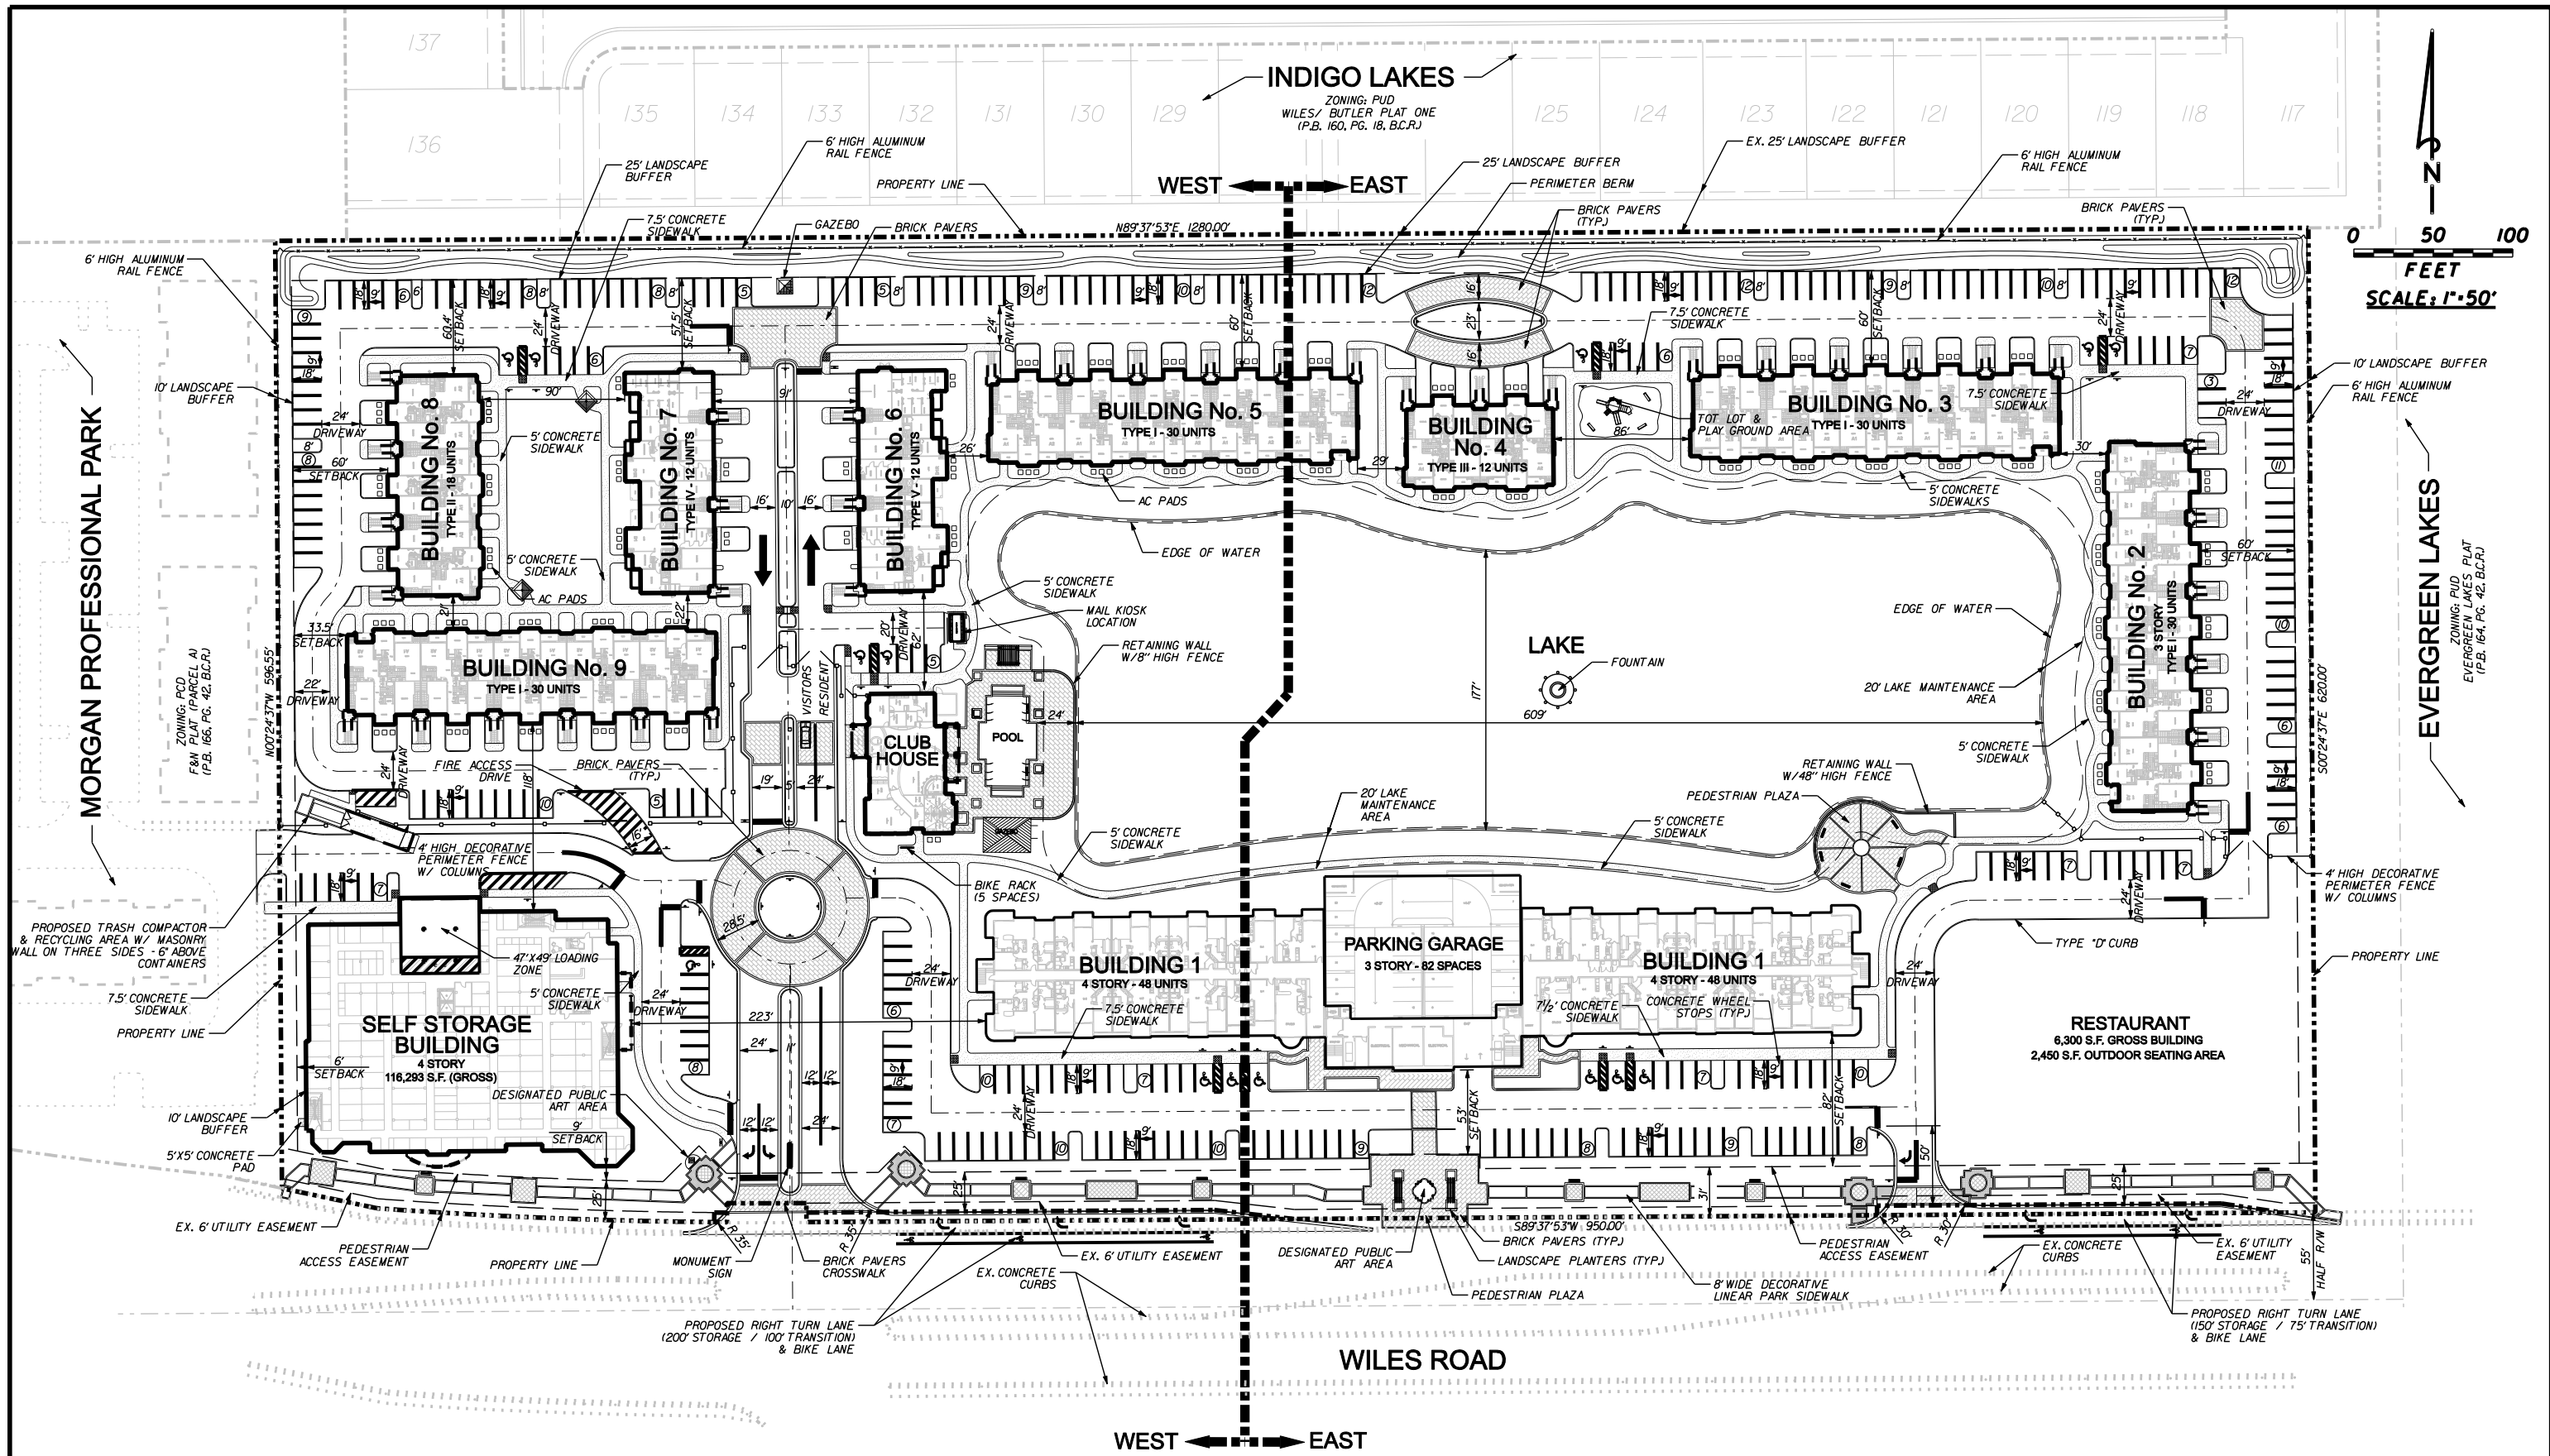

NO.	DATE	BY	REVISION
8	10/12/10	M.K.	RELOCATED TRASH COMPACTOR
7	5/27/10	M.K.	REVISED PER D.R.C. REVIEW COMMENTS
6	1/22/10	A.Q.	REVISED PER D.R.C. REVIEW COMMENTS
5	12/7/09	A.Q.	REVISED PER D.R.C. REVIEW COMMENTS
4	9/24/09	A.Q.	REVISED PER D.R.C. REVIEW COMMENTS
3	6/25/09	M.K.	UPDATED SITE PLAN & REVISED PER D.R.C. REVIEW COMMENTS
2	9/26/08	M.K.	REVISED PER D.R.C. REVIEW COMMENTS
1	6/25/08	G.H.	REVISED PER D.R.C. REVIEW COMMENTS

Designed by: A.Q. Date: 4/08
 Drawn by: G.H. Date: 4/08
 Checked by: N.S. Date: 4/08

Approved by: ANTONIO QUEVEDO
 Registered Engineer Number 59471
 State of Florida

Date: 10/21/2010



HSQ GROUP, INC.
 Consulting Engineers • Planners • Transportation
 1489 West Palmetto Park Road, Suite 340
 Boca Raton, Florida 33486 (561) 392-0221
 Authorization Number 26258

BEL LAGO
MASTER SITE PLAN

PROJECT NUMBER
 0906-14
 SHEET NUMBER
 SP-2